

Le Velo

48 Baywater Drive,
Wentworth Point, NSW, 2127



Drawing List

No	View Name	Scale Value	1:
A01	Sun Study 21/06/19 9AM	2000	
A01	Sun Study 21/06/19 12PM	2000	
A01	Sun Study 21/06/19 3PM	2000	
A01	Sun Study 21/12/19 9AM	2000	
A01	Sun Study 21/12/19 12PM	2000	
A01	Sun Study 21/12/19 3PM	2000	
A02	Level 1	100	
A03	Level 1 RCP	100	
A04	Level 2	100	
A05	Level 2 RCP	100	
A06	Section 1	50	
A07	Section 2	50	
A08	Section 3	50	
A09	Bar Plan	20	
A10	Bar View 1		
A11	Bar Elevation 1	20	
A11	Bar Elevation 2	20	
A12	Bar Section 2	20	
A12	Bar Detail Section	10	
A13	Bar Shelvig	20	
A13	Bar Shelving Detail	2	
A14	Take-Away Bar Section	20	
A14	Take-Away Bar Front		
A14	Take-Away Bar Back		
A15	Staircase lower	20	
A15	Staircase Upper	20	
A15	Staircase View 1		
A15	Staircase View 2		
A16	Staircase Elevation 1	20	
A16	Staircase Elevation 2	20	
A17	Staircase Section 3	20	
A17	Staircase Base Detail	10	
A17	Staircase Level 2 Detail	10	
A18	Bike Stand 3	20	
A18	Bike Stand 2	20	
A18	Bike Stand 1	20	







Room Schedule

Level	Name	Area
Level 1	F	8 m²
Level 1	M	6 m²
Level 1	Cold Room	4 m²
Level 1	D	4 m²
Level 1	Take Away Bar	Not Enclosed
Level 1	Bar	29 m²
Level 1	Kitchen	19 m²
Level 1	Wash and Prep	9 m²
Level 1	Storage	17 m²
Level 1	Seating Area	116 m²
Level 1	Staff	4 m²
Level 2	Open Gallery / Retail Space	268 m²

LEGEND

Cut Material			
	Existing Structure		Concrete
	Plaster Board		Steel
	Tiles		Glass
Wall Types			
	WT1	2mm glue + 70mm Recycled Brick	
	WT2	2mm glue + 70mm Recycled Brick + 2mm Artwork finish	
	WT3	Timber stud wall 100 x 50 w/ 13mm FC + 2mm glue + 3mm Micro topping finish to each side	
	WT4	13mm FC + 2mm glue + 3mm Micro topping finish	
	WT5	Timber stud wall 100 x 50 w/ 13mm FC + 2mm glue + 3mm Micro topping finish	
Door Types			
	DO1	Flush Door 810mm x 2110mm	
	DO2	Toilet cubicle Door 650mm x 2110mm	
	DO3	Flush Double Doors 1510mm x 2110mm	
Abbreviations			
AP	Appliances	MA	Material
D	Door	PB	Plaster Board
DA	Development Application	SA	Sanitary
EQ	Equipment	SS	Stainless Steel
FU	Furniture	WT	Wall Type
		W/	With
Tag Legend			
MA01	Wall Paint White by Porters paints		
MA02	Wall Concrete by Hanson		
MA03	Wall Tiles by Beaumont tiles		
MA04	Wall Bricks by Austral bricks		
MA05	Bar Glass by Express Glass		
MA06	Bar Cement slab by Bunnings		
MA11	Stairs Steel by Pacific Metal work		
MA12	Bathroom Walls		
MA16	Wall Paint Grey by porters paints		
MA18	Glass by Express glass		
MA19	Female/Male Sign		
MA20	Concrete Slab Table		
MA21	Aluminum Seat Swing		
MA22	Steel Shipping Container		
MA23	Repair Stand		
MA24	Pot Plant		
MA25	Ceiling Plant by Porters Paints		
AP01	IMC Refrigeration Module B16704S		
AP02	IMC Glass Door Module B16700S		
AP05	IMC Wine Chiller Module B16703S		
AP08	Waldorf Pasta Cooker PC8140G		
AP09	Waldorf Kitchen Benchtops BT8600CB		
AP12	Waldorf 8820 series8 Burners Double Static Oven RN8820G		
AP13	Waldorf Refrigerator RN8100GRB		
AP16	Waldorf Charrigill CH8900G-LS		
AP18	Waldorf Gas fryer FN8120G		
EQ02	IMC Bar Ice Chest BZ54060		
EQ06	IMC Shelf Drainer BZ38100		
EQ08	IMC Perforated Worktop BZ69100		
EQ09	IMC Beer Station BZ34060		
EQ11	IMC Basket Rack BZ23050		
EQ13	IMC Double Sink BZ52100		
EQ14	IMC Worktop Unit BZ50060		
EQ18	IMC Storage Cupboard BZ61060		
EQ20	IMC Three Drawer Unit BZ64040		
EQ41	Waldorf BenchTop BT8450LS		
EQ42	Ryno 600Series Bench SB6150A		
EQ44	Street Furniture Bin 80LLB4		
EQ45	Street Furniture Semi Hoop Bike Stand		
BS103			
EQ56	IPS Paypoint Electronic Cash Register		
EQ57	CommBank TapPay Contactless Payment		
EQ50	LaMarzoccoc Coffee Machine FB80		
EQ61	Toyko Bike SS		
EQ62	Dog Bowl		
EQ63	Bike RepairStand		
EQ64	Mesh Gallery Partitions		
EQ65	Outdoor Swing Seating		
EQ67	Overhead Shelving Bar		
EQ68	Retail Bar Table		
FU10	Tait Linear Table & Benches		
FU16	Style craft Spike Low Stool H450mm		
FU11	Arper Dizzie Side Table Black		
FU12	Take Away Counter		
SA01	Dyson Hand Dryer Unit BZ50		
SA03	Contura Recessed Soap Dispenser		
SA05	RBA Jumbo Toilet Dispenser B2890		
SA08	RBA Sanitary Mounted Napkin Disposal		
B270			
SA11	RBA Full Height Basin RBA8881-100		
SA12	Plumbing Fixtures Urinal		
SA13	Toilet Plumbing Fixtures WC		
SA14	Toilet Handicaped Grab Bars		

Revisions			Do not scale drawings. Use figured dimensions only. Check and verify levels and dimensions on site prior to commencement of any work, the preparation of drawings or the fabrication of components. This drawing is copyright and can not be reproduced without written consent.	Client Sue & Andy Baker Le Velo	True North 	Billy Blue College of Design 46-52 Mountain Street, Ultimo, NSW 2007, Australia +61 (0)2 9999 9999 	Project IDC302A 48 Baywater Drive, Wentworth Point, NSW, 2127 Project number 20,001	Drawing Title Cover Page Drawing Status PRESENTATION DRAWINGS NOT FOR CONSTRUCTION	Scale	Drawing No	Issue
No	Date	Description							N/A	A00	01
01	21.08.21	PRESENTATION DRAWINGS							Date	21.08.21	
									Drawn by	MB	

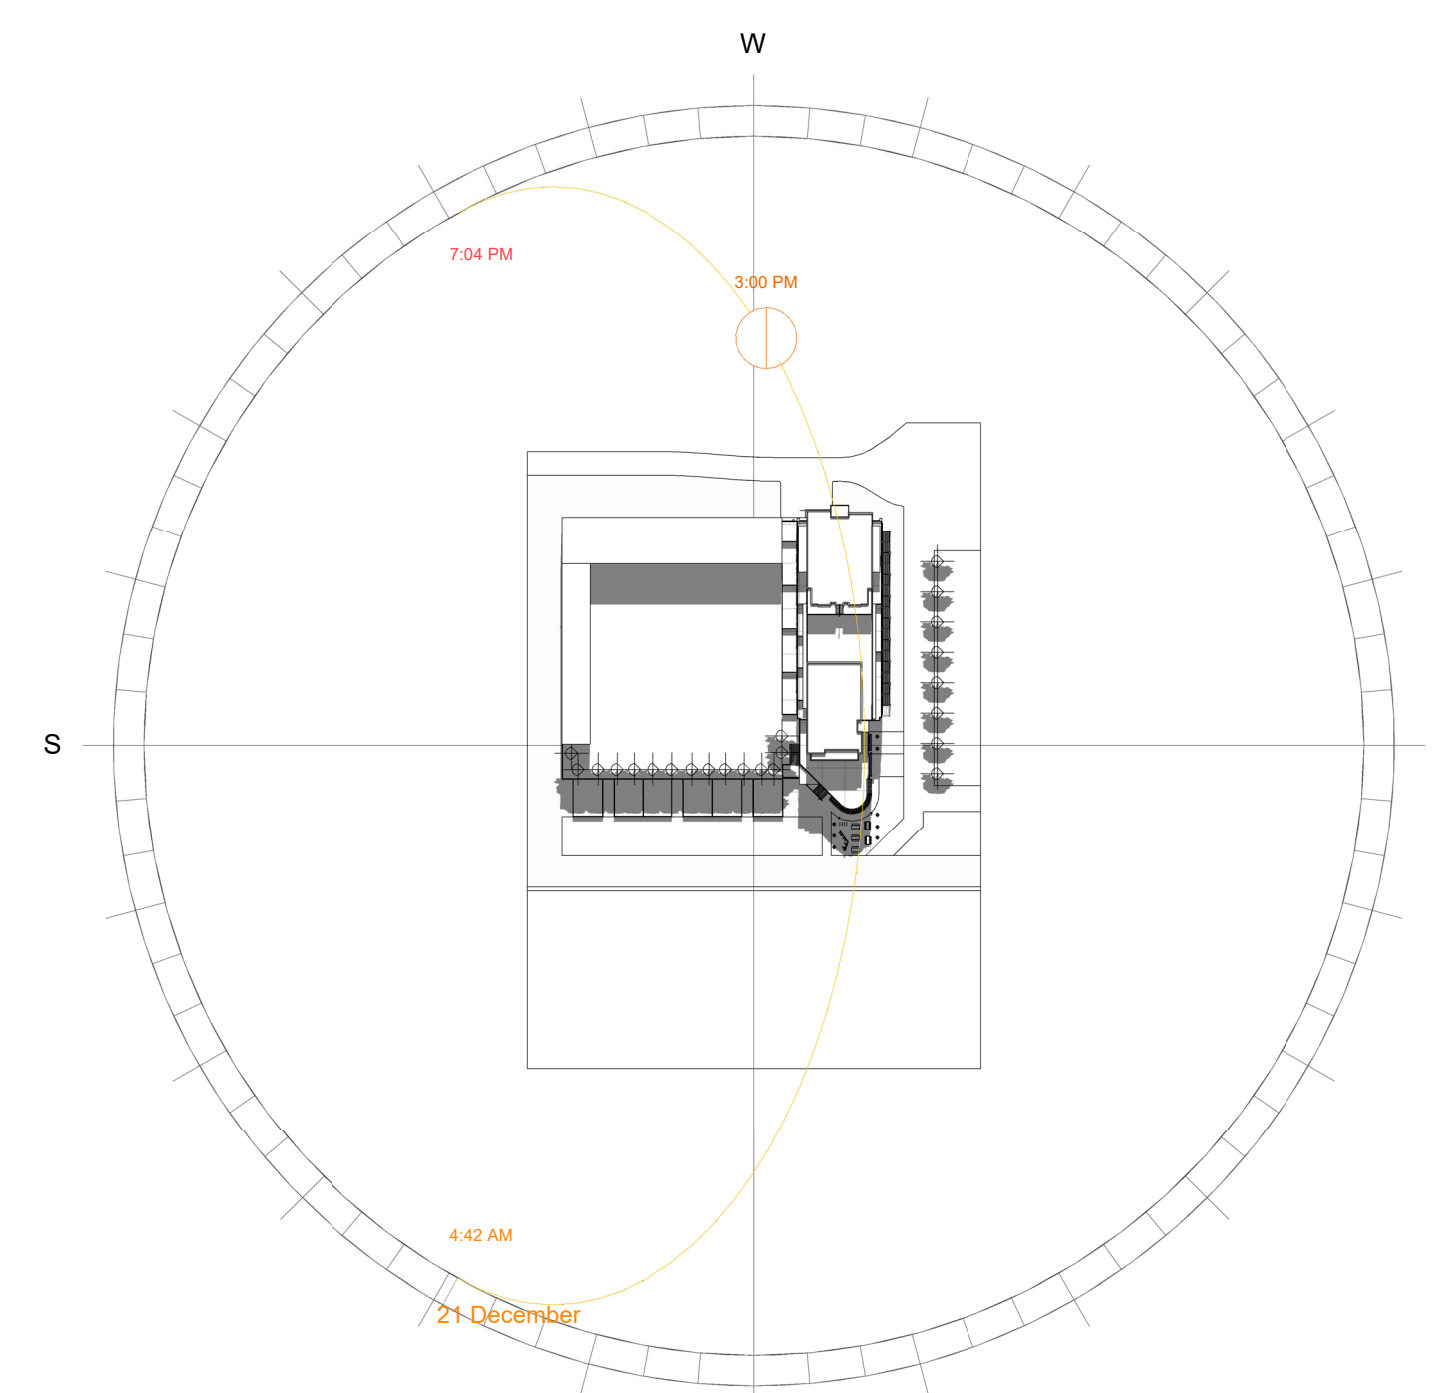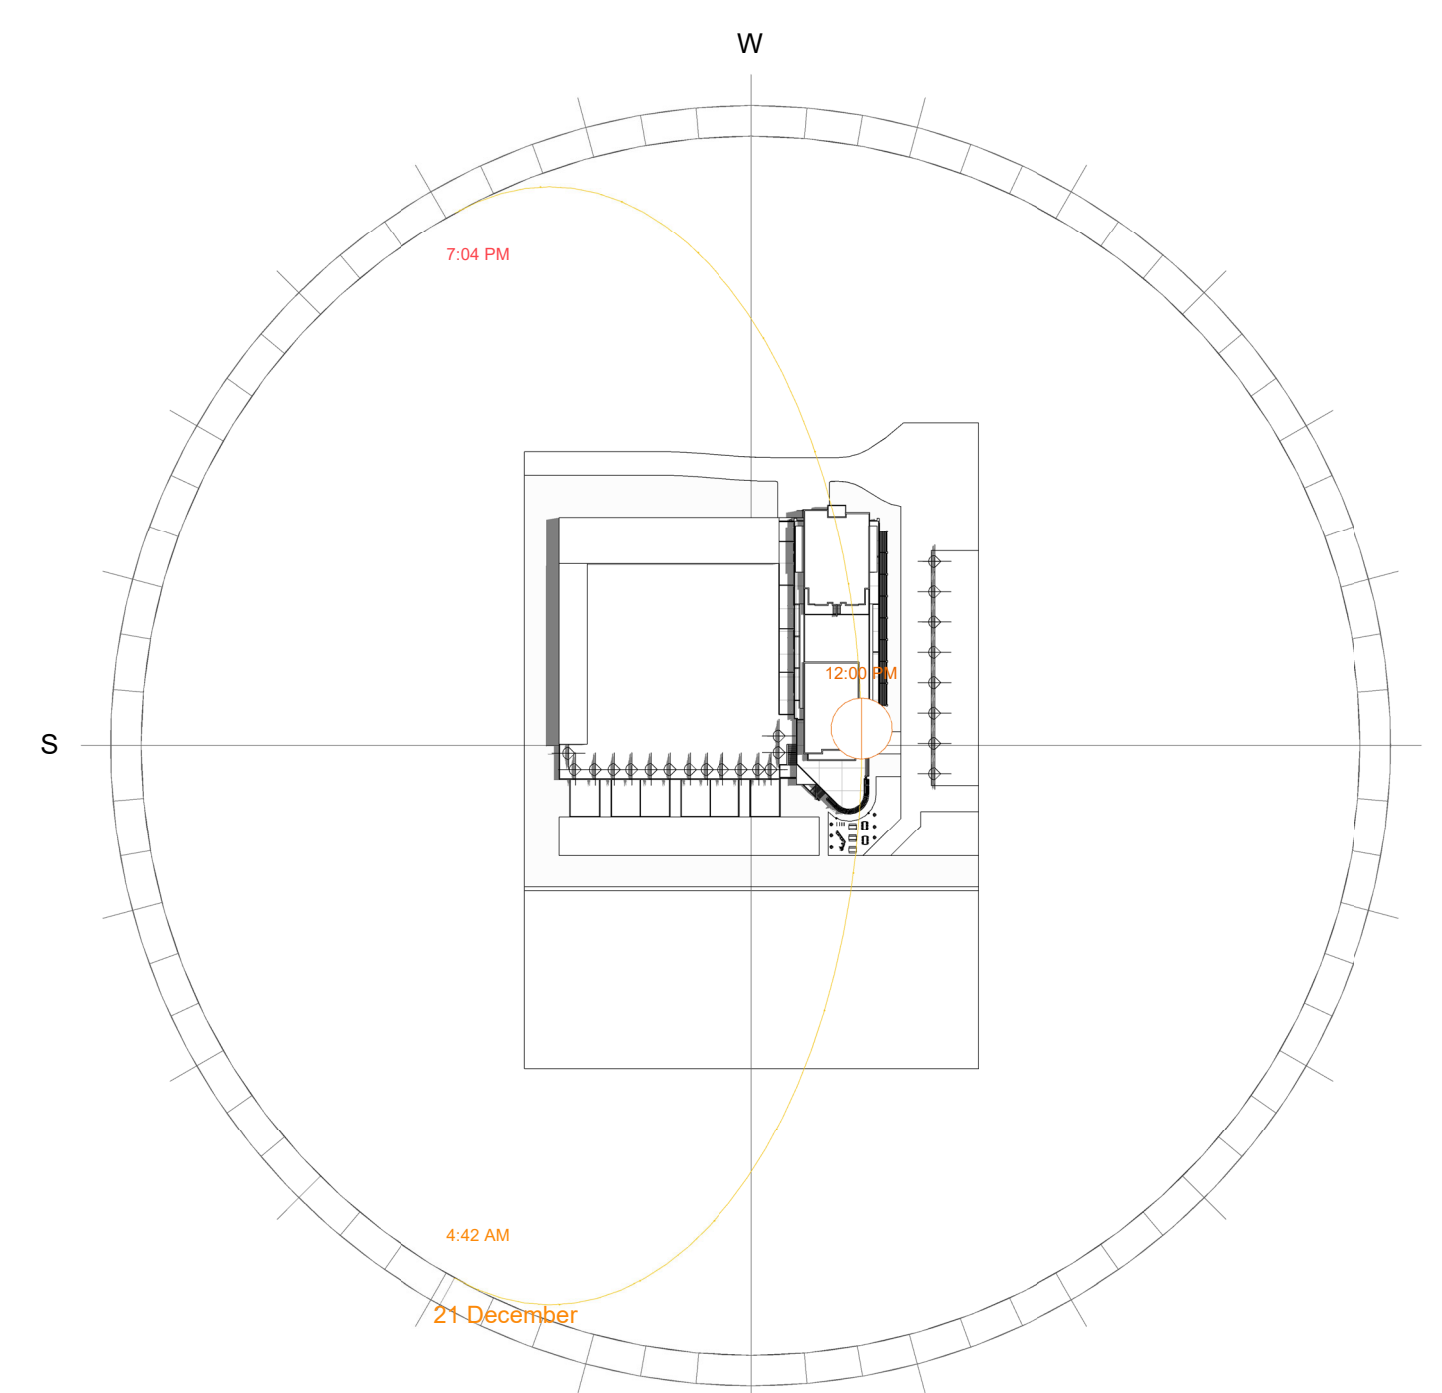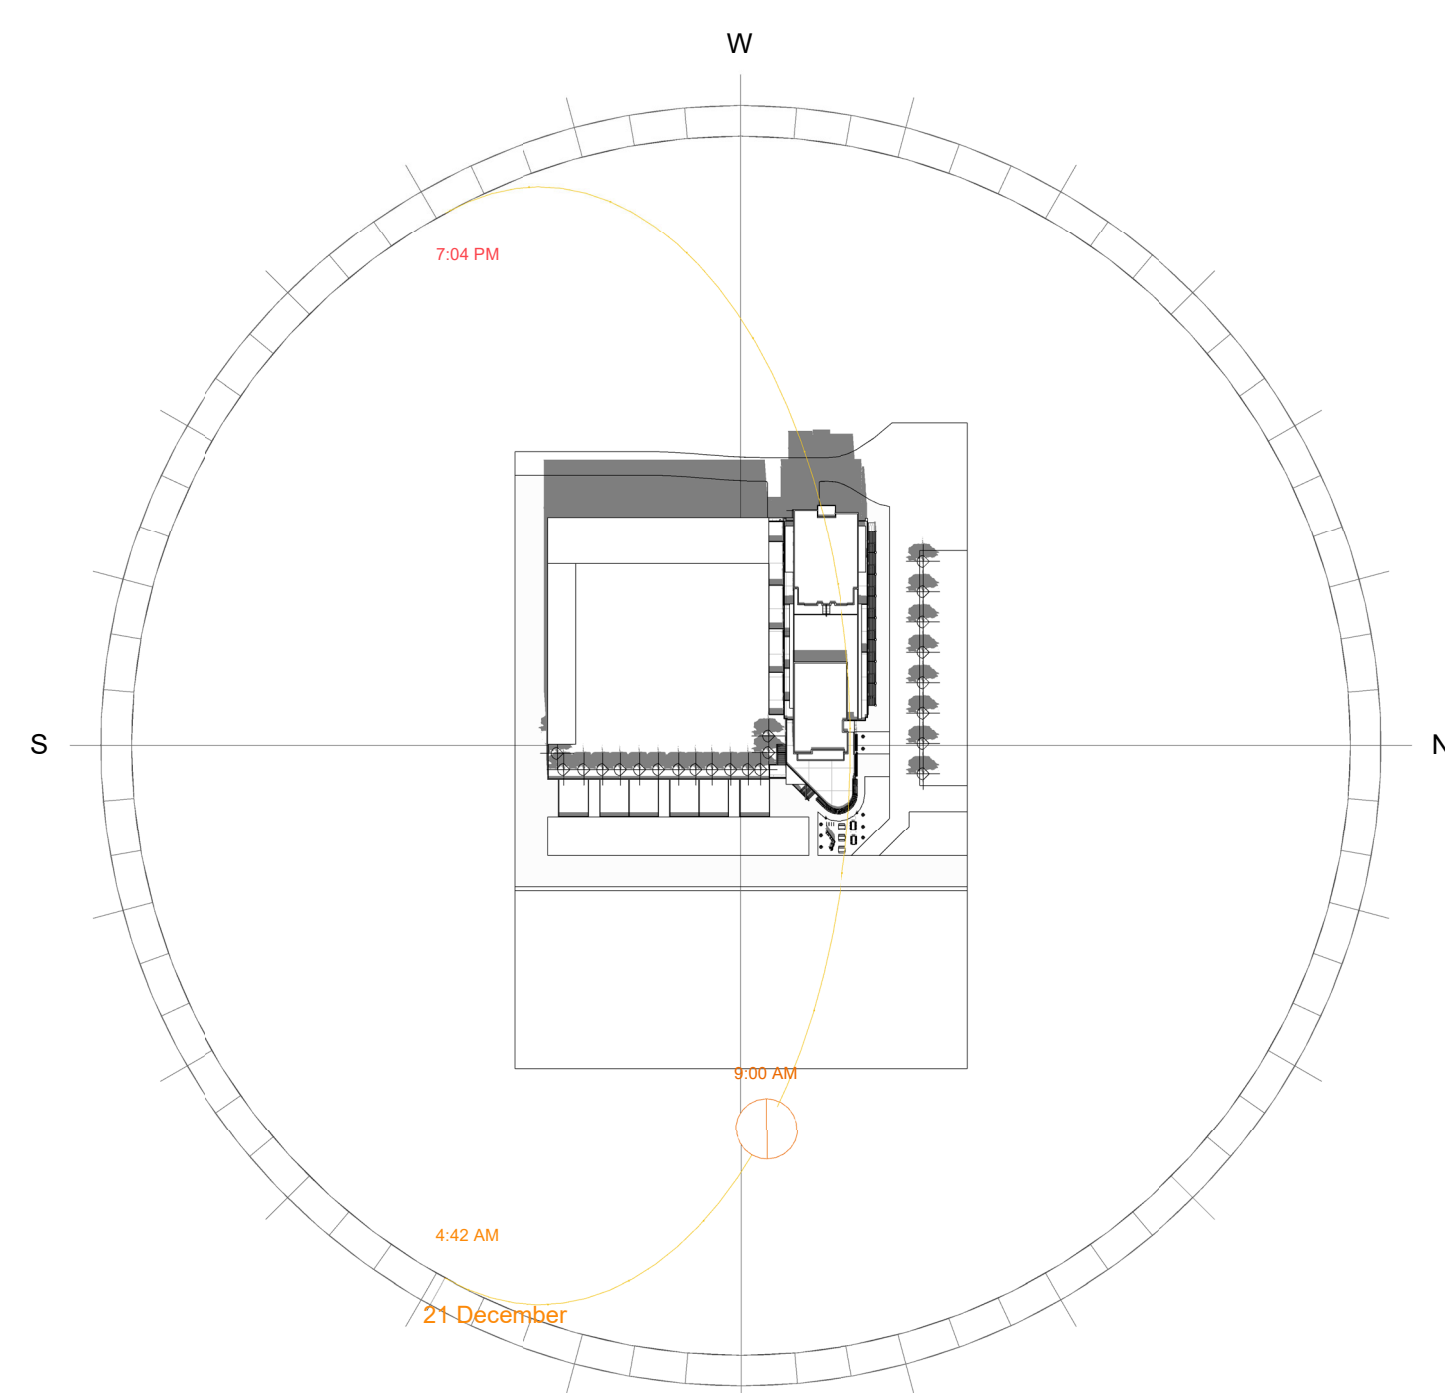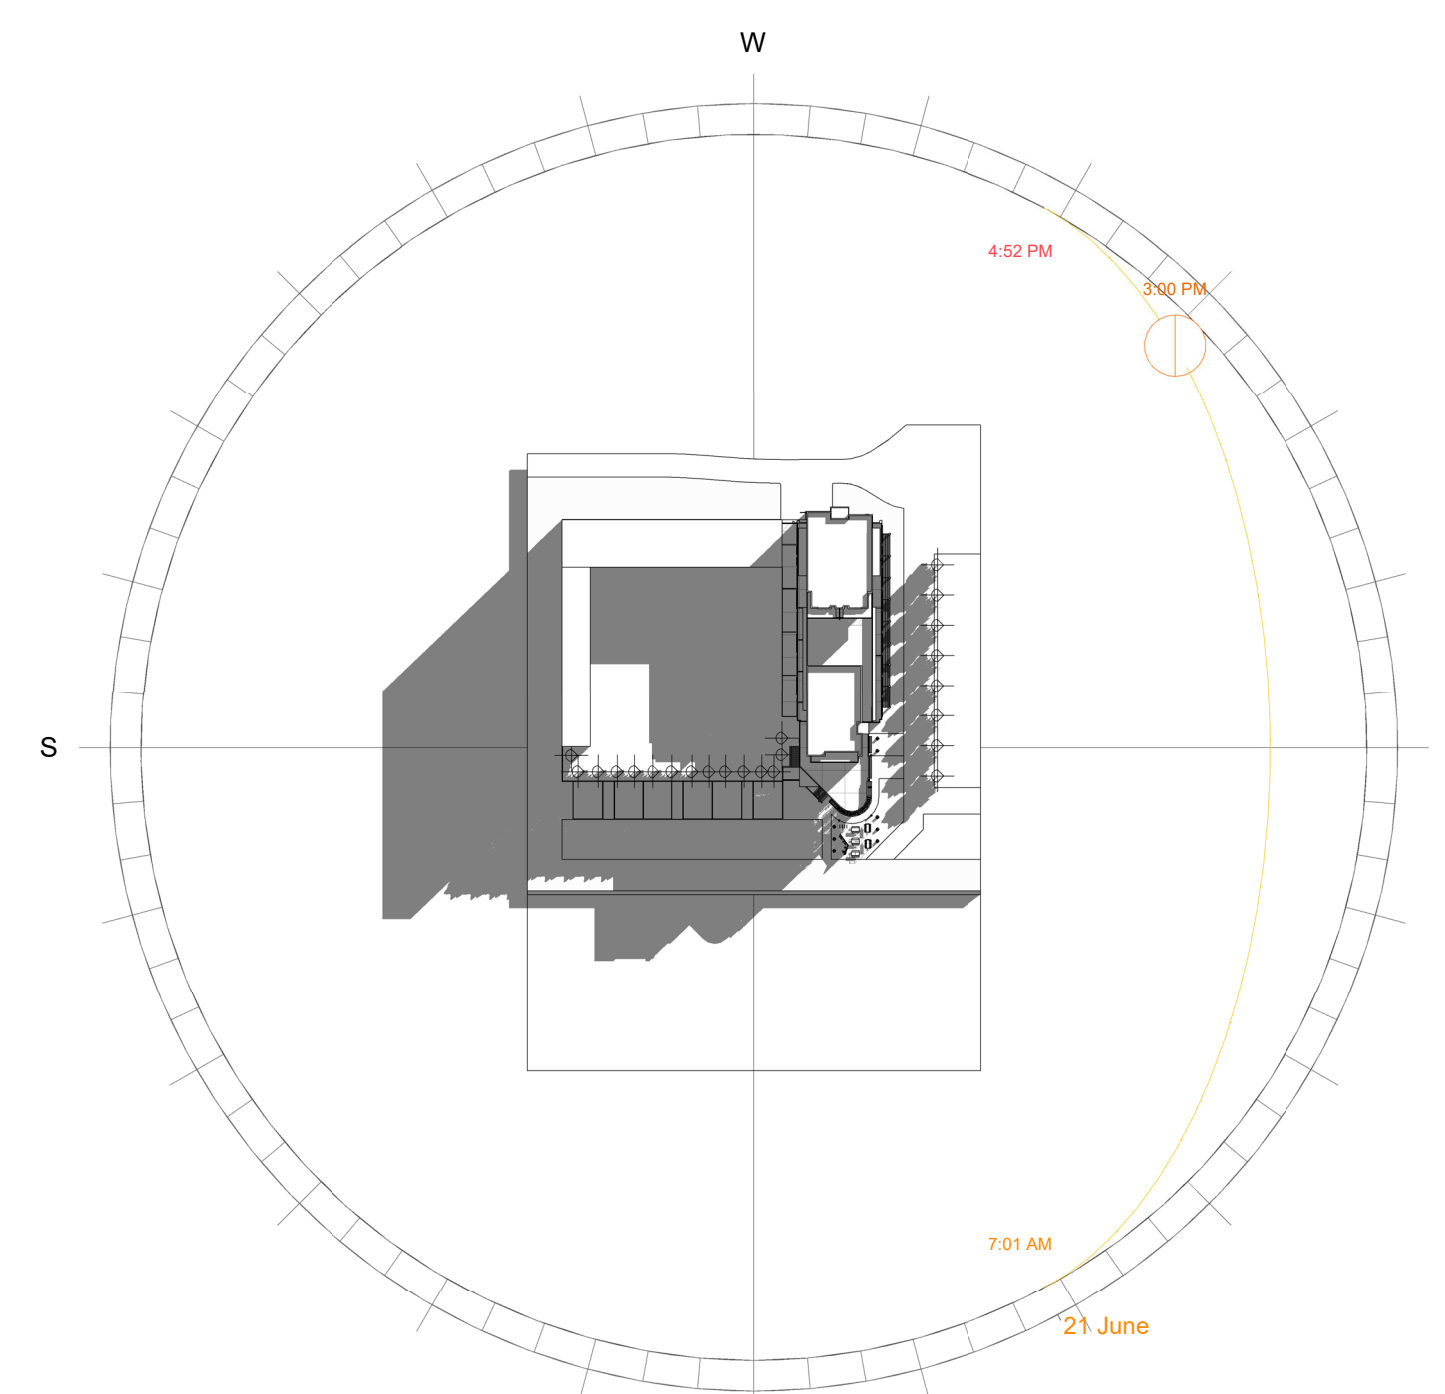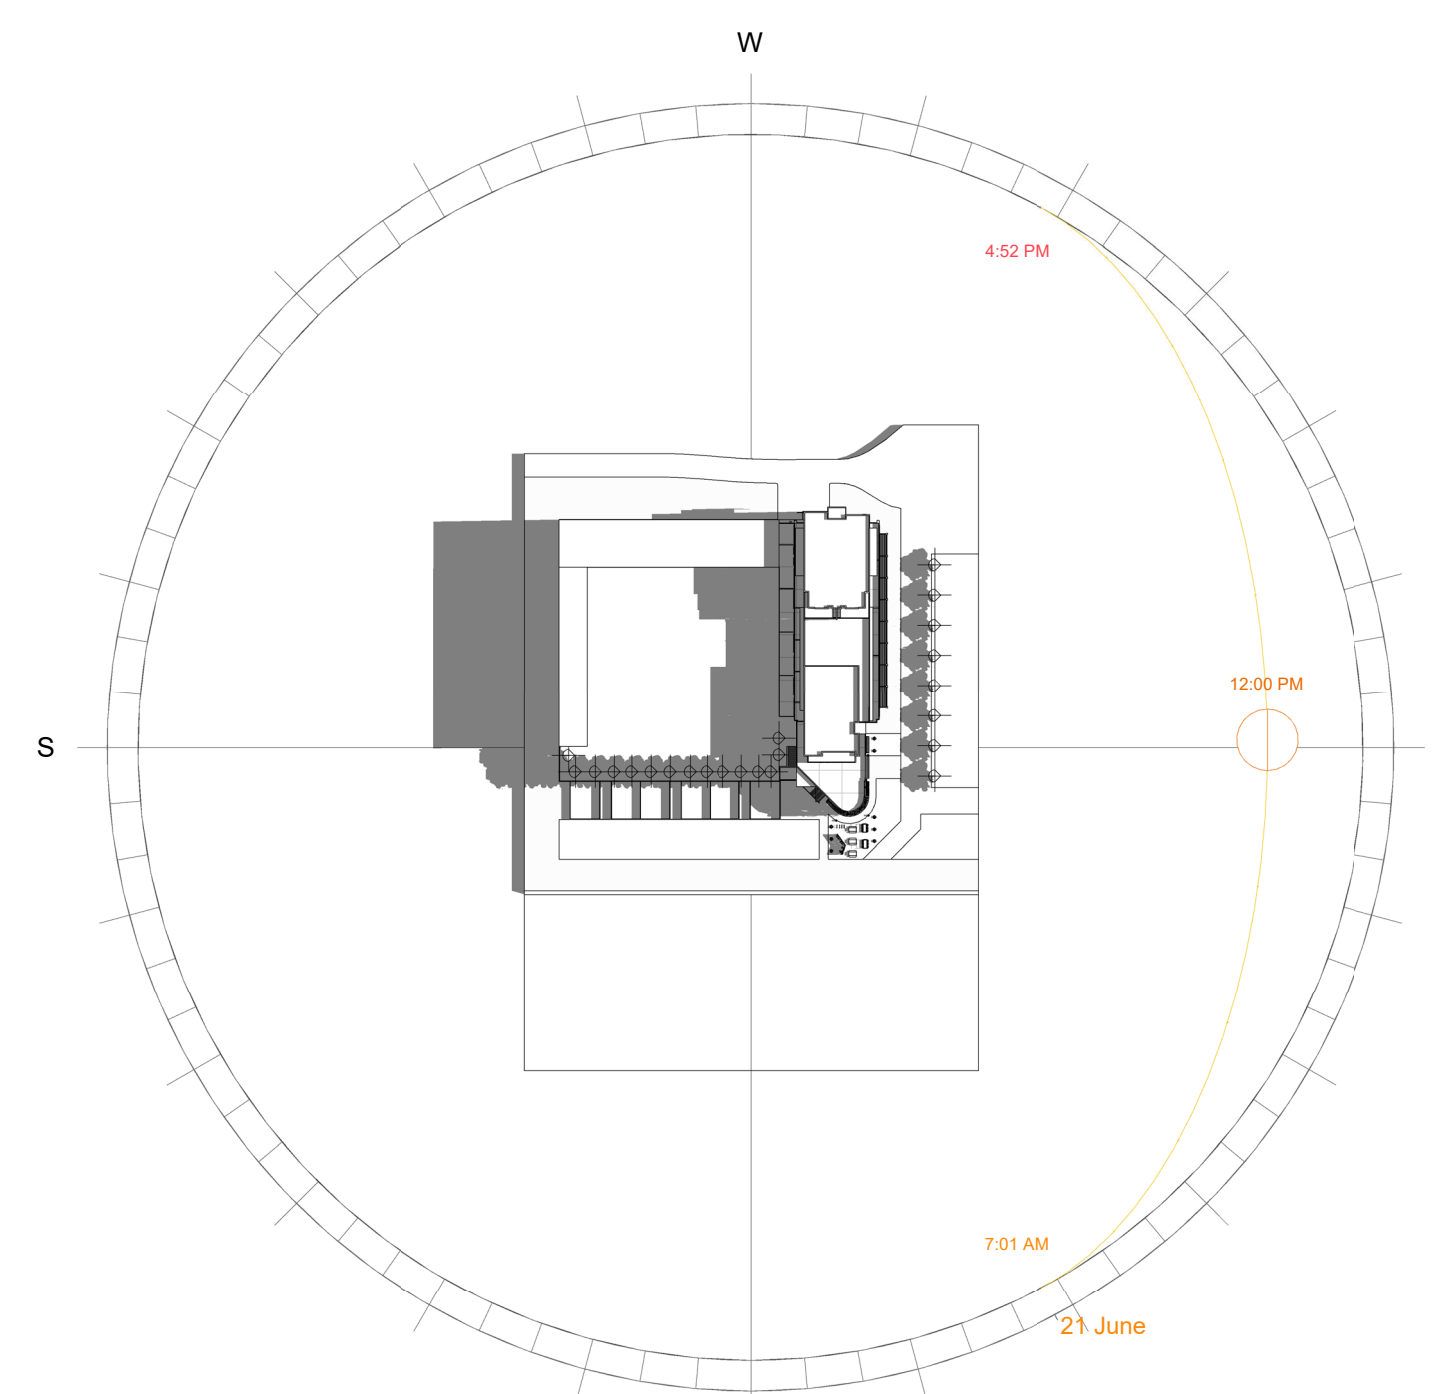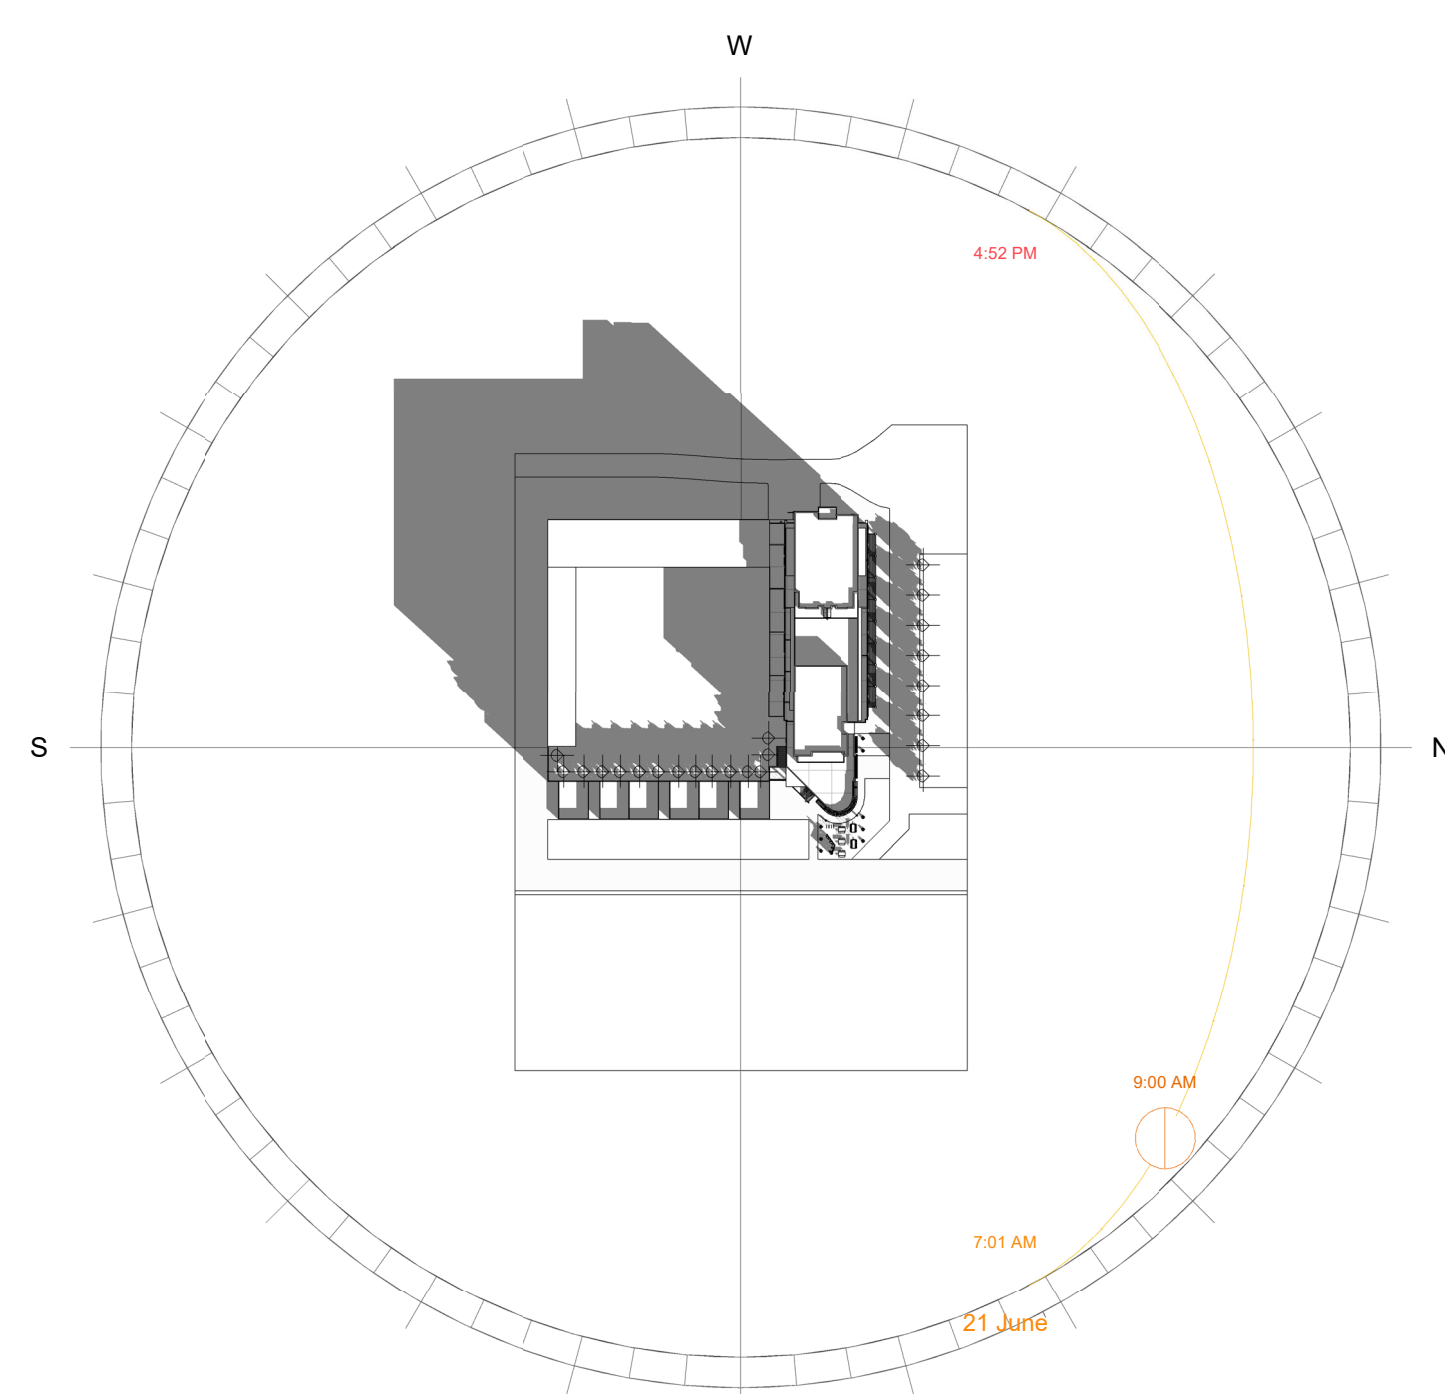



LEGEND

Cut Material

Existing Structure

Plaster Board

Tiles

Concrete

Steel

Glass

Wall Types

WT1

2mm glue + 70mm Recycled Brick

WT2

2mm glue + 70mm Recycled Brick + 2mm Artwork finish

WT3

Timber stud wall 100 x 50 w/ 13mm FC + 2mm glue
3mm Micro topping finish to each side

WT4

13mm FC + 2mm glue + 3mm Micro topping finish

WT5

Timber stud wall 100 x 50 w/ 13mm FC + 2mm glue + 3mm Micro topping finish

Door Types

DO1

Flush Door 810mm x 2110mm

DO2

Toilet cubicle Door 650mm x 2110mm

DO3

Flush Double Doors 1510mm x 2110mm

Abbreviations

AP

Appliances

DP

Door

DA

Development Application

EQ

Equipment

FU

Furniture

MA

PB

SA

SS

WT

W/

Material

Plaster Board

Sanitary

Stainless Steel

Wall Type

With

Tag Legend

MA01

Wall Paint White by Porters paints

MA02

Wall Concrete by Hanson

MA03

Wall Tiles by Beaumont tiles

MA04

Wall Bricks by Austral bricks

MA05

Bar Glass by Express Glass

MA06

Bar Cement slab by Bunnings

MA11

Stairs Steel by Pacific Metal work

MA12

Bathroom Walls

MA16

Wall Paint Grey by porters paints

MA18

Glass by Express glass

MA19

Female/Male Sign

MA20

Concrete Slab Table

MA21

Aluminum Seat Swing

MA22

Steel Shipping Container

MA23

Repair Stand

MA24

Pot Plant

MA25

Ceiling Plant by Porters Paints

AP01

IMC Refrigeration Module B16704S

AP02

IMC Glass Door Module B16700S

AP05

IMC Wine Chiller Module B16703S

AP08

Waldorf Pasta Cooke PC8140G

AP09

Waldorf Kitchen Benchtops BT8600CB

AP12

Waldorf 8820 series8 Burners Double Static Oven RN8820G

AP13

Waldorf Refridgrator RN8100GRB

AP14

Waldorf Gas Stove CH900G-LS

AP18

Waldorf Gas Fryer FN1820G

EQ02

IMC Bar Ice Chest BZ5406G

EQ06

IMC Shelf Drainer BZ38100

EQ08

IMC Perforated Worktop BZ69100

EQ09

IMC Beer Station BZ3406G

EQ11

IMC Basket Rack BZ23050

EQ13

IMC Double Sink BZ52100G

EQ14

IMC Worktop Unit BZ5008G

EQ18

IMC Storage Cupboard BZ6106G

EQ20

IMC Three Drawer Unit BZ6404G

EQ41

Waldorf Benchtop BT8450LS

EQ42

Rymo 600Series Bench SB6150A

EQ44

Street Furniture Bin 80LLB4

EQ45

Street Furniture Semi Hoop Bike Stand B5T03

EQ50

IPS Paypoint Electronic Cash Register

EQ57

CommBank TapPay Contactless Payment

EQ50

LaMarzocco Coffee Machine FB80

EQ61

Toyko Bike SS

EQ62

Dog Bowl

EQ63

Bike Repair Stand

EQ64

Mesh Gallery Partitions

EQ65

Outdoor Seating Sealing

EQ67

Overhead Shelving Bar

EQ68

Retail Bar Table

FU10

Table Linear Table & Benches

FU16

Style Craft Spike Low Stool H450mm

FU11

Arper Dizzie Side Table Black

FU12

Take Away Counter

SA01

Dyson Hand Dryer Unit BZ50

SA02

Centura Recessed Soap Dispenser

SA05

RBA Jumbo Toilet Dispenser B2890

SA06

RBA Sanitary Mounted Napkin Disposal B270

SA11

RBA Full Height Basin RBA8881-100

SA12


Plumbing Fixtures Urinal


SA13

Toilet Plumbing Fixtures WC

SA14

 Toilet Handicapped Grab Bars

Revisions			Do not scale drawings. Use figured dimensions only. Check and verify levels and dimensions on site prior to commencement of any work, the preparation of drawings or the fabrication of components. This drawing is copyright and can not be reproduced without written consent.	Client Sue & Andy Baker	True North 	Billy Blue College of Design 46-52 Mountain Street, Ultimo, NSW 2007, Australia +61 (0)2 9999 9999  TORRENS UNIVERSITY AUSTRALIA 	Project IDC302A 48 Baywater Drive, Wentworth Point, NSW, 2127 Project number 20,001	Drawing Title Level 1 Plan Drawing Status PRESENTATION DRAWINGS NOT FOR CONSTRUCTION	Scale	Drawing No	Issue	
No	Date	Description							Ver. App'd	1:100	A02	01
01	21.08.21	PRESENTATION DRAWINGS							XX App'd	Date	21.08.21	Drawn by MB

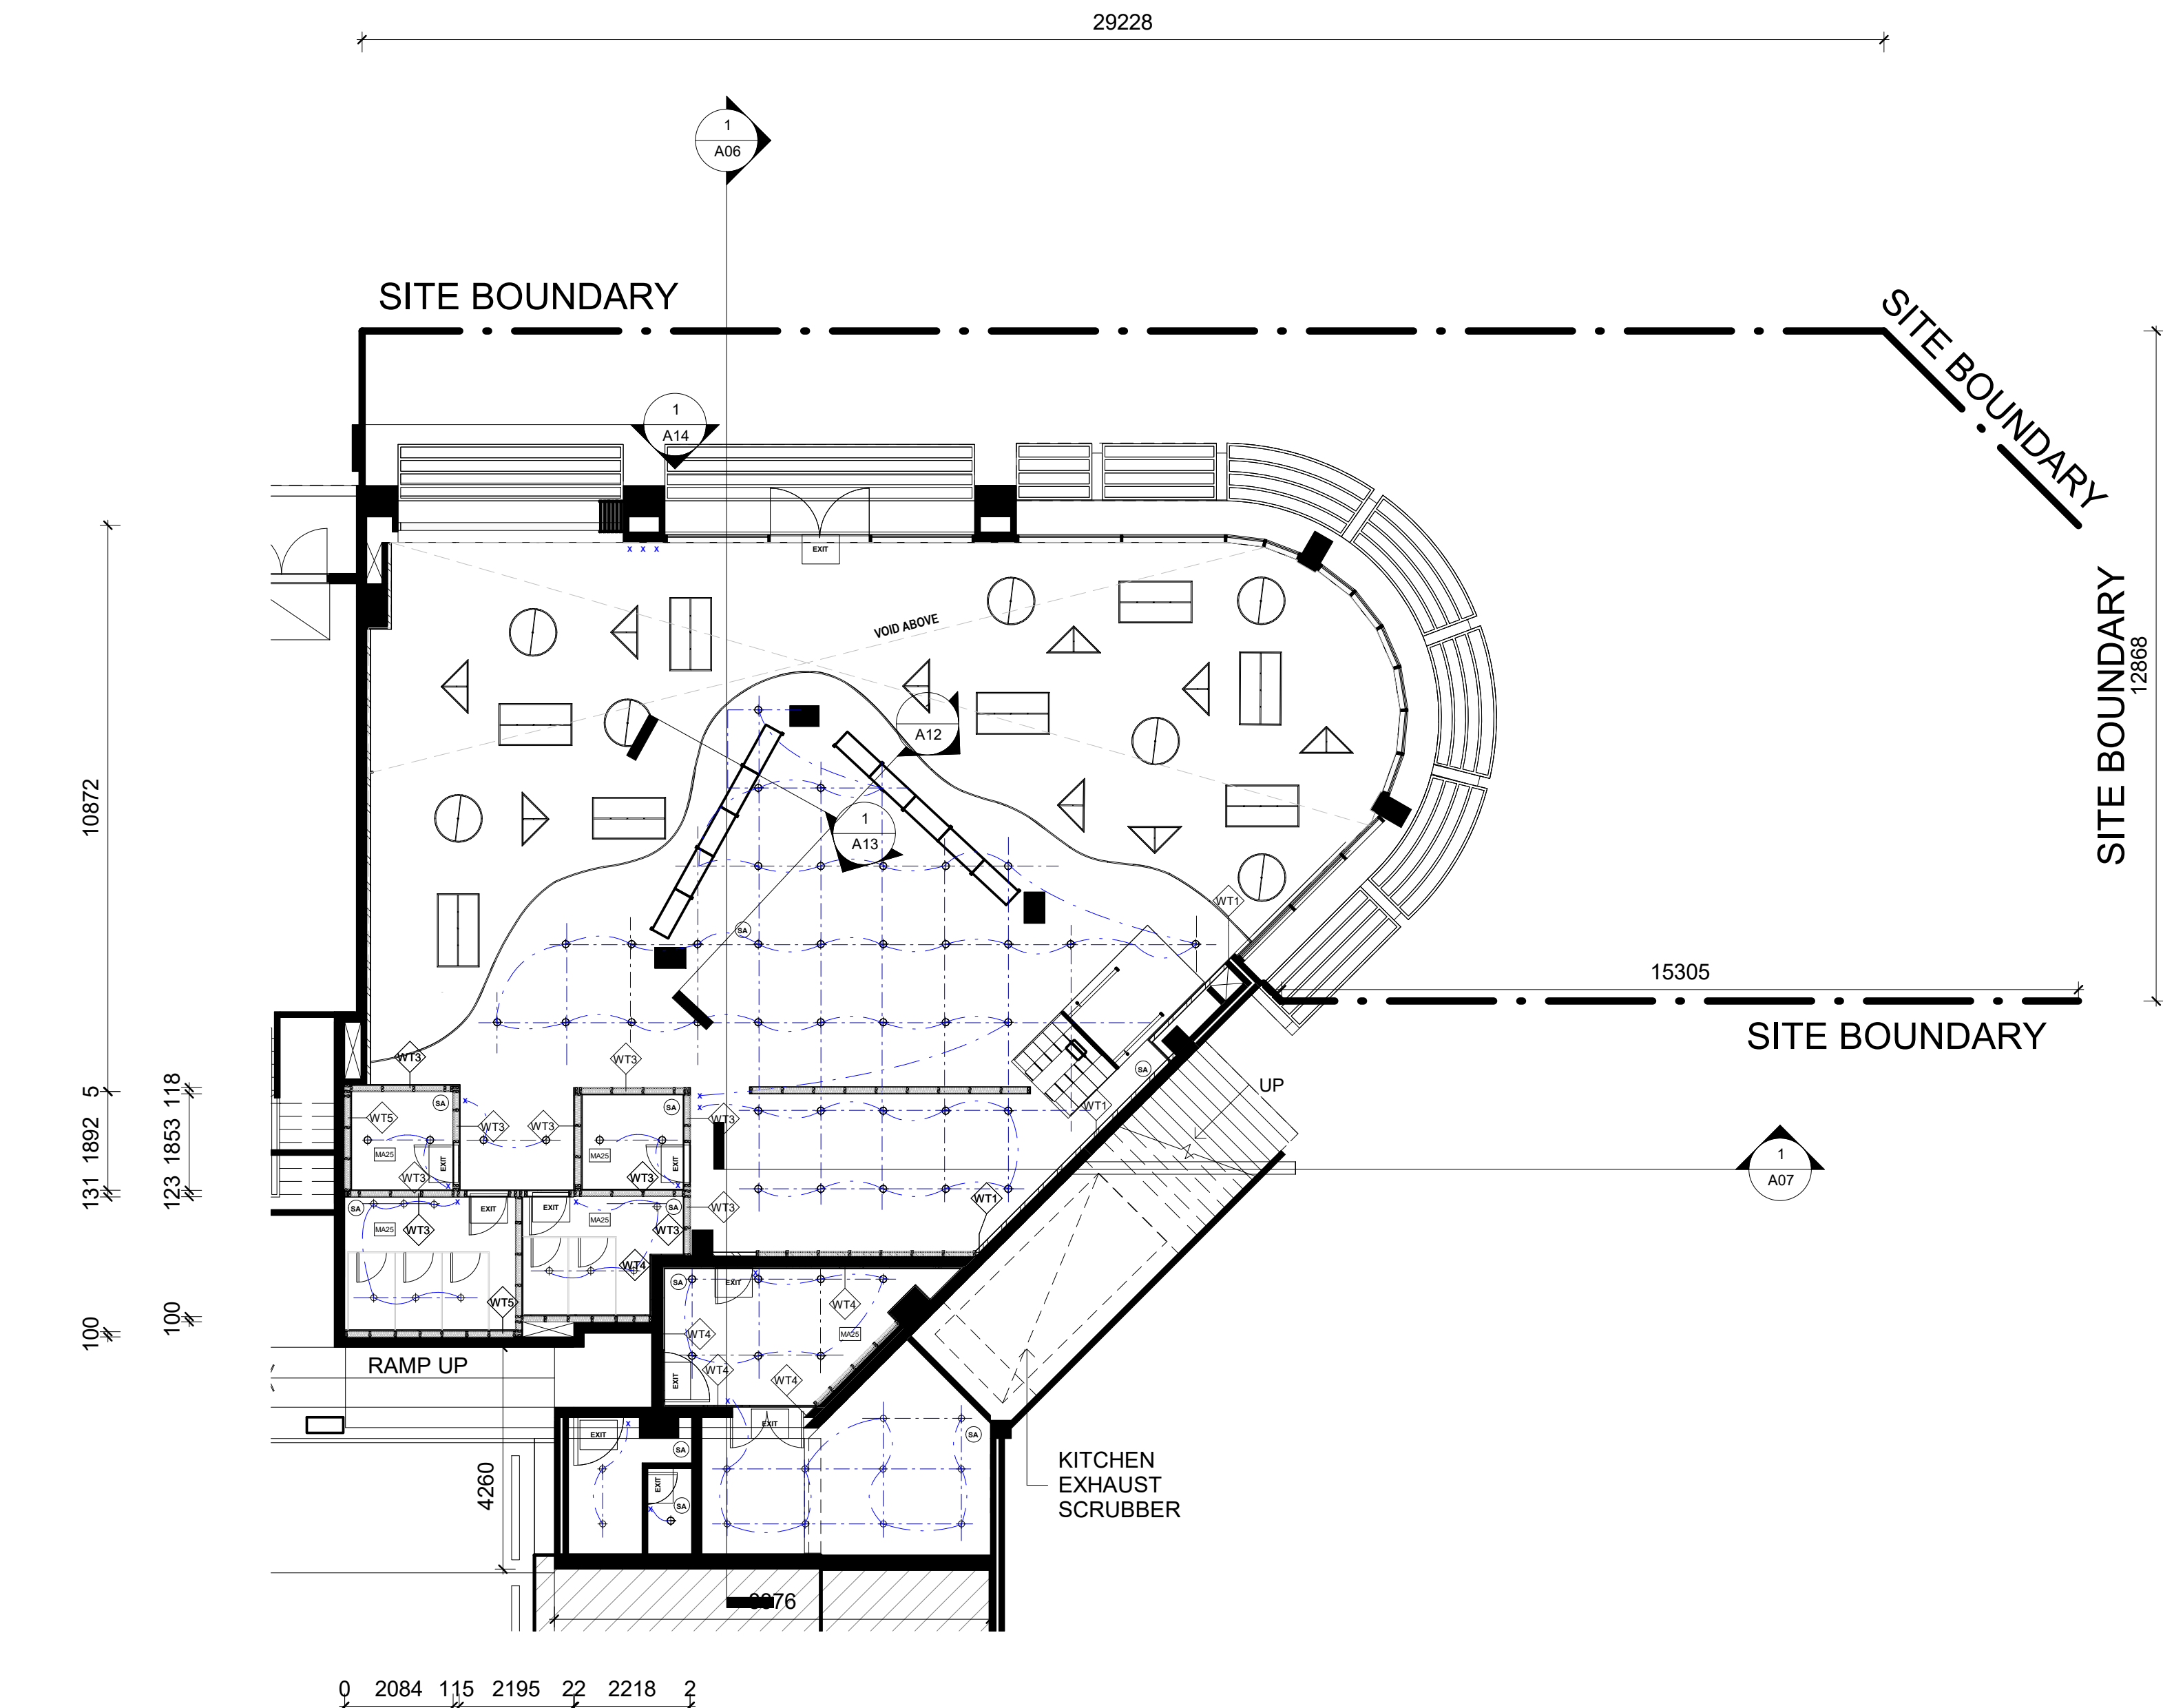

1 Level 1 RCP
1 : 100

RCP Legend	
	Lighting Fixture Grid
	Lighting Fixture Wire
	Lighting Power Switch
	Smoke Alarm
	Exit Signs
	Lighting fixtures

LEGEND

Cut Material

	Existing Structure		Concrete
	Plaster Board		Steel
	Tiles		Glass

Wall Types

	WT1	2mm glue + 70mm Recycled Brick
	WT2	2mm glue + 70mm Recycled Brick + 2mm Artwork finish
	WT3	Timber stud wall 100 x 50 w/ 13mm FC + 2mm glue + 3mm Micro topping finish to each side
	WT4	13mm FC + 2mm glue + 3mm Micro topping finish
	WT5	Timber stud wall 100 x 50 w/ 13mm FC + 2mm glue + 3mm Micro topping finish

Door Types

	DO1	Flush Door 810mm x 2110mm
	DO2	Toilet cubicle Door 650mm x 2110mm
	DO3	Flush Double Doors 1510mm x 2110mm

Abbreviations

AP	Appliances	MA	Material
D	Door	PB	Plaster Board
DA	Development Application	SA	Sanitary
EQ	Equipment	SS	Stainless Steel
FU	Furniture	WT	Wall Type
		W/	With

Tag Legend

MA01	Wall Paint White by Porters paints
MA02	Wall Concrete by Hanson
MA03	Wall Tiles by Beaumont tiles
MA04	Wall Bricks by Austral bricks
MA05	Bar Glass by Express Glass
MA06	Bar Cement slab by Bunnings
MA11	Stairs Steel by Pacific Metal work
MA12	Bathroom Walls
MA16	Wall Paint Grey by porters paints
MA18	Glass by Express glass
MA19	Female/Male Sign
MA20	Concrete Slab Table
MA21	Aluminum Seat Swing
MA22	Steel Shipping Container
MA23	Repair Stand
MA24	Pot Plant
MA25	Ceiling Plant by Porters Paints
AP01	IMC Refrigeration Module B16704S
AP02	IMC Glass Door Module B16700S
AP05	IMC Wine Chiller Module B16703S
AP08	Waldorf Pasta Cooker PC8140G
AP09	Waldorf Kitchen Benchtops BT8600CB
AP12	Waldorf 8820 series8 Burners Double Static Oven RN8820G
AP13	Waldorf Refridgerator RN8100GRB
AP16	Waldorf Chargrill CH8900G-LS
AP18	Waldorf Gas fryer FN8120G
EQ02	IMC Bar Ice Chest BZ54060
EQ06	IMC Shelf Drainer BZ38100
EQ08	IMC Perforated Worktop BZ69100
EQ09	IMC Beer Station BZ34060
EQ11	IMC Basket Rack BZ23050
EQ13	IMC Double Sink BZ52100
EQ14	IMC Worktop Unit BZ50060
EQ18	IMC Storage Cupboard BZ61060
EQ20	IMC Three Drawer Unit BZ64040
EQ41	Waldorf BenchTop BT8450LS
EQ42	Ryno 600Series Bench SB6150A
EQ44	Street Furniture Bin 80LLE4
EQ45	Street Furniture Semi Hoop Bike Stand
BST03	
EQ56	IPS Paypoint Electronic Cash Register
EQ57	CommBank TapPay Contacless Payment
EQ50	LaMarzocco Coffee Machine FB80
EQ61	Toyko Bike SS
EQ62	Dog Bowl
EQ63	Bike RepairStand
EQ64	Mesh Gallery Partitions
EQ65	Outdoor Swing Seating
EQ67	Overhead Shelving Bar
EQ68	Retail Bar Table
FU10	Tait Linear Table & Benches
FU16	Style craft Spike Low Stool H450mm
FU11	Arper Dizzie Side Table Black
FU12	Take Away Counter
SA01	Dyson Hand Dryer Unit BZ50
SA03	Contura Recessed Soap Dispenser
SA05	RBA Jumbo Toilet Dispenser BZ890
SA06	RBA Sanitary Mounted Napkin Disposal
BZ70	
SA11	RBA Full Height Basin RBA8881-100
SA12	Plumbing Fixtures Urinal
SA13	Toilet Plumbing Fixtures WC
SA14	Toilet Handicaped Grab Bars

Revisions		
No	Date	Description
01	21.08.21	PRESENTATION DRAWINGS

Ver.	App'd
	Approver

Do not scale drawings. Use figured dimensions only. Check and verify levels and dimensions on site prior to commencement of any work, the preparation of drawings or the fabrication of components.
This drawing is copyright and can not be reproduced without written consent.

Client
Sue & Andy Baker

Le Velo

True North



Billy Blue College of Design
46-52 Mountain Street, Ultimo, NSW 2007, Australia
+61 (0)2 9999 9999



Project

IDC302A

48 Baywater Drive, Wentworth Point, NSW, 2127

Project number
20,001

Drawing Title

Level 1 RCP

Drawing Status

PRESENTATION DRAWINGS
NOT FOR CONSTRUCTION

Scale

Drawing No
A03

Issue
01

Date

21.08.21

Drawn by

Author

LEGEND


Cut Material			
	Existing Structure		Concrete
	Plaster Board		Steel
	Tiles		Glass

Wall Types	
	2mm glue + 70mm Recycled Brick
	2mm glue + 70mm Recycled Brick + 2mm Artwork finish
	Timber stud wall 100 x 50 w/ 13mm FC + 2mm glue + 3mm Micro topping finish to each side
	13mm FC + 2mm glue + 3mm Micro topping finish
	Timber stud wall 100 x 50 w/ 13mm FC + 2mm glue + 3mm Micro topping finish

Door Types	
	Flush Door 810mm x 2110mm
	Toilet cubicle Door 650mm x 2110mm
	Flush Double Doors 1510mm x 2110mm

Abbreviations			
AP	Appliances	MA	Material
D	Door	PB	Plaster Board
DA	Development Application	SA	Sanitary
EQ	Equipment	SS	Stainless Steel
FU	Furniture	WT	Wall Type
		W/	With

Tag Legend	
MA01	Wall Paint White by Porters paints
MA02	Wall Concrete by Hansons
MA03	Wall Tiles by Beaumont tiles
MA04	Wall Bricks by Austral bricks
MA05	Bar Glass by Express Glass
MA06	Bar Cement slab by Bunnings
MA11	Stairs Steel by Pacific Metal work
MA12	Bathroom Walls
MA16	Wall Paint Grey by porters paints
MA18	Glass by Express glass
MA19	Female/Male Sign
MA20	Concrete Slab Table
MA21	Aluminum Seat Swing
MA22	Steel Shipping Container
MA23	Repair Stand
MA24	Pot Plant
MA25	Ceiling Plant by Porters Paints
AP01	IMC Refrigeration Module B16704S
AP02	IMC Glass Door Module B16700S
AP05	IMC Wine Chiller Module B16703S
AP08	Waldorf Pasta Cooker PC8140G
AP09	Waldorf Kitchen Benchtops BT8600CB
AP12	Waldorf 8820 series8 Burners Double Static Oven RN8820G
AP13	Waldorf Refridgerator RN8100GRB
AP16	Waldorf Chagrill CH8900G-LS
AP18	Waldorf Gas fryer FN8120G
EQ02	IMC Bar Ice Chest BZ54060
EQ06	IMC Shelf Drainer BZ38100
EQ08	IMC Perforated Worktop BZ69100
EQ09	IMC Beer Station BZ34060
EQ11	IMC Basket Rack BZ23050
EQ13	IMC Double Sink BZ52100
EQ14	IMC Worktop Unit BZ50060
EQ18	IMC Storage Cupboard BZ61060
EQ20	IMC Three Drawer Unit BZ64040
EQ41	Waldorf BenchTop BT8450LS
EQ42	Ryno 600Series Bench SB6150A
EQ44	Street Furniture Bin 80LLB4
EQ45	Street Furniture Semi Hoop Bike Stand
BST03	
EQ56	IPS Paypoint Electronic Cash Register
EQ57	CommBank TapPay Contactless Payment
EQ50	LaMarzoccoc Coffee Machine FB80
EQ61	Toyko Bike SS
EQ62	Dog Bowl
EQ63	Bike RepairStand
EQ64	Mesh Gallery Partitions
EQ65	Outdoor Swing Seating
EQ67	Overhead Shelving Bar
EQ68	Retail Bar Table
FU10	Tait Linear Table & Benches
FU16	Style craft Spike Low Stool H450mm
FU11	Arper Dizzie Side Table Black
FU12	Take Away Counter
SA01	Dyson Hand Dryer Unit BZ50
SA03	Contura Recessed Soap Dispenser
SA05	RBA Jumbo Toilet Dispenser B2890
SA06	RBA Sanitary Mounted Napkin Disposal
BZ70	
SA11	RBA Full Height Basin RBA8881-100
SA12	Plumbing Fixtures Urinal
SA13	Toilet Plumbing Fixtures WC
SA14	Toilet Handicaped Grab Bars

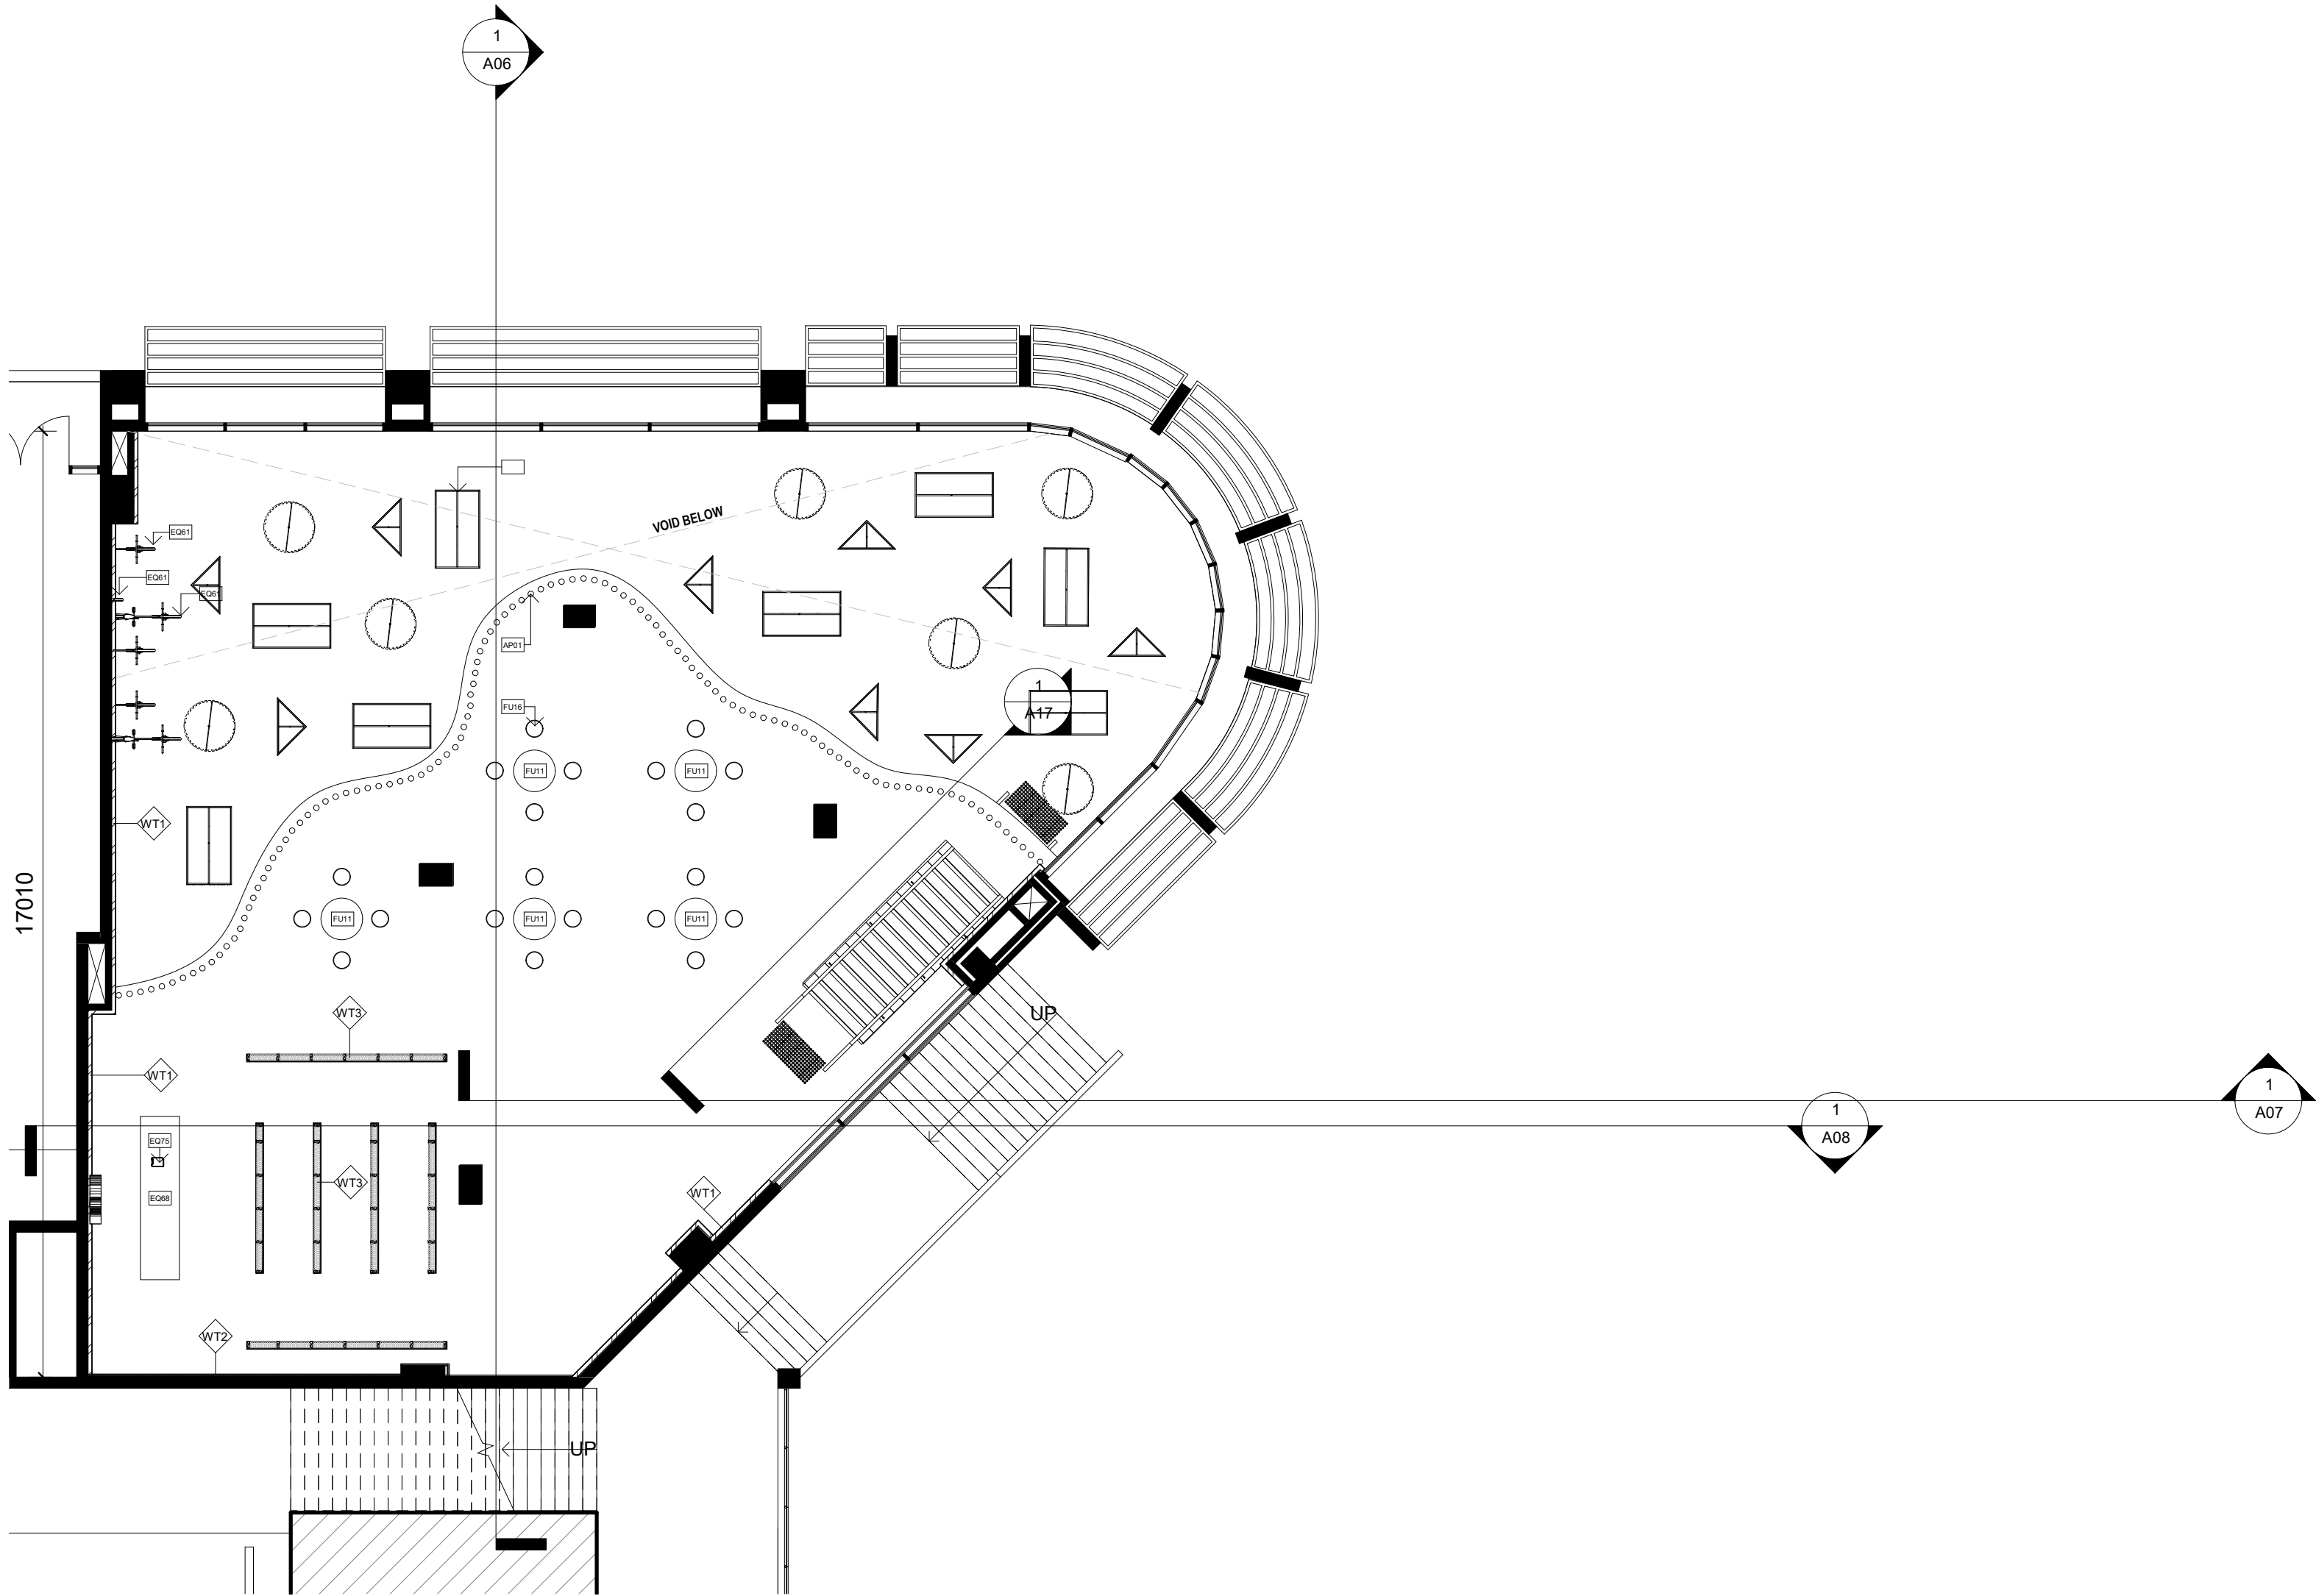

1 Level 2
1 : 100

Revisions		
No	Date	Description
01	21.08.21	PRESENTATION DRAWINGS

Do not scale drawings. Use figured dimensions only. Check and verify levels and dimensions on site prior to commencement of any work, the preparation of drawings or the fabrication of components.
This drawing is copyright and can not be reproduced without written consent.

Client
Sue & Andy Baker

Le Velo

True North



Billy Blue College of Design
46-52 Mountain Street, Ultimo, NSW 2007, Australia
+61 (0)2 9999 9999




Project
IDC302A
48 Baywater Drive, Wentworth Point, NSW, 2127
Project number
20,001

Drawing Title
Level 2 Plan

Drawing Status
PRESENTATION DRAWINGS
NOT FOR CONSTRUCTION

Scale
1:100
Drawing No
A04
Issue
01
Date
21.08.21
Drawn by
MB

21/08/2021 7:05:42 AM

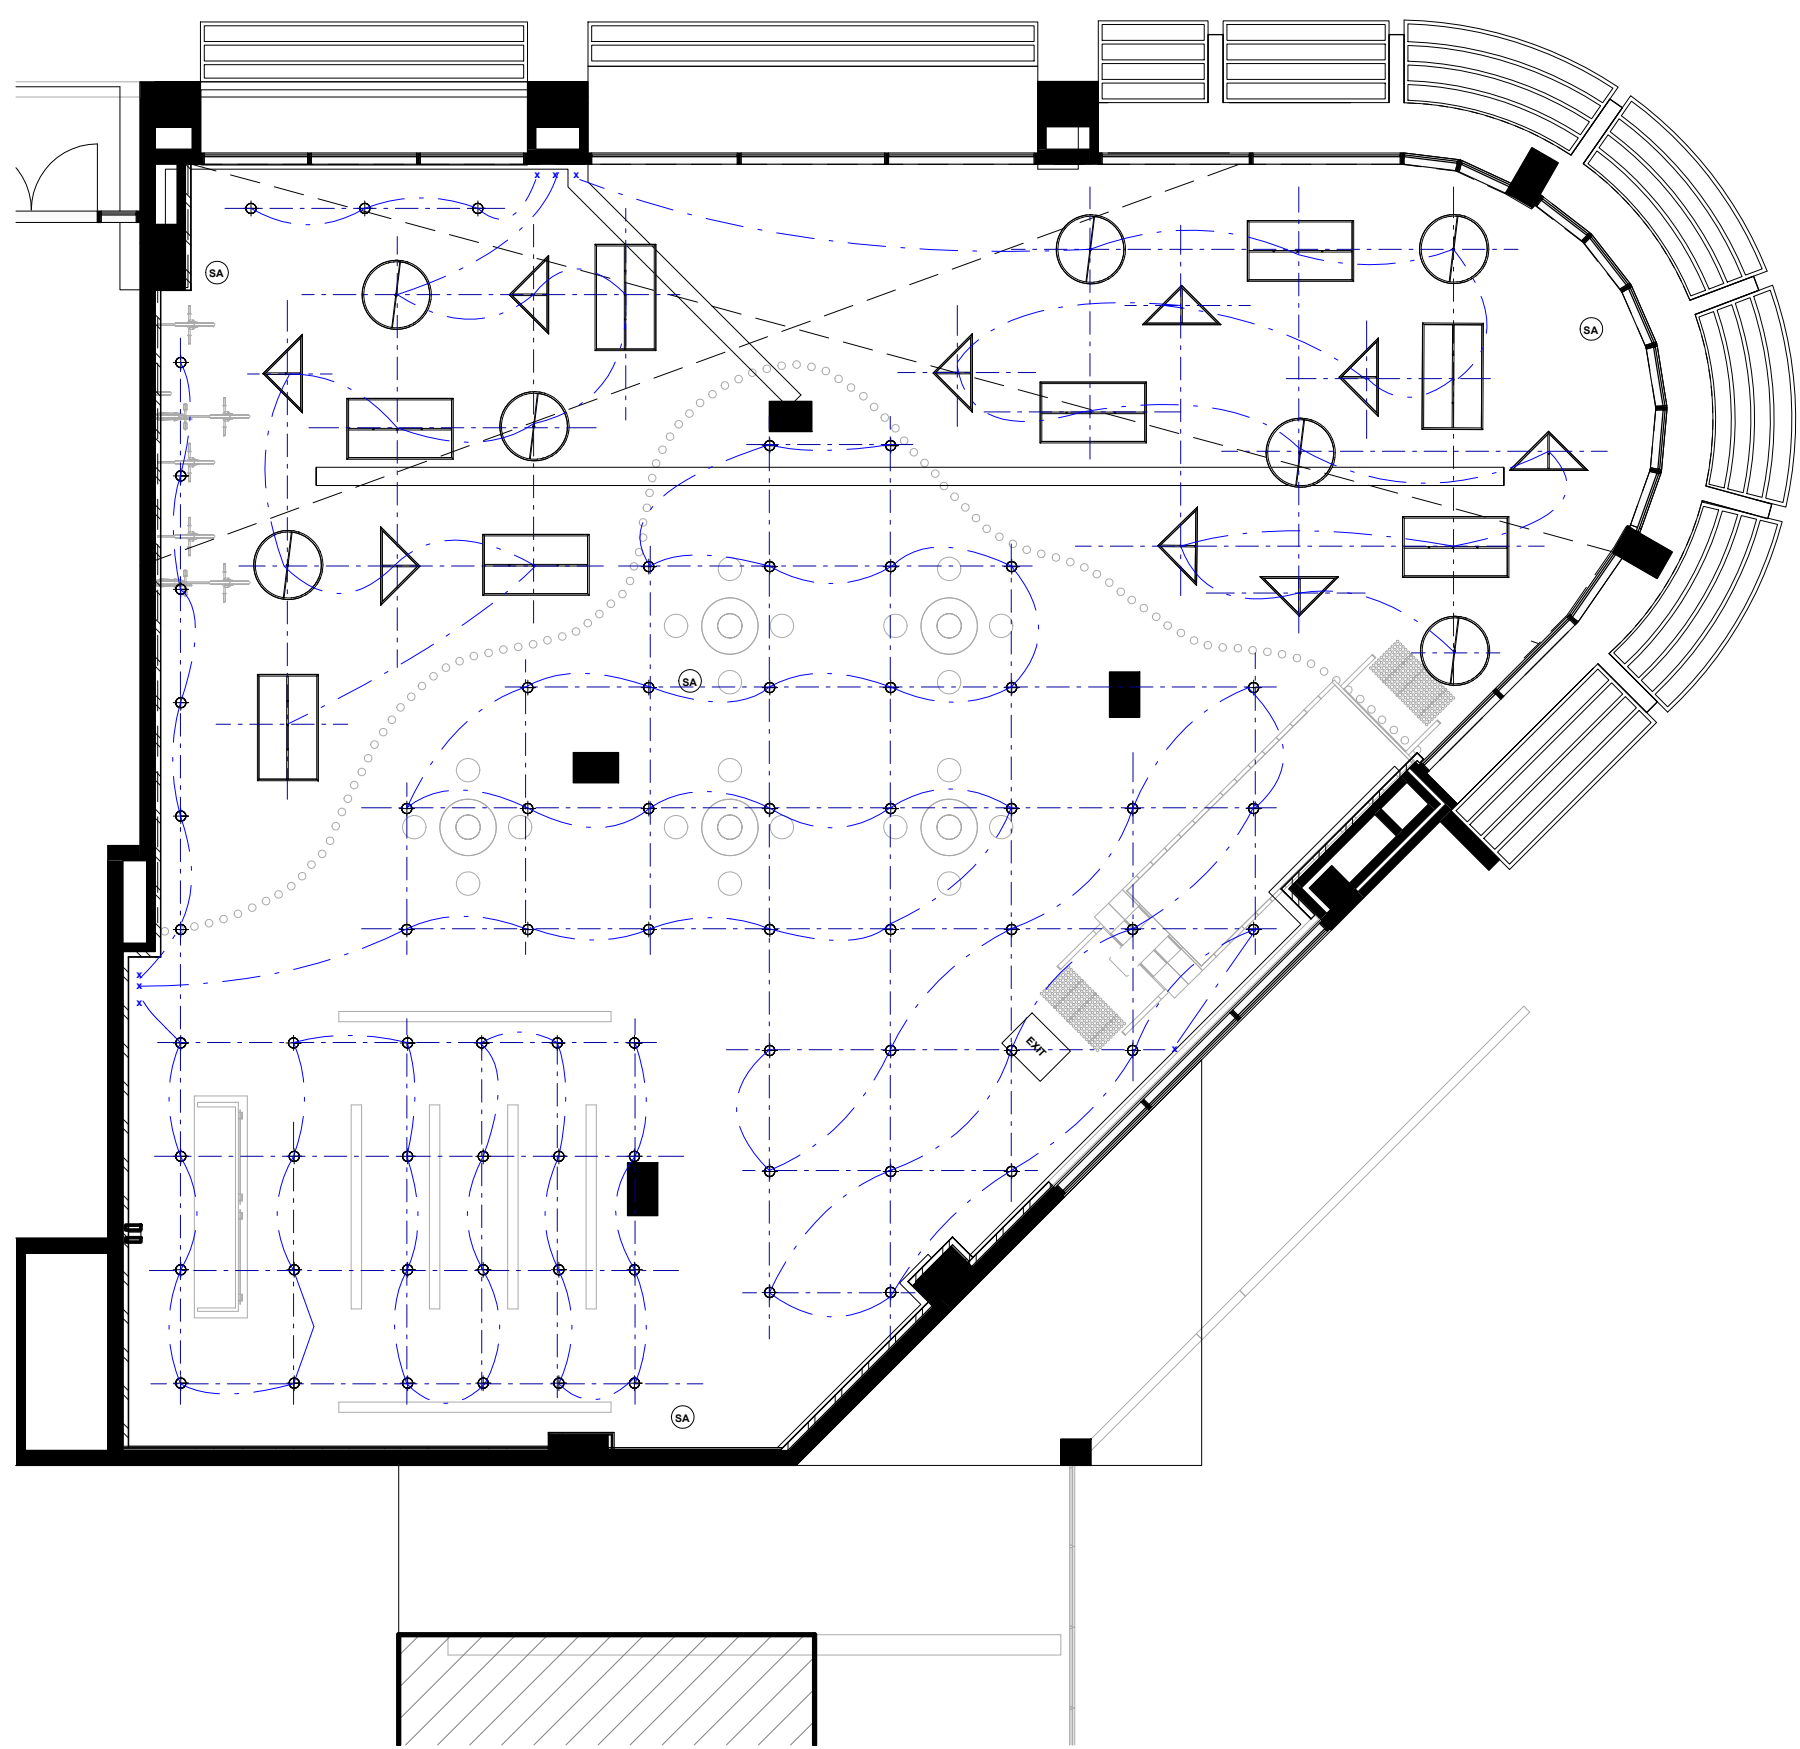

1 Level 2 RCP
1 : 100

RCP Legend			
	Lighting Fixture Grid		Smoke Alarm
	Lighting Fixture Wire		Exit Signs
	Lighting Power Switch		Lighting fixtures

LEGEND

Cut Material			
	Existing Structure		Concrete
	Plaster Board		Steel
	Tiles		Glass

Wall Types	
WT1	2mm glue + 70mm Recycled Brick
WT2	2mm glue + 70mm Recycled Brick + 2mm Artwork finish
WT3	Timber stud wall 100 x 50 w/ 13mm FC + 2mm glue + 3mm Micro topping finish to each side
WT4	13mm FC + 2mm glue + 3mm Micro topping finish
WT5	Timber stud wall 100 x 50 w/ 13mm FC + 2mm glue + 3mm Micro topping finish

Door Types	
DO1	Flush Door 810mm x 2110mm
DO2	Toilet cubicle Door 650mm x 2110mm
DO3	Flush Double Doors 1510mm x 2110mm

Abbreviations			
AP	Appliances	MA	Material
D	Door	PB	Plaster Board
DA	Development Application	SA	Sanitary
EQ	Equipment	SS	Stainless Steel
FU	Furniture	WT	Wall Type
		W/	With

Tag Legend	
MA01	Wall Paint White by Porters paints
MA02	Wall Concrete by Hanson
MA03	Wall Tiles by Beaumont tiles
MA04	Wall Bricks by Austral bricks
MA05	Bar Glass by Express Glass
MA06	Bar Cement slab by Buntings
MA11	Stairs Steel by Pacific Metal work
MA12	Bathroom Walls
MA16	Wall Paint Grey by porters paints
MA18	Glass by Express glass
MA19	Female/Male Sign
MA20	Concrete Slab Table
MA21	Aluminium Seat Swing
MA22	Steel Shipping Container
MA23	Repair Stand
MA24	Pot Plant
MA25	Ceiling Plant by Porters Paints
AP01	IMC Refrigeration Module B16704S
AP02	IMC Glass Door Module B16700S
AP05	IMC Wine Chiller Module B16703S
AP08	Waldorf Pasta Cooker PC8140G
AP09	Waldorf Kitchen Benchtops BT8600CB
AP12	Waldorf 8620 series8 Burners Double Static Oven RN8820G
AP13	Waldorf Refridgerator RN8100GRB
AP16	Waldorf Chargrill CH8900G-LS
AP18	Waldorf Gas fryer FN8120G
EQ02	IMC Bar Ice Chest BZ54060
EQ06	IMC Shelf Drainer BZ38100
EQ08	IMC Perforated Worktop BZ69100
EQ09	IMC Beer Station BZ34060
EQ11	IMC Basket Rack BZ23050
EQ13	IMC Double Sink BZ52100
EQ14	IMC Worktop Unit BZ50060
EQ18	IMC Storage Cupboard BZ61060
EQ20	IMC Three Drawer Unit BZ64040
EQ41	Waldorf BenchTop BT8450LS
EQ42	Ryno 600Series Bench SB6150A
EQ44	Street Furniture Bin 80LLB4
EQ45	Street Furniture Semi Hoop Bike Stand
BST03	
EQ56	IPS Paypoint Electronic Cash Register
EQ57	CommBank TapPay Contacless Payment
EQ50	LaMarzococ Coffee Machine FB80
EQ61	Toyko Bike SS
EQ62	Dog Bowl
EQ63	Bike RepairStand
EQ64	Mesh Gallery Partitions
EQ65	Outdoor Swing Seating
EQ67	Overhead Shelving Bar
EQ68	Retail Bar Table
FU10	Tait Linear Table & Benches
FU16	Style craft Spike Low Stool H450mm
FU11	Arper Dizzie Side Table Black
FU12	Take Away Counter
SA01	Dyson Hand Dryer Unit BZ50
SA03	Contura Recessed Soap Dispenser
SA05	RBA Jumbo Toilet Dispenser B2890
SA06	RBA Sanitary Mounted Napkin Disposal
B270	
SA11	RBA Full Height Basin RBA8881-100
SA12	Plumbing Fixtures Urinal
SA13	Toilet Plumbing Fixtures WC
SA14	Toilet Handicaped Grab Bars

Revisions		
No	Date	Description
01	21.08.21	PRESENTATION DRAWINGS

Do not scale drawings. Use figured dimensions only. Check and verify levels and dimensions on site prior to commencement of any work, the preparation of drawings or the fabrication of components.
This drawing is copyright and can not be reproduced without written consent.

Client
Sue & Andy Baker
Le Velo



Billy Blue College of Design
46-52 Mountain Street, Ultimo, NSW 2007, Australia
+61 (0)2 9999 9999

Project
IDC302A
48 Baywater Drive, Wentworth Point, NSW, 2127
Project number
20,001


Drawing Title
Level 2 RCP

Drawing Status
PRESENTATION DRAWINGS
NOT FOR CONSTRUCTION

Scale
Drawing No
Issue
A05 01

Date
21.08.21

Drawn by
Author

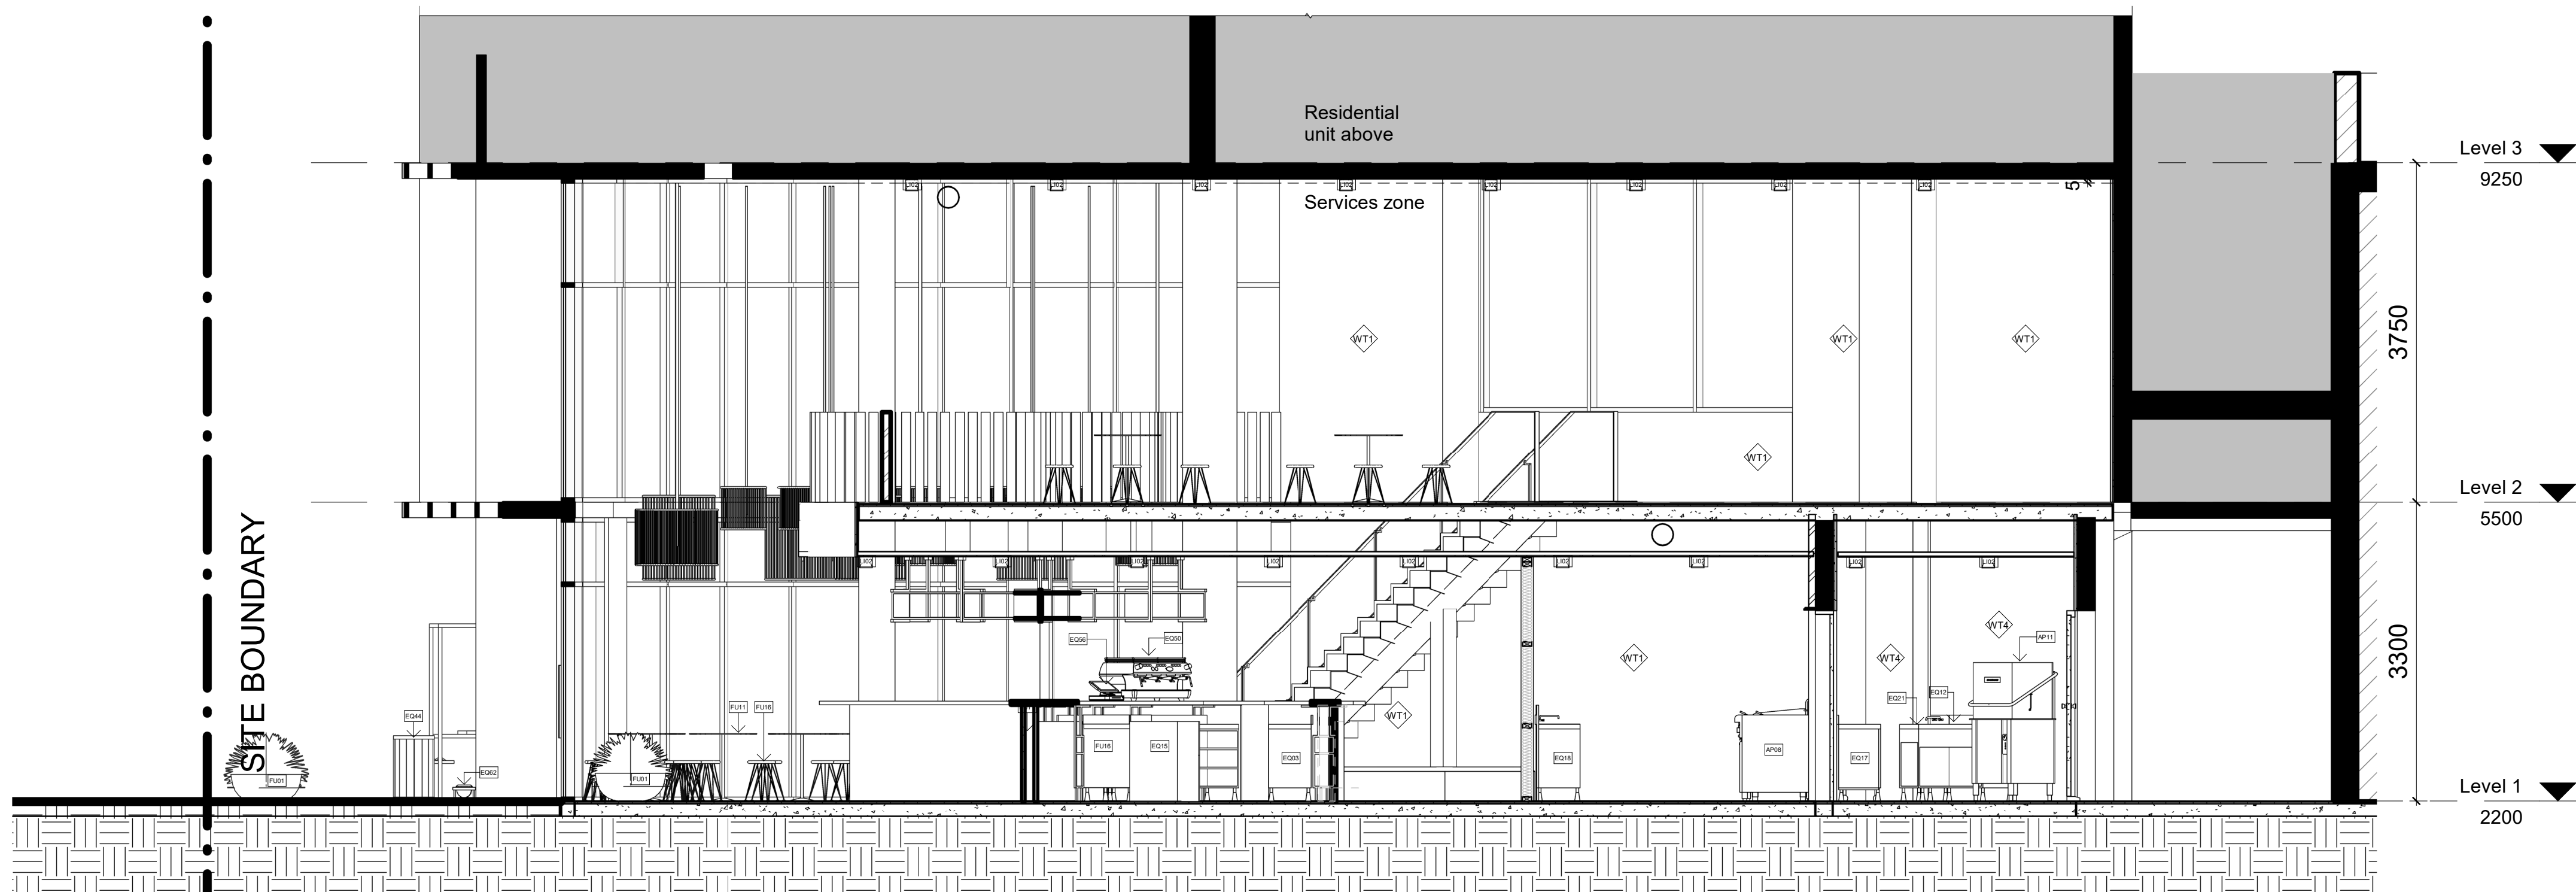

1 Section 1
1 : 50

LEGEND

Cut Material

	Concrete		Steel
	Plaster Board		Glass
	Tiles		

Wall Types

	WT1	2mm glue + 70mm Recycled Brick
	WT2	2mm glue + 70mm Recycled Brick + 2mm Artwork finish
	WT3	Timber stud wall 100 x 50 w/ 13mm FC + 2mm glue + 3mm Micro topping finish to each side
	WT4	13mm FC + 2mm glue + 3mm Micro topping finish
	WT5	Timber stud wall 100 x 50 w/ 13mm FC + 2mm glue + 3mm Micro topping finish

Door Types

	DO1	Flush Door 810mm x 2110mm
	DO2	Toilet cubicle Door 650mm x 2110mm
	DO3	Flush Double Doors 1510mm x 2110mm

Abbreviations

AP	Appliances	MA	Material
D	Door	PB	Plaster Board
DA	Development Application	SA	Sanitary
EQ	Equipment	SS	Stainless Steel
FU	Furniture	WT	Wall Type
		W/	With

Tag Legend

MA01	Wall Paint White by Porters paints
MA02	Wall Concrete by Hanson
MA03	Wall Tiles by Beaumont tiles
MA04	Wall Bricks by Austral bricks
MA05	Bar Glass by Express Glass
MA06	Bar Cement slab by Burnings
MA11	Stairs Steel by Pacific Metal work
MA12	Bathroom Walls
MA16	Wall Paint Grey by porters paints
MA18	Glass by Express glass
MA19	Female/Male Sign
MA20	Concrete Slab Table
MA21	Aluminum Seat Swing
MA22	Steel Shipping Container
MA23	Repair Stand
MA24	Pot Plant
MA25	Ceiling Plant by Porters Paints
AP01	IMC Refrigeration Module B16704S
AP02	IMC Glass Door Module B16700S
AP05	IMC Wine Chiller Module B16703S
AP08	Waldorf Pasta Cooker PC8140G
AP09	Waldorf Kitchen Benchtops BT8600CB
AP12	Waldorf 8820 series8 Burners Double Static Oven RN8820G
AP13	Waldorf Refridgerator RN8100GRB
AP16	Waldorf Chgrill CH8900G-LS
AP18	Waldorf Gas fryer FN8120G
EQ02	IMC Bar Ice Chest BZ54060
EQ06	IMC Shelf Drainer BZ38100
EQ08	IMC Perforated Worktop BZ69100
EQ09	IMC Beer Station BZ34060
EQ11	IMC Basket Rack BZ23050
EQ13	IMC Double Sink BZ52100
EQ14	IMC Worktop Unit BZ50060
EQ18	IMC Storage Cupboard BZ61060
EQ20	IMC Three Drawer Unit BZ64040
EQ41	Waldorf BenchTop BT8450LS
EQ42	Ryno 600Series Bench SB6150A
EQ44	Street Furniture Bin 80LLB4
EQ45	Street Furniture Semi Hoop Bike Stand
BS103	
EQ56	IPS Paypoint Electronic Cash Register
EQ57	CommBank TapPay Contacless Payment
EQ50	LaMarzoccoc Coffee Machine FB80
EQ61	Toyko Bike SS
EQ62	Dog Bowl
EQ63	Bike RepairStand
EQ64	Mesh Gallery Partitions
EQ65	Outdoor Swing Seating
EQ67	Overhead Shelving Bar
EQ68	Retail Bar Table
FU10	Tait Linear Table & Benches
FU16	Style craft Spike Low Stool H450mm
FU11	Arper Dizzie Side Table Black
FU12	Take Away Counter
SA01	Dyson Hand Dryer Unit BZ50
SA03	Contura Recessed Soap Dispenser
SA05	RBA Jumbo Toilet Dispenser B2890
SA06	RBA Sanitary Mounted Napkin Disposal
B270	
SA11	RBA Full Height Basin RBA8881-100
SA12	Plumbing Fixtures Urinal
SA13	Toilet Plumbing Fixtures WC
SA14	Toilet Handicaped Grab Bars

Revisions		
No	Date	Description
01	21.08.21	PRESENTATION DRAWINGS

Ver. App'd
XX App'd

Do not scale drawings. Use figured dimensions only. Check and verify levels and dimensions on site prior to commencement of any work, the preparation of drawings or the fabrication of components.
This drawing is copyright and can not be reproduced without written consent.

Client
Sue & Andy Baker

Le Velo

True North

Billy Blue College of Design
46-52 Mountain Street, Ultimo, NSW 2007, Australia
+61 (0)2 9999 9999



Project

IDC302A

48 Baywater Drive, Wentworth Point, NSW, 2127

Project number
20,001

Drawing Title

Section 1

Drawing Status

PRESENTATION DRAWINGS
NOT FOR CONSTRUCTION

Scale

1:50

Date

Drawing No

A06


Issue

01

Drawn by

MB

21/08/2021 7:06:40 AM

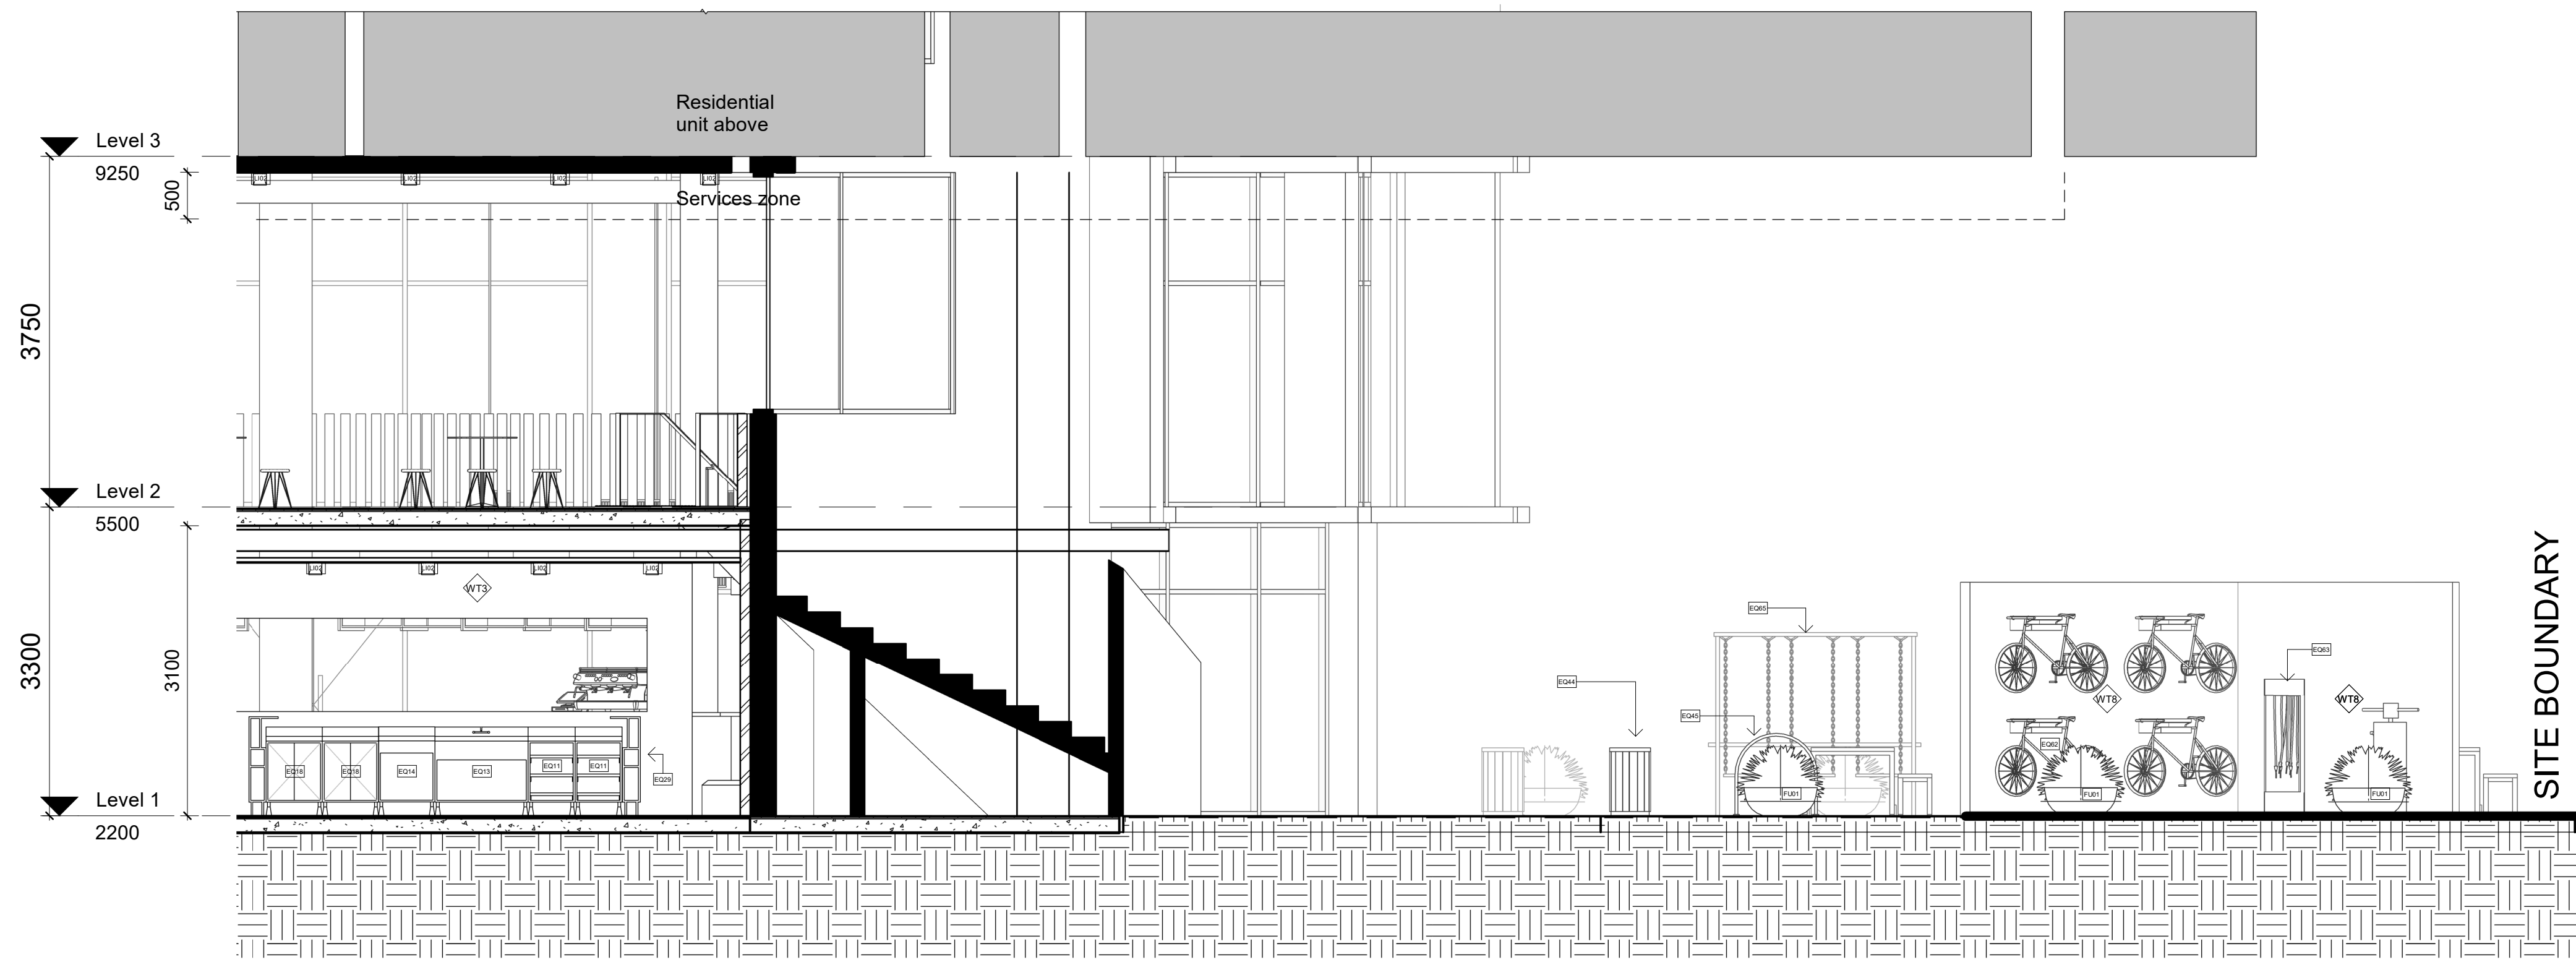

1 Section 2
1 : 50

LEGEND

Cut Material

	Existing Structure		Concrete
	Plaster Board		Steel
	Tiles		Glass

Wall Types

	WT1	2mm glue + 70mm Recycled Brick
	WT2	2mm glue + 70mm Recycled Brick + 2mm Artwork finish
	WT3	Timber stud wall 100 x 50 w/ 13mm FC + 2mm glue + 3mm Micro topping finish to each side
	WT4	13mm FC + 2mm glue + 3mm Micro topping finish
	WT5	Timber stud wall 100 x 50 w/ 13mm FC + 2mm glue + 3mm Micro topping finish

Door Types

	DO1	Flush Door 810mm x 2110mm
	DO2	Toilet cubicle Door 650mm x 2110mm
	DO3	Flush Double Doors 1510mm x 2110mm

Abbreviations


AP	Appliances	MA	Material
D	Door	PB	Plaster Board
DA	Development Application	SA	Sanitary
EQ	Equipment	SS	Stainless Steel
FU	Furniture	WT	Wall Type
		W/	With

Tag Legend

MA01	Wall Paint White by Porters paints
MA02	Wall Concrete by Hanson
MA03	Wall Tiles by Beaumont tiles
MA04	Wall Bricks by Austral bricks
MA05	Bar Glass by Express Glass
MA06	Bar Cement slab by Bunnings
MA11	Stairs Steel by Pacific Metal work
MA12	Bathroom Walls
MA16	Wall Paint Grey by porters paints
MA18	Glass by Express glass
MA19	Female/Male Sign
MA20	Concrete Slab Table
MA21	Aluminum Seat Swing
MA22	Steel Shipping Container
MA23	Repair Stand
MA24	Pot Plant
MA25	Ceiling Plant by Porters Paints
AP01	IMC Refrigeration Module B16704S
AP02	IMC Glass Door Module B16700S
AP05	IMC Wine Chiller Module B16703S
AP08	Waldorf Pasta Cooker PC8140G
AP09	Waldorf Kitchen Benchtops BT8600CB
AP12	Waldorf 8820 series8 Burners Double Static Oven RN8820G
AP13	Waldorf Refrigerator RN8100GRB
AP16	Waldorf Charnill CH8900G-LS
AP18	Waldorf Gas fryer FN8120G
EQ02	IMC Bar Ice Chest BZ54060
EQ06	IMC Shelf Drainer BZ38100
EQ08	IMC Perforated Worktop BZ69100
EQ09	IMC Beer Station BZ34080
EQ11	IMC Basket Rack BZ23050
EQ13	IMC Double Sink BZ52100
EQ14	IMC Worktop Unit BZ50060
EQ18	IMC Storage Cupboard BZ61060
EQ20	IMC Three Drawer Unit BZ64040
EQ41	Waldorf BenchTop BT8450LS
EQ42	Ryno 600Series Bench SB6150A
EQ44	Street Furniture Bin 80LLB4
EQ45	Street Furniture Semi Hoop Bike Stand
BST03	
EQ56	IPS Paypoint Electronic Cash Register
EQ57	CommBank TapPay Contactless Payment
EQ50	LaMarzocco Coffee Machine FB80
EQ61	Toyko Bike SS
EQ62	Dog Bowl
EQ63	Bike Repair Stand
EQ64	Mesh Gallery Partitions
EQ65	Outdoor Swing Seating
EQ67	Overhead Shelving Bar
EQ68	Retail Bar Table
FU10	Tait Linear Table & Benches
FU16	Style craft Spike Low Stool H450mm
FU11	Arper Dizzie Side Table Black
FU12	Take Away Counter
SA01	Dyson Hand Dryer Unit BZ50
SA03	Contura Recessed Soap Dispenser
SA05	RBA Jumbo Toilet Dispenser B2890
SA06	RBA Sanitary Mounted Napkin Disposal B270
SA11	RBA Full Height Basin RBA8881-100
SA12	Plumbing Fixtures Urinal
SA13	Toilet Plumbing Fixtures WC
SA14	Toilet Handicaped Grab Bars



Revisions			Do not scale drawings. Use figured dimensions only. Check and verify levels and dimensions on site prior to commencement of any work, the preparation of drawings or the fabrication of components. This drawing is copyright and can not be reproduced without written consent.	Client Sue & Andy Baker Le Velo	True North	Billy Blue College of Design 46-52 Mountain Street, Ultimo, NSW 2007, Australia +61 (0)2 9999 9999 BILLY BLUE COLLEGE OF DESIGN TORRENS UNIVERSITY AUSTRALIA LAUREATE INTERNATIONAL UNIVERSITIES	Project IDC302A 48 Baywater Drive, Wentworth Point, NSW, 2127 Project number 20,001	Drawing Title Section 2 Drawing Status PRESENTATION DRAWINGS NOT FOR CONSTRUCTION	Scale 1:50 Date 21.08.21 Drawn by Author	Drawing No A07 Issue 01
No	Date	Description								
01	21.08.21	PRESENTATION DRAWINGS								
		Ver. App'd XX App'd								

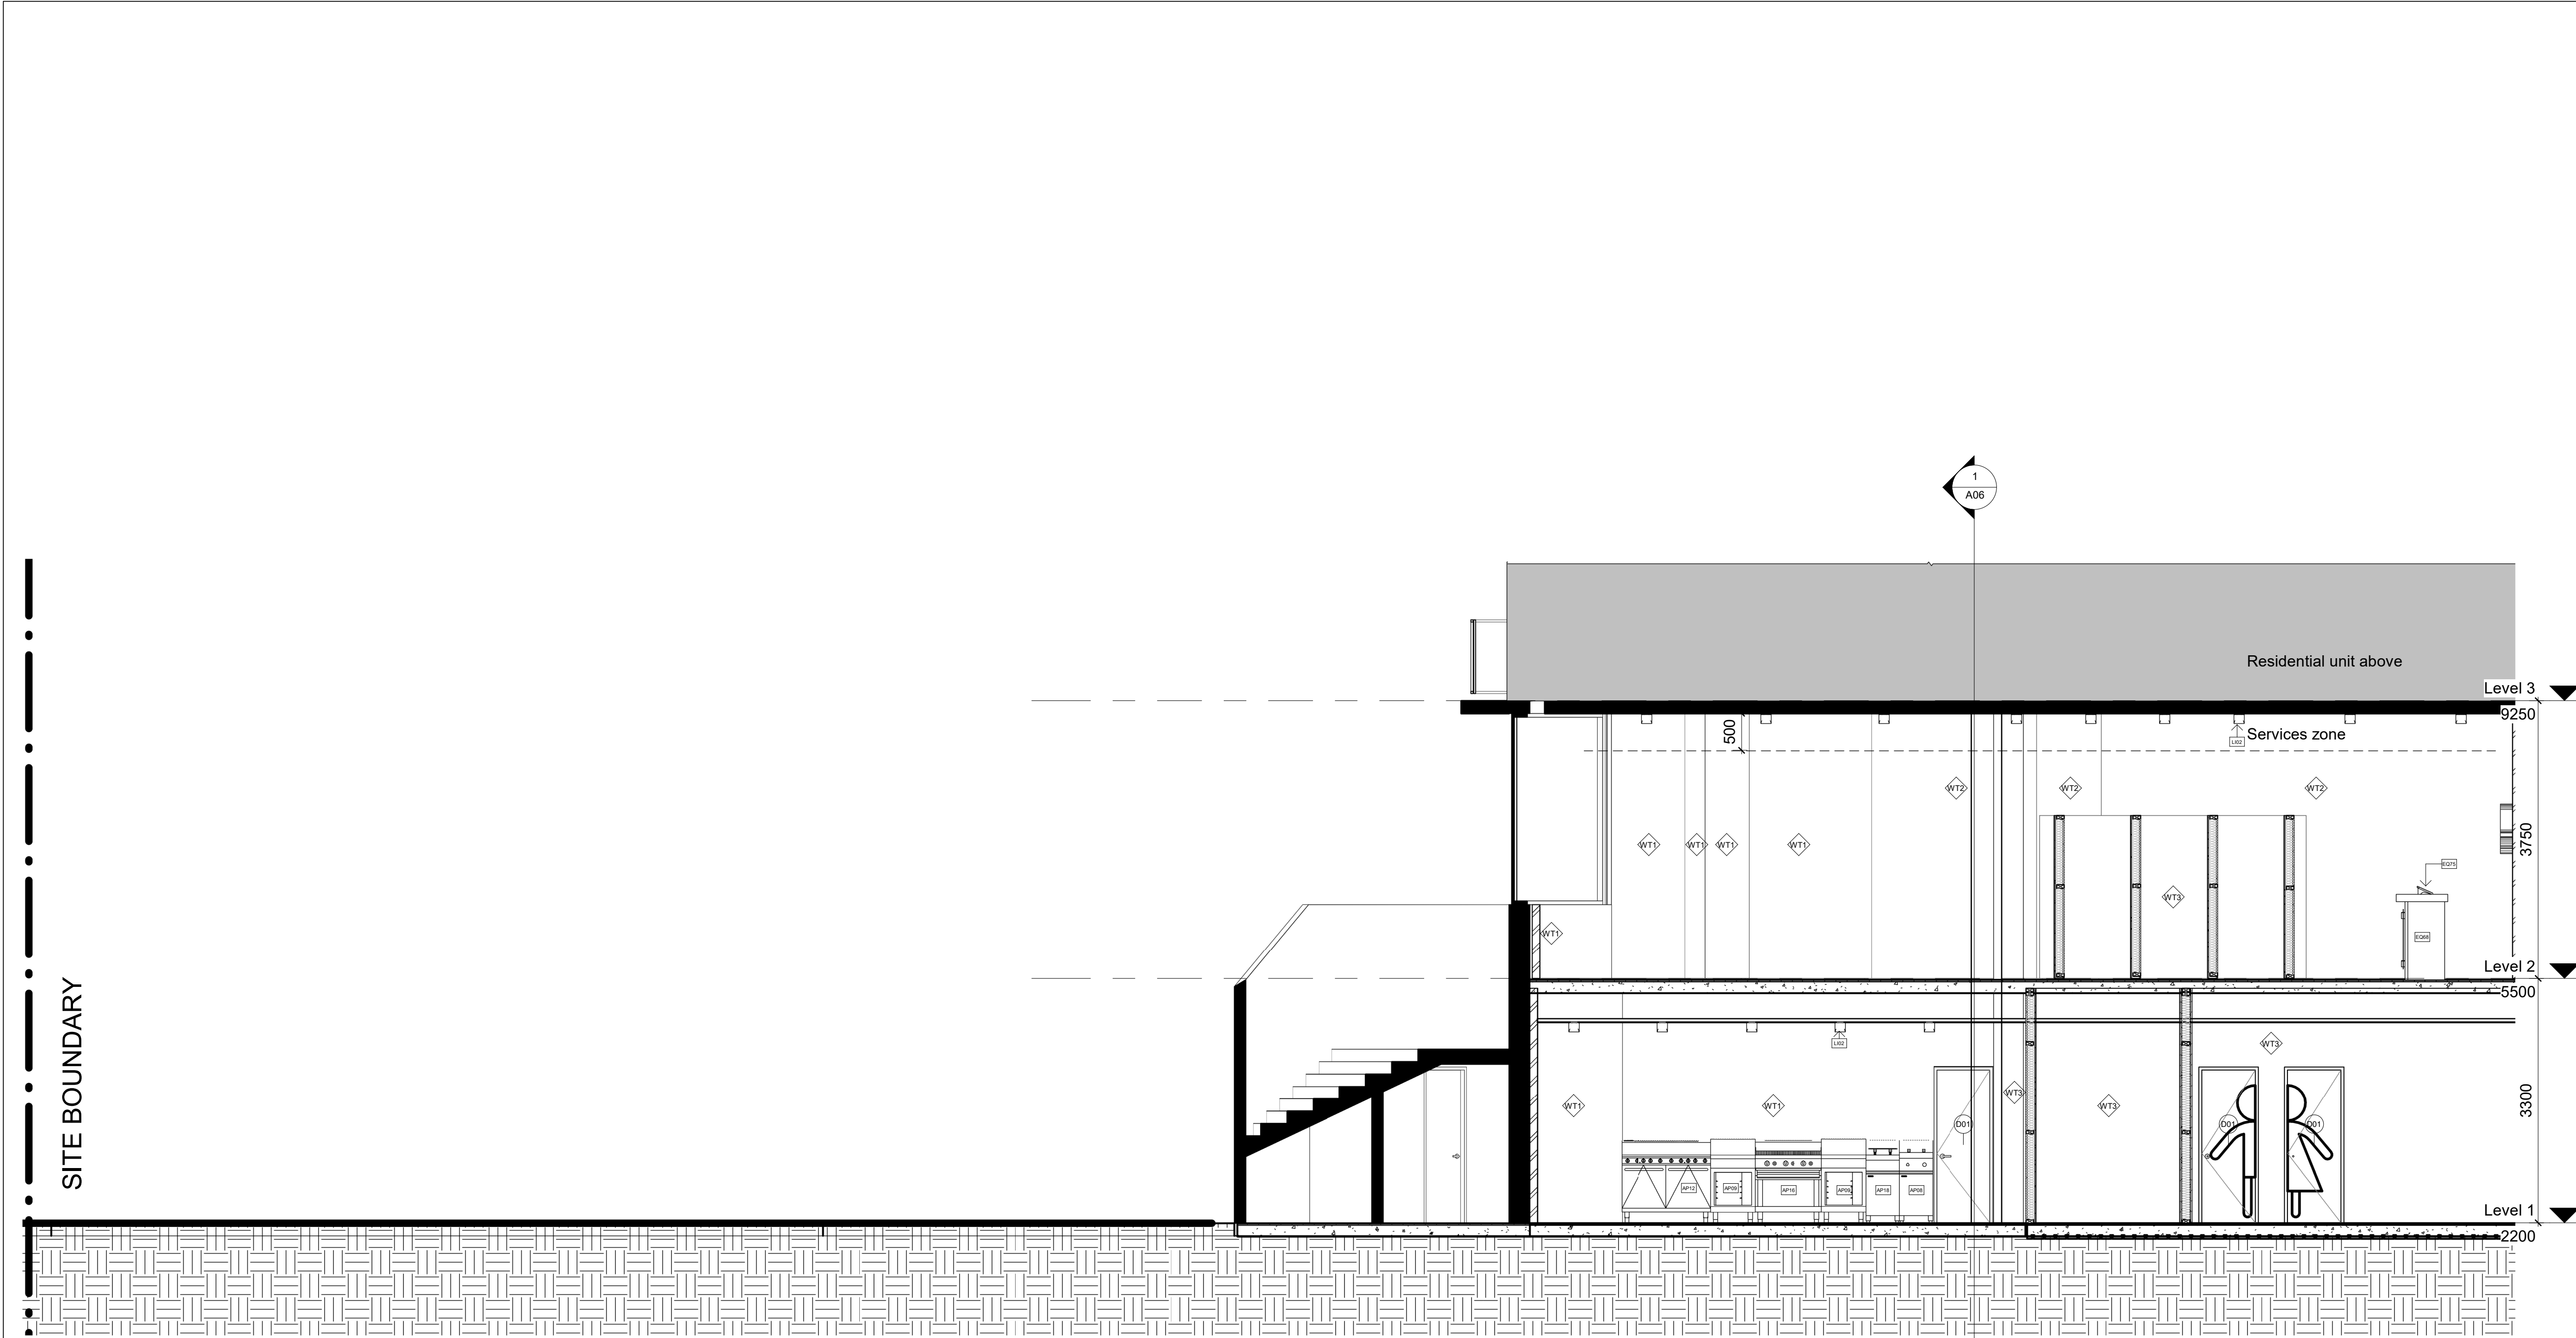

1 Section 3
1 : 50

LEGEND

Cut Material

	Existing Structure		Concrete
	Plaster Board		Steel
	Tiles		Glass

Wall Types

	WT1	2mm glue + 70mm Recycled Brick
	WT2	2mm glue + 70mm Recycled Brick + 2mm Artwork finish
	WT3	Timber stud wall 100 x 50 w/ 13mm FC + 2mm glue + 3mm Micro topping finish to each side
	WT4	13mm FC + 2mm glue + 3mm Micro topping finish
	WT5	Timber stud wall 100 x 50 w/ 13mm FC + 2mm glue + 3mm Micro topping finish

Door Types

	DO1	Flush Door 810mm x 2110mm
	DO2	Toilet cubicle Door 650mm x 2110mm
	DO3	Flush Double Doors 1510mm x 2110mm

Abbreviations

AP	Appliances	MA	Material
D	Door	PB	Plaster Board
DA	Development Application	SA	Sanitary
EQ	Equipment	SS	Stainless Steel
FU	Furniture	WT	Wall Type
		W/	With

Tag Legend

MA01	Wall Paint White by Porters paints
MA02	Wall Concrete by Hanson
MA03	Wall Tiles by Beaumont tiles
MA04	Wall Bricks by Austral bricks
MA05	Bar Glass by Express Glass
MA06	Bar Cement slab by Burnings
MA11	Stairs Steel by Pacific Metal work
MA12	Bathroom Walls
MA16	Wall Paint Grey by porters paints
MA18	Glass by Express glass
MA19	Female/Male Sign
MA20	Concrete Slab Table
MA21	Aluminium Seat Swing
MA22	Steel Shipping Container
MA23	Repair Stand
MA24	Pot Plant
MA25	Ceiling Plant by Porters Paints
AP01	IMC Refrigeration Module B16704S
AP02	IMC Glass Door Module B16700S
AP05	IMC Wine Chiller Module B16703S
AP08	Waldorf Pasta Cooker PC8140G
AP09	Waldorf Kitchen Benchtops BT8600CB
AP12	Waldorf 8620 series8 Burners Double Static Oven RN8820G
AP13	Waldorf Refridgerator RN8100GRB
AP16	Waldorf Chargrill CH8900G-LS
AP18	Waldorf Gas fryer FN8120G
EQ02	IMC Bar Ice Chest BZ54060
EQ06	IMC Shelf Drainer BZ38100
EQ08	IMC Perforated Worktop BZ69100
EQ09	IMC Beer Station BZ34060
EQ11	IMC Basket Rack BZ23050
EQ13	IMC Double Sink BZ52100
EQ14	IMC Worktop Unit BZ50060
EQ18	IMC Storage Cupboard BZ61060
EQ20	IMC Three Drawer Unit BZ64040
EQ41	Waldorf BenchTop BT8450LS
EQ42	Ryno 600Series Bench SB6150A
EQ44	Street Furniture Bin 80LLB4
EQ45	Street Furniture Semi Hoop Bike Stand
BST03	
EQ56	IPS Paypoint Electronic Cash Register
EQ57	CommBank TapPay Contacless Payment
EQ50	LaMarzocco Coffee Machine FB80
EQ61	Toyko Bike SS
EQ62	Dog Bowl
EQ63	Bike RepairStand
EQ64	Mesh Gallery Partitions
EQ65	Outdoor Swing Seating
EQ67	Overhead Shelving Bar
EQ68	Retail Bar Table
FU10	Tait Linear Table & Benches
FU16	Style craft Spike Low Stool H450mm
FU11	Arper Dizzie Side Table Black
FU12	Take Away Counter
SA01	Dyson Hand Dryer Unit BZ50
SA03	Contura Recessed Soap Dispenser
SA05	RBA Jumbo Toilet Dispenser B2890
SA06	RBA Sanitary Mounted Napkin Disposal
B270	
SA11	RBA Full Height Basin RBA8881-100
SA12	Plumbing Fixtures Urinal
SA13	Toilet Plumbing Fixtures WC
SA14	Toilet Handicaped Grab Bars

Revisions			Do not scale drawings. Use figured dimensions only. Check and verify levels and dimensions on site prior to commencement of any work, the preparation of drawings or the fabrication of components. This drawing is copyright and can not be reproduced without written consent.	Client Sue & Andy Baker <i>Le Velo</i>	True North	Billy Blue College of Design 46-52 Mountain Street, Ultimo, NSW 2007, Australia +61 (0)2 9999 9999 	Project IDC302A 48 Baywater Drive, Wentworth Point, NSW, 2127 Project number 20,001	Drawing Title Section 3 Drawing Status PRESENTATION DRAWINGS NOT FOR CONSTRUCTION	Scale 1:50 Date 21.08.21 Drawn by Author	Drawing No A08 Issue 01
No	Date	Description								
01	21.08.21	PRESENTATION DRAWINGS								

21/08/2021 7:07:41 AM

A1



MA01	Wall Paint White by Porters paints
MA02	Wall Concrete by Hanson
MA03	Wall Tiles by Beaumont tiles
MA04	Wall Bricks by Austral bricks
MA05	Bar Glass by Express Glass
MA06	Bar Cement slab by Bunnings
MA11	Stairs Steel by Pacific Metal work
MA12	Bathroom Tiles by Bunnings
MA16	Wall Paint Grey by porters paints
MA18	Glass by Express glass
MA19	Female/Male Sign
MA20	Concrete Slab Table
MA21	Aluminum Seat Swing
MA22	Steel Shipping Container
MA23	Repair Stand
MA24	Pot Plant
MA25	Ceiling Plant by Porters Paints
AP01	IMC Refrigeration Module B16704S
AP02	IMC Glass Door Module B16700S
AP05	IMC Wine Chiller Module B16703S
AP08	Waldorf Pasta Cooker PC8410G
AP09	Waldorf Kitchen Benchtops BT8600CB
AP13	Waldorf 8820 series8 Burners Double Stove Oven RN8820G
AP17	Waldorf Refrigerator RN8100GRB
AP16	Waldorf Gasgrill CH8900G-LS
AP18	Waldorf Gas fryer FN8120G
EQ02	IMC Bar Ice Chest BZ5406G
EQ06	IMC Shelf Drainer BZ3810U
EQ08	IMC Perforated Worktop BZ6910U
EQ09	IMC Bed Stand BZ3405U
EQ11	IMC Basket Rack BZ2305U
EQ13	IMC Double Sink BZ5210U
EQ14	IMC Worktop Unit BZ5006U
EQ18	IMC Storage Cupboard BZ6106U
EQ20	IMC Three Drawer Unit BZ6404U
EQ41	Waldorf BenchTop BT18450L.S
EQ42	Ryno 600Series Bench SB6150A
EQ43	Street Furniture 801LLB
EQ45	Street Furniture Semi Hoop Bike Stand
BS03	
EQ56	IPS Paypoint Electronic Cash Register
EQ57	CommBank TapPay Contactless Payment
EQ50	LaMarzocco Coffee Machine FB80
EQ61	Tokyo Bike SS
EQ62	Dog Bowl
EQ63	Bike RepairStand
EQ64	Mesh Gallery Partitions
EQ65	Outdoor Swing Seating
EQ67	Overhead Shelving Bar
EQ68	Retail Bar Table
FU10	Tait Linear Table & Benches
FU16	Style craft Spike Low Stool H450mm
FU17	Open Dizzi Table Black
FU12	Take Away Counter
SA01	Dyson Hand Dryer Unit BZ50
SA03	Centura Recessed Soap Dispenser
SA05	RBA Jumbo Toilet Dispenser B2890
SA06	RBA Sanitary Mounted Napkin Dispisal
BZ70	
SA11	RBA Full Height Basin RBA8881-100
SA12	Plumbing Fixtures URNA
SA13	Toilet Plumbing Fixtures WC
SA14	Toilet Handicaped Grab Bars

A1



1 Bar View 1

LEGEND

Cut Material			
	Existing Structure		Concrete
	Plaster Board		Steel
	Tiles		Glass

Wall Types	
WT1	2mm glue + 70mm Recycled Brick
WT2	2mm glue + 70mm Recycled Brick + 2mm Artwork finish
WT3	Timber stud wall 100 x 50 w/ 13mm FC + 2mm glue + 3mm Micro topping finish to each side
WT4	13mm FC + 2mm glue + 3mm Micro topping finish
WT5	Timber stud wall 100 x 50 w/ 13mm FC + 2mm glue + 3mm Micro topping finish

Door Types	
DO1	Flush Door 810mm x 2110mm
DO2	Toilet cubicle Door 650mm x 2110mm
DO3	Flush Double Doors 1510mm x 2110mm


Abbreviations			
AP	Appliances	MA	Material
D	Door	PB	Plaster Board
DA	Development Application	SA	Sanitary
EQ	Equipment	SS	Stainless Steel
FU	Furniture	WT	Wall Type
		W/	With

Tag Legend	
MA01	Wall Paint White by Porters paints
MA02	Wall Concrete by Hanson
MA03	Wall Tiles by Beaumont tiles
MA04	Wall Bricks by Austral bricks
MA05	Bar Glass by Express Glass
MA06	Bar Cement slab by Bunnings
MA11	Stairs Steel by Pacific Metal work
MA12	Bathroom Walls
MA16	Wall Paint Grey by porters paints
MA18	Glass by Express glass
MA19	Female/Male Sign
MA20	Concrete Slab Table
MA21	Aluminum Seat Swing
MA22	Steel Shipping Container
MA23	Repair Stand
MA24	Pot Plant
MA25	Ceiling Plant by Porters Paints
AP01	IMC Refrigeration Module B16704S
AP02	IMC Glass Door Module B16700S
AP05	IMC Wine Chiller Module B16703S
AP08	Waldorf Pasta Cooker PC8140G
AP09	Waldorf Kitchen Benchtops BT8600CB
AP12	Waldorf 8820 series8 Burners Double Static Oven RN8820G
AP13	Waldorf Refrigerator RN8100GRB
AP16	Waldorf Charnitl CH8000C-LS
AP18	Waldorf Gas fryer FN8120G
EQ02	IMC Bar Ice Chest BZ54060
EQ06	IMC Shelf Drainer BZ38100
EQ08	IMC Perforated Worktop BZ69100
EQ09	IMC Beer Station BZ34060
EQ11	IMC Basket Rack BZ23050
EQ13	IMC Double Sink BZ52100
EQ14	IMC Worktop Unit BZ50060
EQ18	IMC Storage Cupboard BZ61060
EQ20	IMC Three Drawer Unit BZ64040
EQ41	Waldorf BenchTop BT8450LS
EQ42	Ryno 600Series Bench SB6150A
EQ44	Street Furniture Bin 80LLB4
EQ45	Street Furniture Semi Hoop Bike Stand BST03
EQ56	IPS Paypoint Electronic Cash Register
EQ57	CommBank TapPay Contactless Payment
EQ50	LaMarzocco Coffee Machine FB80
EQ61	Toyko Bike SS
EQ62	Dog Bowl
EQ63	Bike RepairStand
EQ64	Mesh Gallery Partitions
EQ65	Outdoor Swing Seating
EQ67	Overhead Shelving Bar
EQ68	Retail Bar Table
FU10	Tail Linear Table & Benches
FU16	Style craft Spike Low Stool H450mm
FU11	Arper Dizzie Side Table Black
FU12	Take Away Counter
SA01	Dyson Hand Dryer Unit BZ50
SA03	Centura Recessed Soap Dispenser
SA05	RBA Jumbo Toilet Dispenser B2890
SA06	RBA Sanitary Mounted Napkin Disposal B270
SA11	RBA Full Height Basin RBA8881-100
SA12	Plumbing Fixtures Urinal
SA13	Toilet Plumbing Fixtures WC
SA14	Toilet Handicaped Grab Bars


Revisions			Do not scale drawings. Use figured dimensions only. Check and verify levels and dimensions on site prior to commencement of any work, the preparation of drawings or the fabrication of components. This drawing is copyright and can not be reproduced without written consent.	Client Sue & Andy Baker	True North	Billy Blue College of Design 46-52 Mountain Street, Ultimo, NSW 2007, Australia +61 (0)2 9999 9999	Project IDC302A 48 Baywater Drive, Wentworth Point, NSW, 2127 Project number 20,001	Drawing Title Bar perspective	Drawing Status PRESENTATION DRAWINGS NOT FOR CONSTRUCTION	Scale Drawing No Issue A10 01
No	Date	Description	Ver. App'd Approver							
01	21.08.21	PRESENTATION DRAWINGS								Date 21.08.21 Drawn by MB

Le Velo



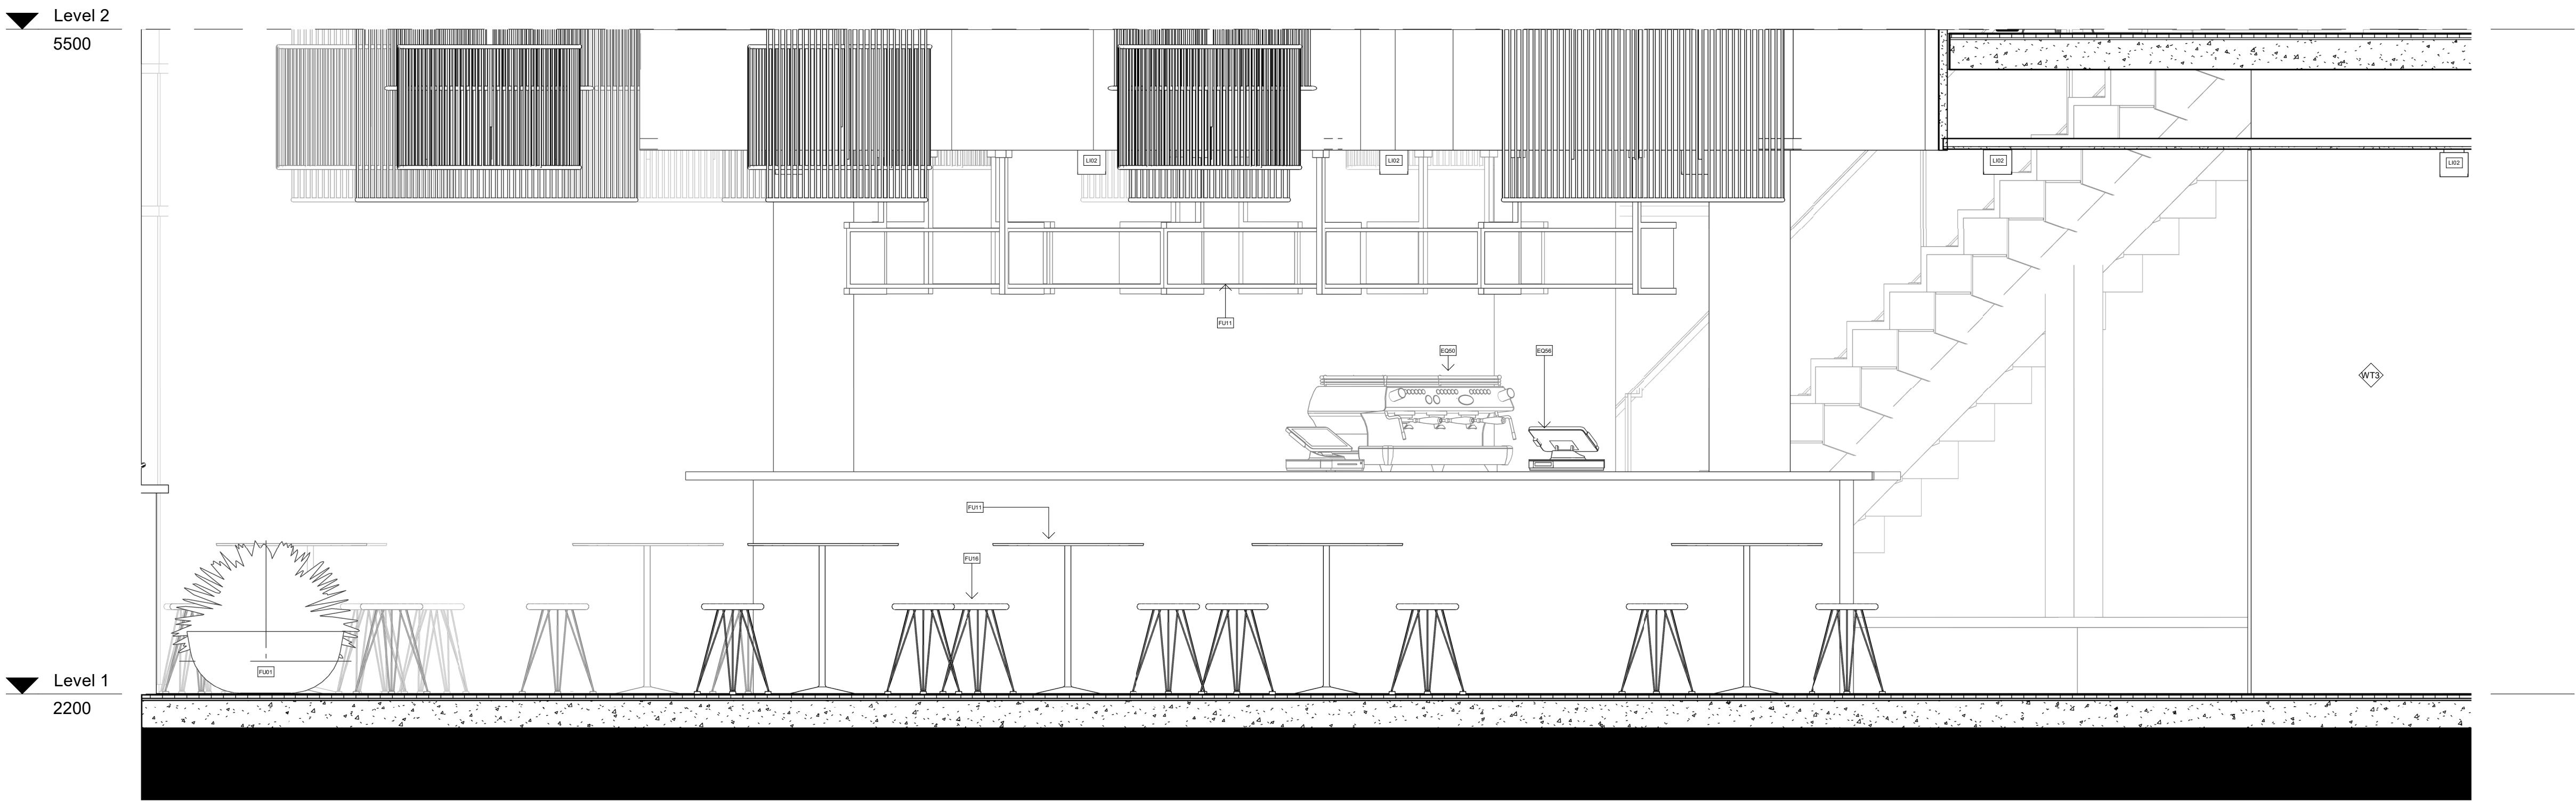

1 Bar Elevation 1
1 : 20

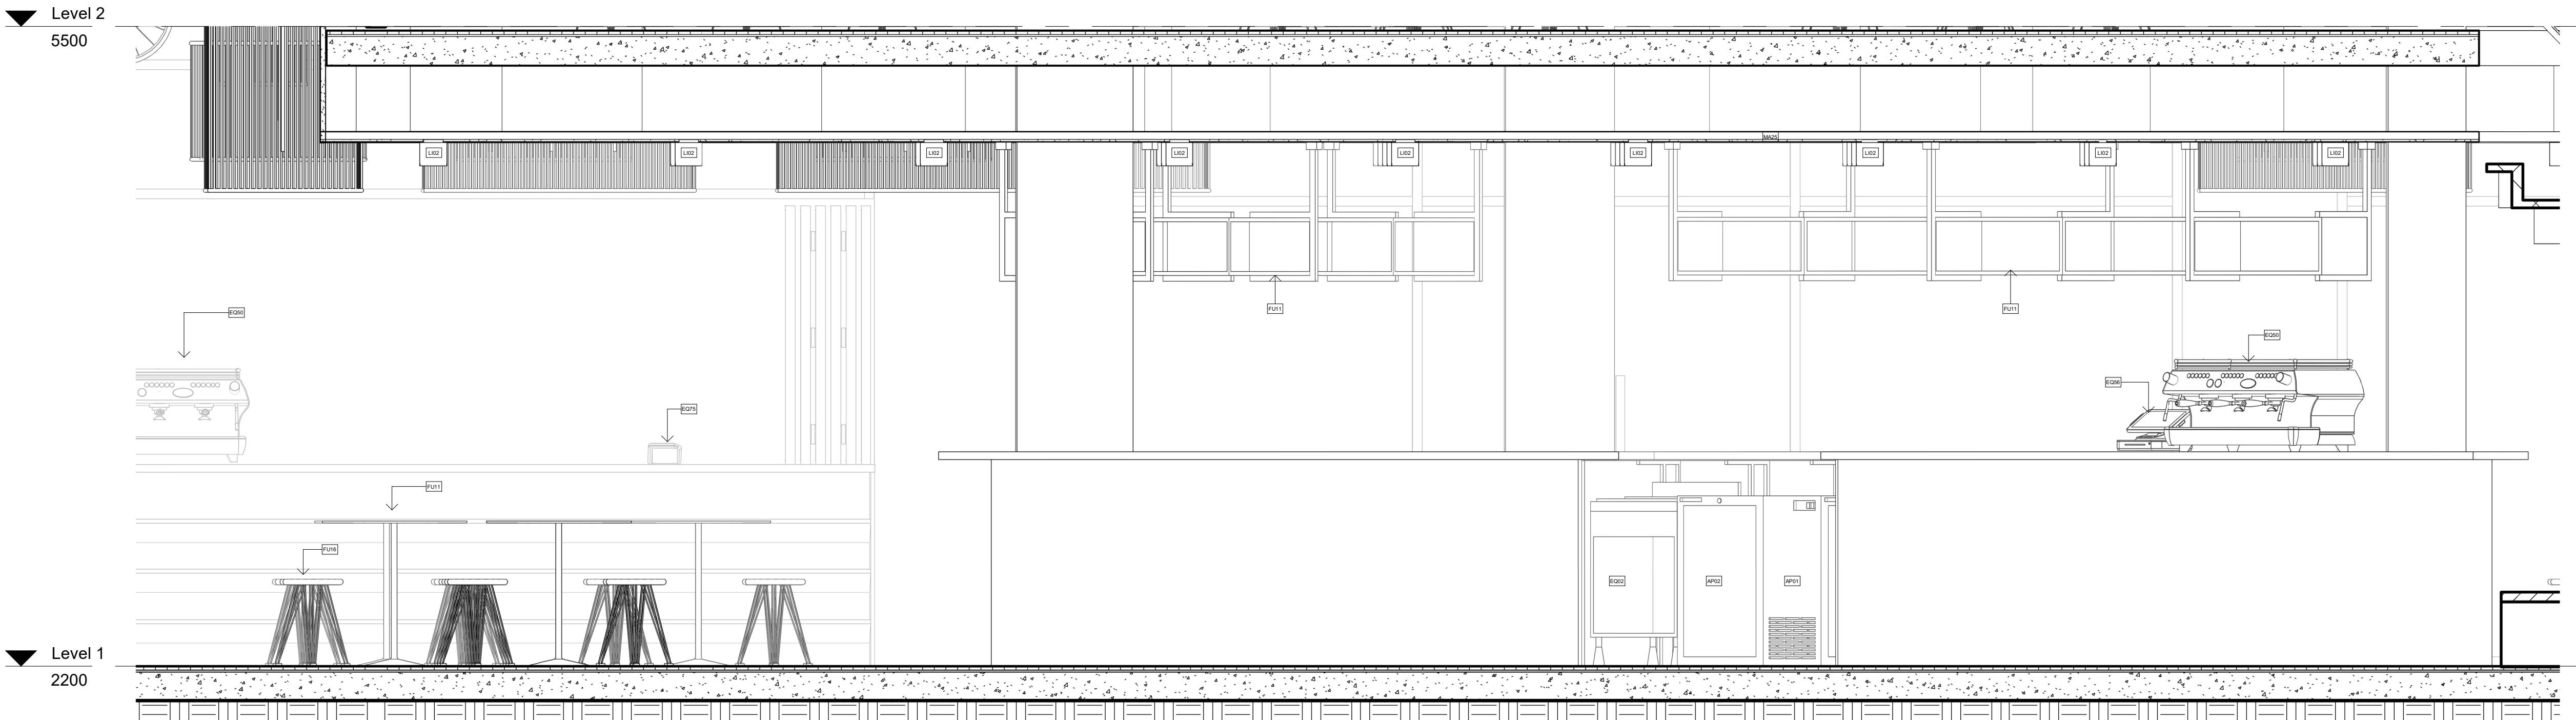

2 Bar Elevation 2
1 : 20

LEGEND

Cut Material			
	Existing Structure		Concrete
	Plaster Board		Steel
	Tiles		Glass

Wall Types	
WT1	2mm glue + 70mm Recycled Brick
WT2	2mm glue + 70mm Recycled Brick + 2mm Artwork finish
WT3	Timber stud wall 100 x 50 w/ 13mm FC + 2mm glue + 3mm Micro topping finish to each side
WT4	13mm FC + 2mm glue + 3mm Micro topping finish
WT5	Timber stud wall 100 x 50 w/ 13mm FC + 2mm glue + 3mm Micro topping finish

Door Types	
DO1	Flush Door 810mm x 2110mm
DO2	Toilet cubicle Door 650mm x 2110mm
DO3	Flush Double Doors 1510mm x 2110mm

Abbreviations			
AP	Appliances	MA	Material
D	Door	PS	Plaster Board
DA	Development Application	SA	Sanitary
EQ	Equipment	SS	Stainless Steel
FU	Furniture	WT	Wall Type
		W/	With



Tag Legend	
MA01	Wall Paint White by Porters paints
MA02	Wall Concrete by Hanson
MA03	Wall Tiles by Beaumont tiles
MA04	Wall Bricks by Austral bricks
MA05	Bar Glass by Express Glass
MA06	Bar Cement slab by Bunnings
MA11	Stairs Steel by Pacific Metal work
MA12	Bathroom Walls
MA16	Wall Paint Grey by porters paints
MA18	Glass by Express glass
MA19	Female/Male Sign
MA20	Concrete Slab Table
MA21	Aluminum Seat Swing
MA22	Steel Shipping Container
MA23	Repair Stand
MA24	Pot Plant
MA25	Ceiling Plant by Porters Paints
AP01	IMC Refrigeration Module B16704S
AP02	IMC Glass Door Module B16700S
AP05	IMC Wine Chiller Module B16703S
AP08	Waldorf Pasta Cooker PC8140G
AP09	Waldorf Kitchen Benchtops BT8600CB
AP12	Waldorf 8820 series8 Burners Double Static Oven RN8820G
AP13	Waldorf Refrigerator RN8100GRB
AP16	Waldorf Chargrill CH8900G-LS
AP18	Waldorf Gas fryer FN8120G
EQ02	IMC Bar Ice Chest BZ54060
EQ06	IMC Shelf Drainer BZ38100
EQ08	IMC Perforated Worktop BZ69100
EQ09	IMC Beer Station BZ34060
EQ11	IMC Basket Rack BZ23050
EQ13	IMC Double Sink BZ52100
EQ14	IMC Worktop Unit BZ50060
EQ18	IMC Storage Cupboard BZ61060
EQ20	IMC Three Drawer Unit BZ64040
EQ41	Waldorf BenchTop BT8450LS
EQ42	Ryno 600Series Bench SB6150A
EQ44	Street Furniture Bin 80LLB4
EQ45	Street Furniture Semi Hoop Bike Stand BST03
EQ56	IPS Paypoint Electronic Cash Register
EQ57	CommBank TapPay Contactless Payment
EQ50	LaMarzocco Coffee Machine FB80
EQ61	Toyko Bike SS
EQ62	Dog Bowl
EQ63	Bike RepairStand
EQ64	Mesh Gallery Partitions
EQ65	Outdoor Swing Seating
EQ67	Overhead Shelving Bar
EQ68	Retail Bar Table
FU10	Tail Linear Table & Benches
FU16	Style craft Spike Low Stool H450mm
FU11	Arper Dizzie Side Table Black
FU12	Take Away Counter
SA01	Dyson Hand Dryer Unit BZ50
SA03	Centura Recessed Soap Dispenser
SA05	RBA Jumbo Toilet Dispenser B2890
SA06	RBA Sanitary Mounted Napkin Disposal B270
SA11	RBA Full Height Basin RBA8881-100
SA12	Plumbing Fixtures Urinal
SA13	Toilet Plumbing Fixtures WC
SA14	Toilet Handicaped Grab Bars



Revisions			Do not scale drawings. Use figured dimensions only. Check and verify levels and dimensions on site prior to commencement of any work, the preparation of drawings or the fabrication of components. This drawing is copyright and can not be reproduced without written consent.	Client Sue & Andy Baker	True North	Billy Blue College of Design 46-52 Mountain Street, Ultimo, NSW 2007, Australia +61 (0)2 9999 9999	Project IDC302A 48 Baywater Drive, Wentworth Point, NSW, 2127 Project number 20,001	Drawing Title Bar Elevation	Scale 1:20	Drawing No A11	Issue 01
No	Date	Description	Ver. App'd Approver								
01	21.08.21	PRESENTATION DRAWINGS						PRESENTATION DRAWINGS NOT FOR CONSTRUCTION	Date 21.08.21	Drawn by MB	

Le Velo



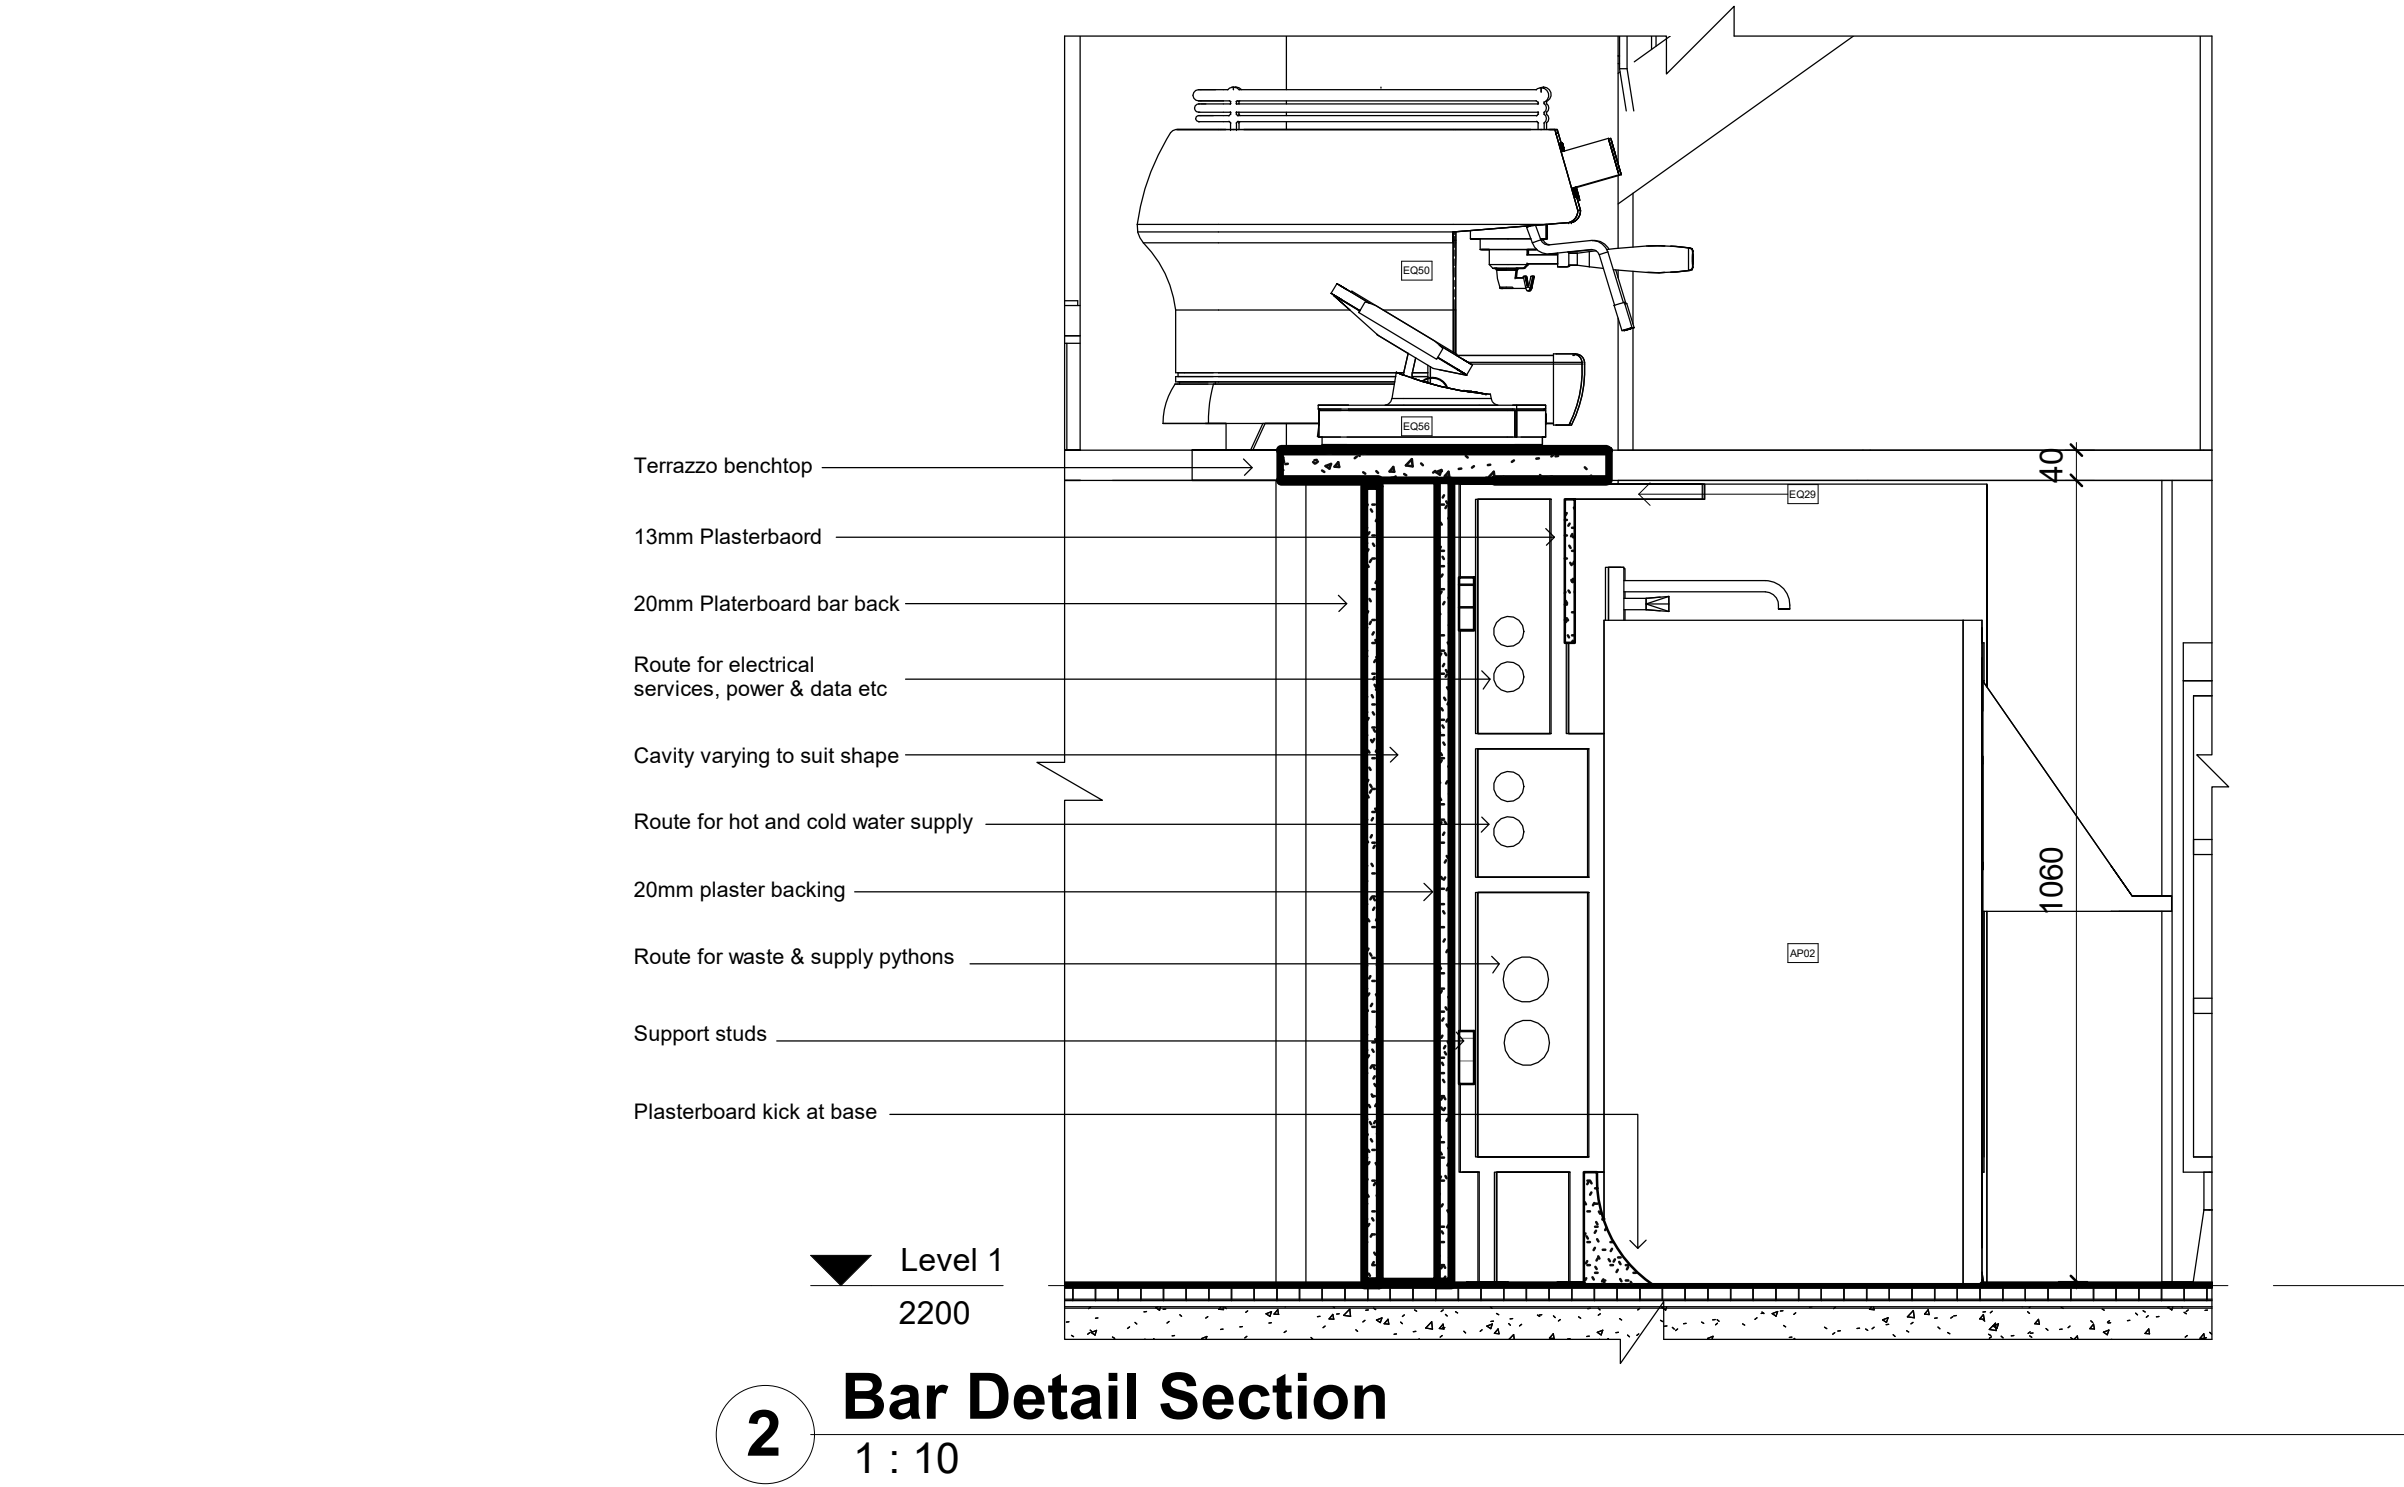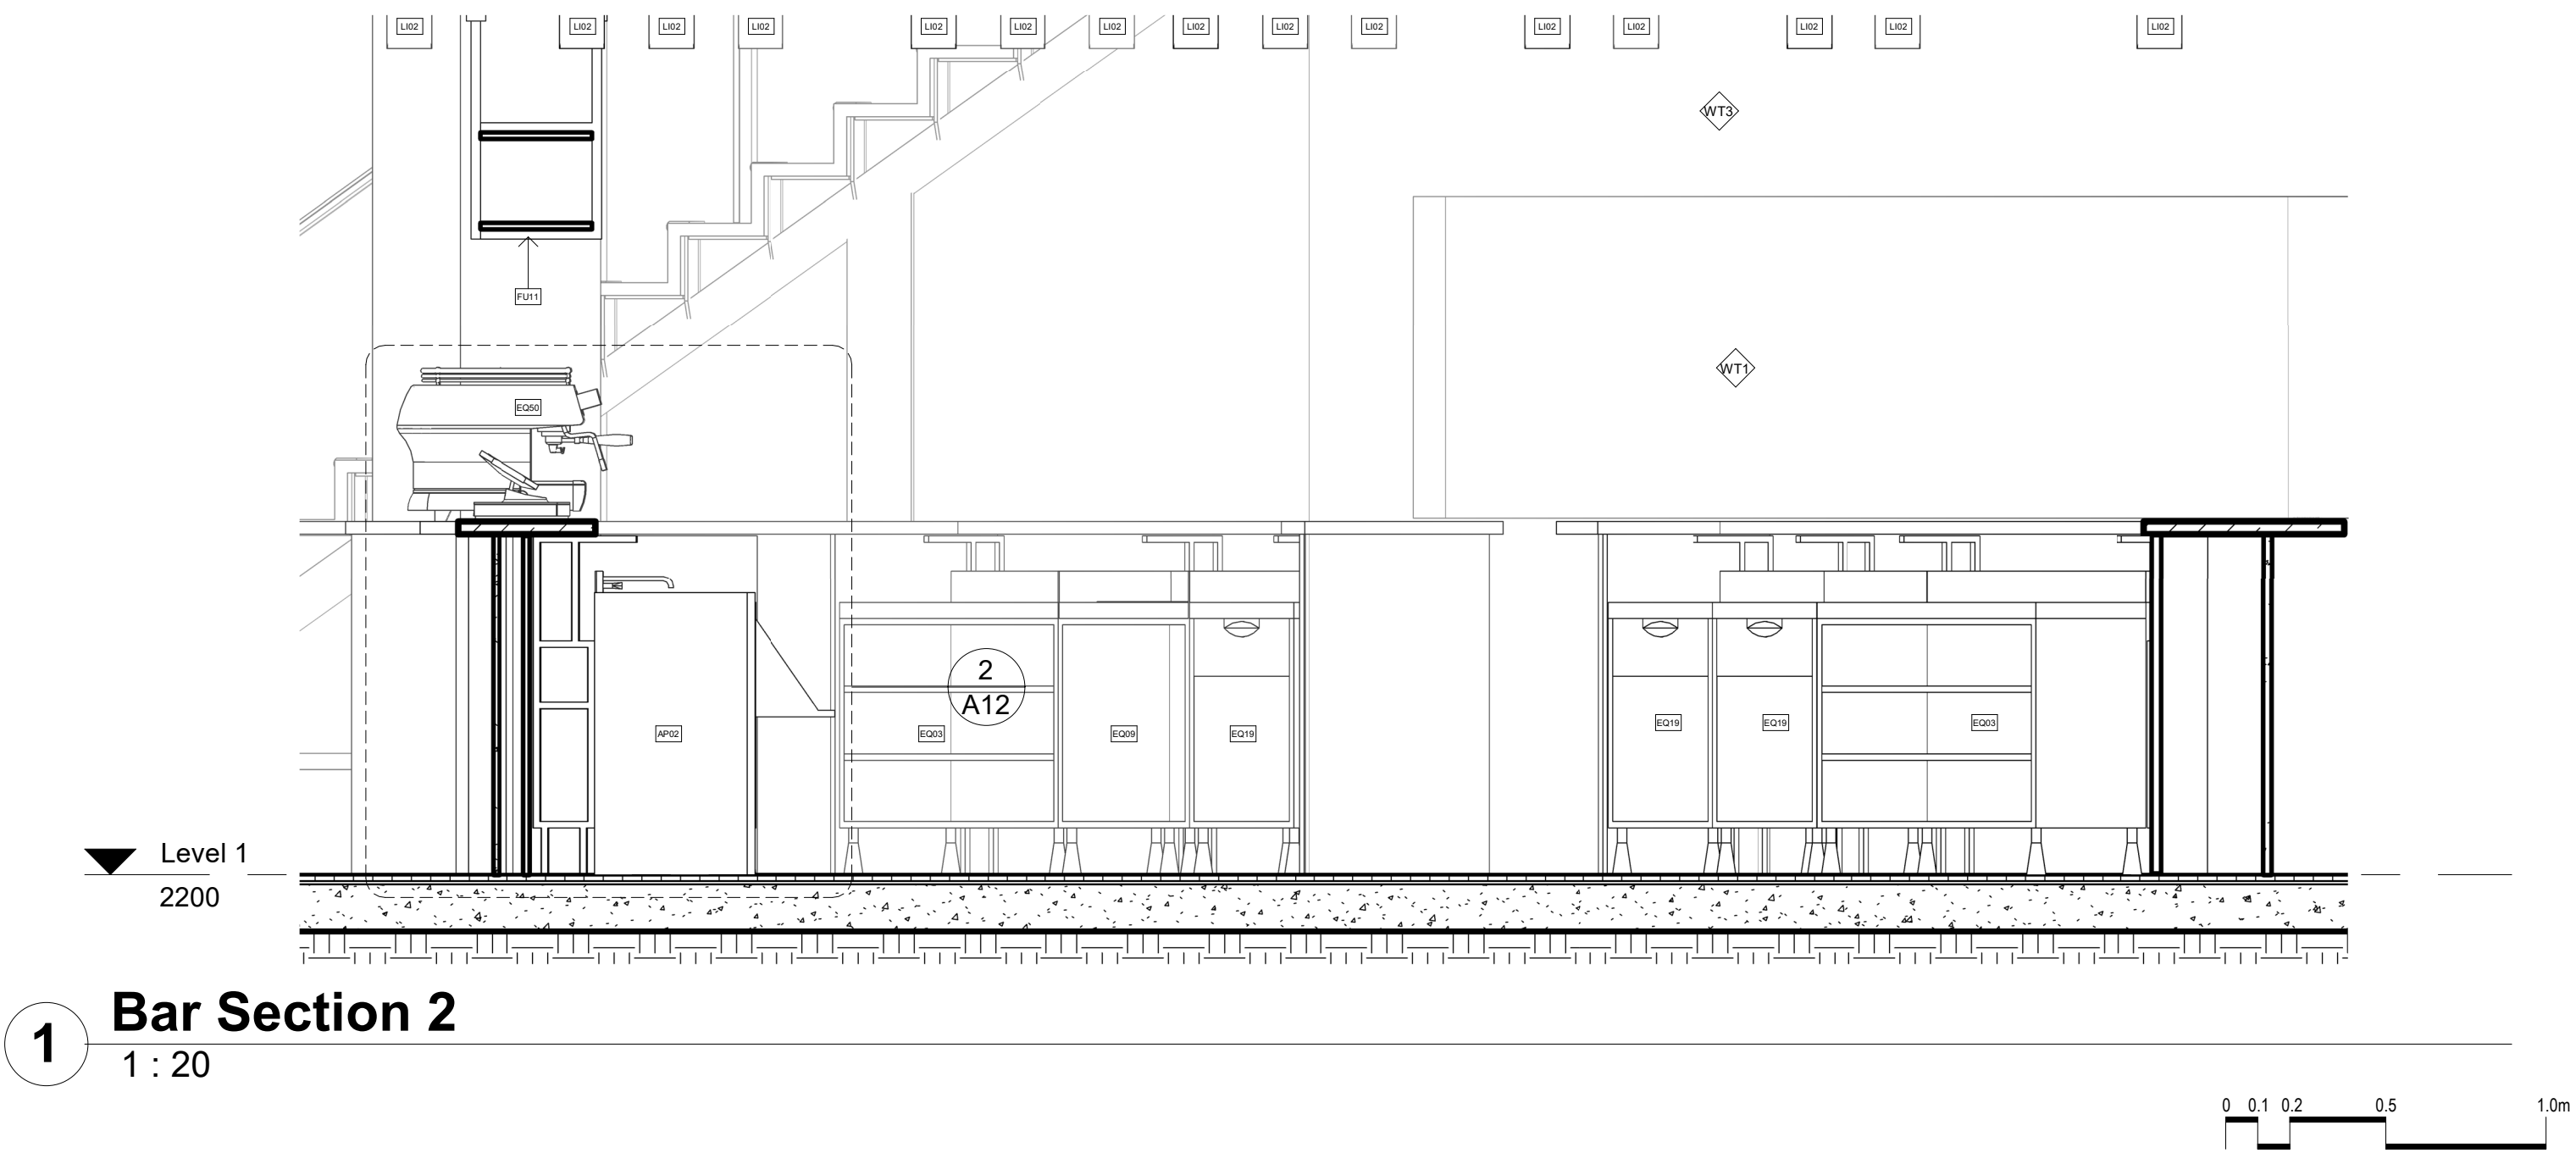

LEGEND

Cut Material			
	Existing Structure		Concrete
	Plaster Board		Steel
	Tiles		Glass


Wall Types	
	2mm glue + 70mm Recycled Brick
	2mm glue + 70mm Recycled Brick + 2mm Artwork finish
	Timber stud wall 100 x 50 w/ 13mm FC + 2mm glue + 3mm Micro topping finish to each side
	13mm FC + 2mm glue + 3mm Micro topping finish
	Timber stud wall 100 x 50 w/ 13mm FC + 2mm glue + 3mm Micro topping finish

Door Types	
	Flush Door 810mm x 2110mm
	Toilet cubicle Door 650mm x 2110mm
	Flush Double Doors 1510mm x 2110mm

Abbreviations			
AP	Appliances	MA	Material
D	Door	PB	Plaster Board
DA	Development Application	SA	Sanitary
EQ	Equipment	SS	Stainless Steel
FU	Furniture	WT	Wall Type
		W/	With

Tag Legend	
MA01	Wall Paint White by Porters paints
MA02	Wall Concrete by Hanson
MA03	Wall Tiles by Beaumont tiles
MA04	Wall Bricks by Austral bricks
MA05	Bar Glass by Express Glass
MA06	Bar Cement slab by Bunnings
MA11	Stairs Steel by Pacific Metal work
MA12	Bathroom Walls
MA16	Wall Paint Grey by porters paints
MA18	Glass by Express glass
MA19	Female/Male Sign
MA20	Concrete Slab Table
MA21	Aluminum Seat Swing
MA22	Steel Shipping Container
MA23	Repair Stand
MA24	Pot Plant
MA25	Ceiling Plant by Porters Paints
AP01	IMC Refrigeration Module B16704S
AP02	IMC Glass Door Module B16700S
AP05	IMC Wine Chiller Module B16703S
AP08	Waldorf Pasta Cooker PC8140G
AP09	Waldorf Kitchen Benchtops BT8600CB
AP12	Waldorf 8820 series8 Burners Double Static Oven RN8820G
AP13	Waldorf Refridgerator RN8100GRB
AP16	Waldorf Chargrill CH8900G-LS
AP18	Waldorf Gas fryer FN8120G
EQ02	IMC Bar Ice Chest BZ54060
EQ06	IMC Shelf Drainer BZ38100
EQ08	IMC Perforated Worktop BZ69100
EQ09	IMC Beer Station BZ34060
EQ11	IMC Basket Rack BZ23050
EQ13	IMC Double Sink BZ52100
EQ14	IMC Worktop Unit BZ50060
EQ18	IMC Storage Cupboard BZ61060
EQ20	IMC Three Drawer Unit BZ64040
EQ41	Waldorf BenchTop BT8450LS
EQ42	Ryno 600Series Bench S96150A
EQ44	Street Furniture Bin 80LLB4
EQ45	Street Furniture Semi Hoop Bike Stand
BST03	
EQ56	IPS Paypoint Electronic Cash Register
EQ57	CommBank TapPay Contacless Payment
EQ50	LaMarzococ Coffee Machine FB80
EQ61	Toyko Bike SS
EQ62	Dog Bowl
EQ63	Bike RepairStand
EQ64	Mesh Gallery Partitions
EQ65	Outdoor Swing Seating
EQ67	Overhead Shelving Bar
EQ68	Retail Bar Table
FU10	Tait Linear Table & Benches
FU16	Style craft Spike Low Stool H450mm
FU11	Arper Dizzie Side Table Black
FU12	Take Away Counter
SA01	Dyson Hand Dryer Unit BZ50
SA03	Contura Recessed Soap Dispenser
SA05	RBA Jumbo Toilet Dispenser B2890
SA06	RBA Sanitary Mounted Napkin Disposal
B270	
SA11	RBA Full Height Basin RBA8881-100
SA12	Plumbing Fixtures Urinal
SA13	Toilet Plumbing Fixtures WC
SA14	Toilet Handicaped Grab Bars

Revisions			Do not scale drawings. Use figured dimensions only. Check and verify levels and dimensions on site prior to commencement of any work, the preparation of drawings or the fabrication of components. This drawing is copyright and can not be reproduced without written consent.	Client Sue & Andy Baker	True North	Billy Blue College of Design 46-52 Mountain Street, Ultimo, NSW 2007, Australia +61 (0)2 9999 9999	Project IDC302A 48 Baywater Drive, Wentworth Point, NSW, 2127 Project number 20,001	Drawing Title Bar Detail Section	Scale A12	Drawing No 01	Issue
No	Date	Description	Ver. App'd Approver								
01	21.08.21	PRESENTATION DRAWINGS									
			Drawing Status PRESENTATION DRAWINGS NOT FOR CONSTRUCTION								
			Date 21.08.21								
			Drawn by Author								

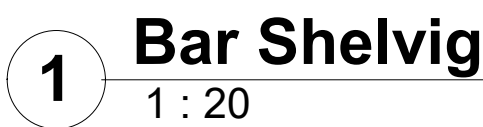

Steel brackets

Accrete rectangle shelves

2 Bar Shelving Detail



Cut Material

	Existing Structure		Concrete
	Plaster Board		Steel
	Tiles		Glass


WT1	2mm glue + 70mm Recycled Brick
WT2	2mm glue + 70mm Recycled Brick + 2mm Artwork finish
WT3	Timber stud wall 100 x 50 w/ 13mm FC + 2mm glue + 3mm Micro topping finish to each side
WT4	13mm FC + 2mm glue + 3mm Micro topping finish
WT5	Timber stud wall 100 x 50 w/ 13mm FC + 2mm glue + 3mm Micro topping finish

DO1	Flush Door 810mm x 2110mm
DO2	Toilet cubicle Door 650mm x 2110mm
DO3	Flush Double Doors 1510mm x 2110mm



AP	Appliances	MA	Material
D	Door	PB	Plaster Board
DA	Development Application	SS	Sanitary
EQ	Equipment	SS	Stainless Steel
FU	Furniture	WT	Wall Type
		W/	With

MA01	Wall Paint White by Porters paints
MA02	Wall Concrete by Hanson
MA03	Wall Tiles by Beaumont tiles
MA04	Wall Bricks by Austral bricks
MA05	Bar Glass by Express Glass
MA06	Bar Cement slab by Bunnings
MA11	Stairs Steel by Pacific Metal work
MA12	Bathroom Walls
MA16	Wall Paint Grey by porters paints
MA18	Glass by Express glass
MA19	Female/Male Sign
MA20	Concrete Slab Table
MA21	Aluminum Seat Swing
MA22	Steel Shipping Container
MA23	Repair Stand
MA24	Pot Plant
MA25	Ceiling Plant by Porters Paints
AP01	IMC Refrigeration Module B16704S
AP02	IMC Glass Door Module B16700S
AP05	IMC Wine Chiller Module B16703S
AP08	Waldorf Pasta Cooker PC8140G
AP10	Waldorf Chiller Top TB3450LS
AP12	Waldorf 8820 series8 Burners Double Static Oven RN8820G
AP13	Waldorf Refrigerator RN8100GRB
AP16	Waldorf Charrigri CH8900G-LS
AP18	Waldorf Gas fryer RN8120G
EQ02	IMC Bar Ice Chest BZ5406G
EQ06	IMC Shelf Drawer BZ38100
EQ07	IMC Perfomance Bench BZ69100
EQ09	IMC Beer Station BZ3406G
EQ11	IMC Basket Rack BZ23050
EQ13	IMC Double Sink BZ52100
EQ14	IMC Worktop Unit BZ50060
EQ18	IMC Storage Cupboard BZ81060
EQ20	IMC Three Drawer Unit BZ64040
EQ41	Waldorf Bench Top TB3450LS
EQ42	Ryno 600Series Bench SB6150A
EQ44	Street Furniture Bin 80LLB4
EQ45	Street Furniture Semi Hoop Bike Stand
BS703	
EQ56	IPS Payment Electronic Cash Register
EQ57	CommBank TapPay Contactless Payment
EQ50	LaMarzocco Coffee Machine FB80
EQ51	Tokyo Bike SS
EQ60	Dog Bowl
EQ63	Bike RepairStand
EQ64	Mesh Gallery Partitions
EQ65	Outdoor Swing Seating
EQ67	Overhead Shelving Bar
EQ68	Retail Bar Table
EQ69	Tail Linear Bar & Benches
FU10	Style craft Spigot Bow Steel H450mm
FU11	Arper Dazzle Side Table Black
FU12	Take Away Counter
SA01	Dyson Hand Dryer Unit BZ50
SA03	Centura Recycled Soap Dispenser
SA05	RBA Jambo Toilet Dispenser B2890
SA06	RBA Sanitary Mounted Napkin Disposal
BZ71	
SA11	RBA Full Height Basin RBA8881-100
SA12	Plumbing Fixtures Urinal
SA13	Toilet Plumbing Fixtures WC
SA14	Toilet Handicaped Bar WCs


A1

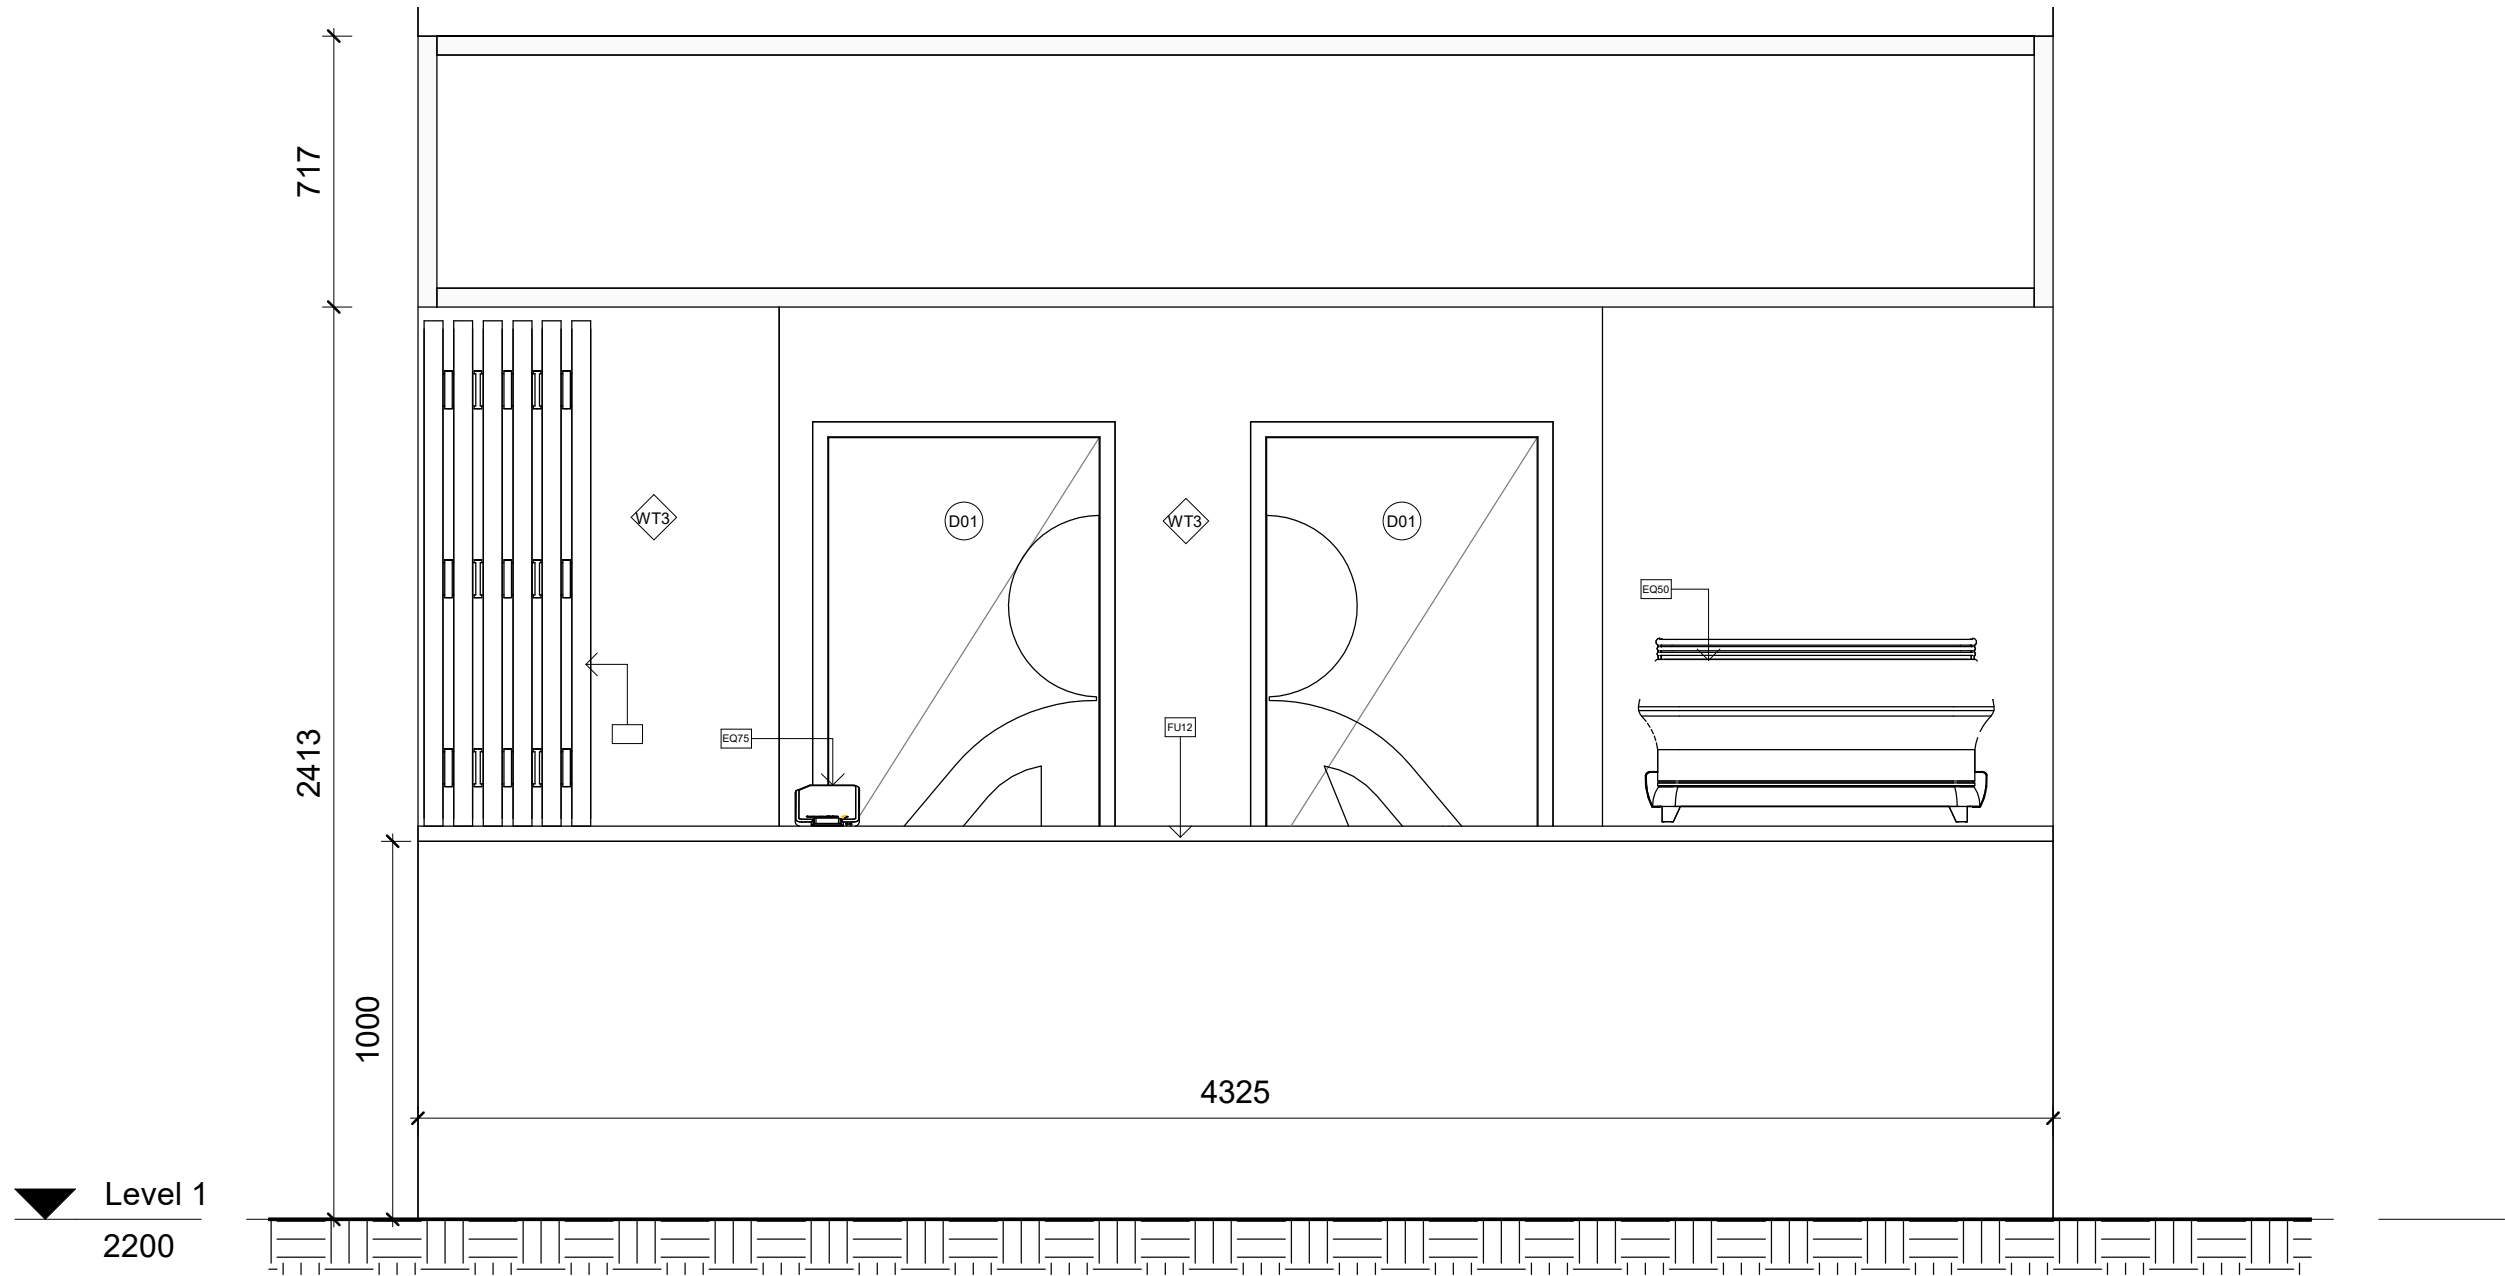

1 Take-Away Bar Section
1 : 20

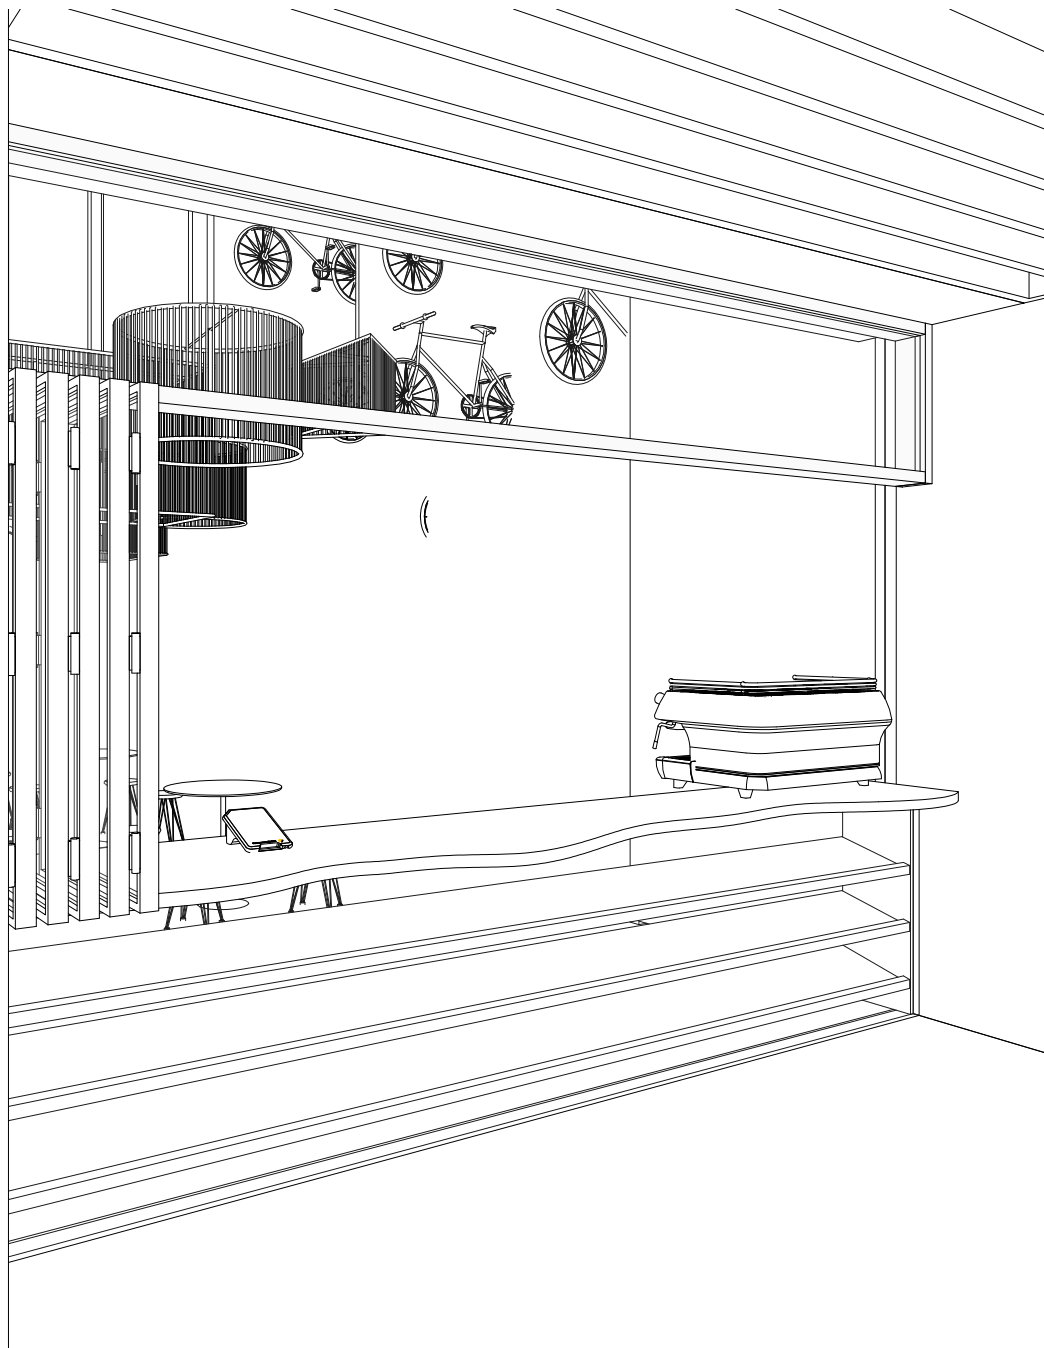 

2 Take-Away Bar Front

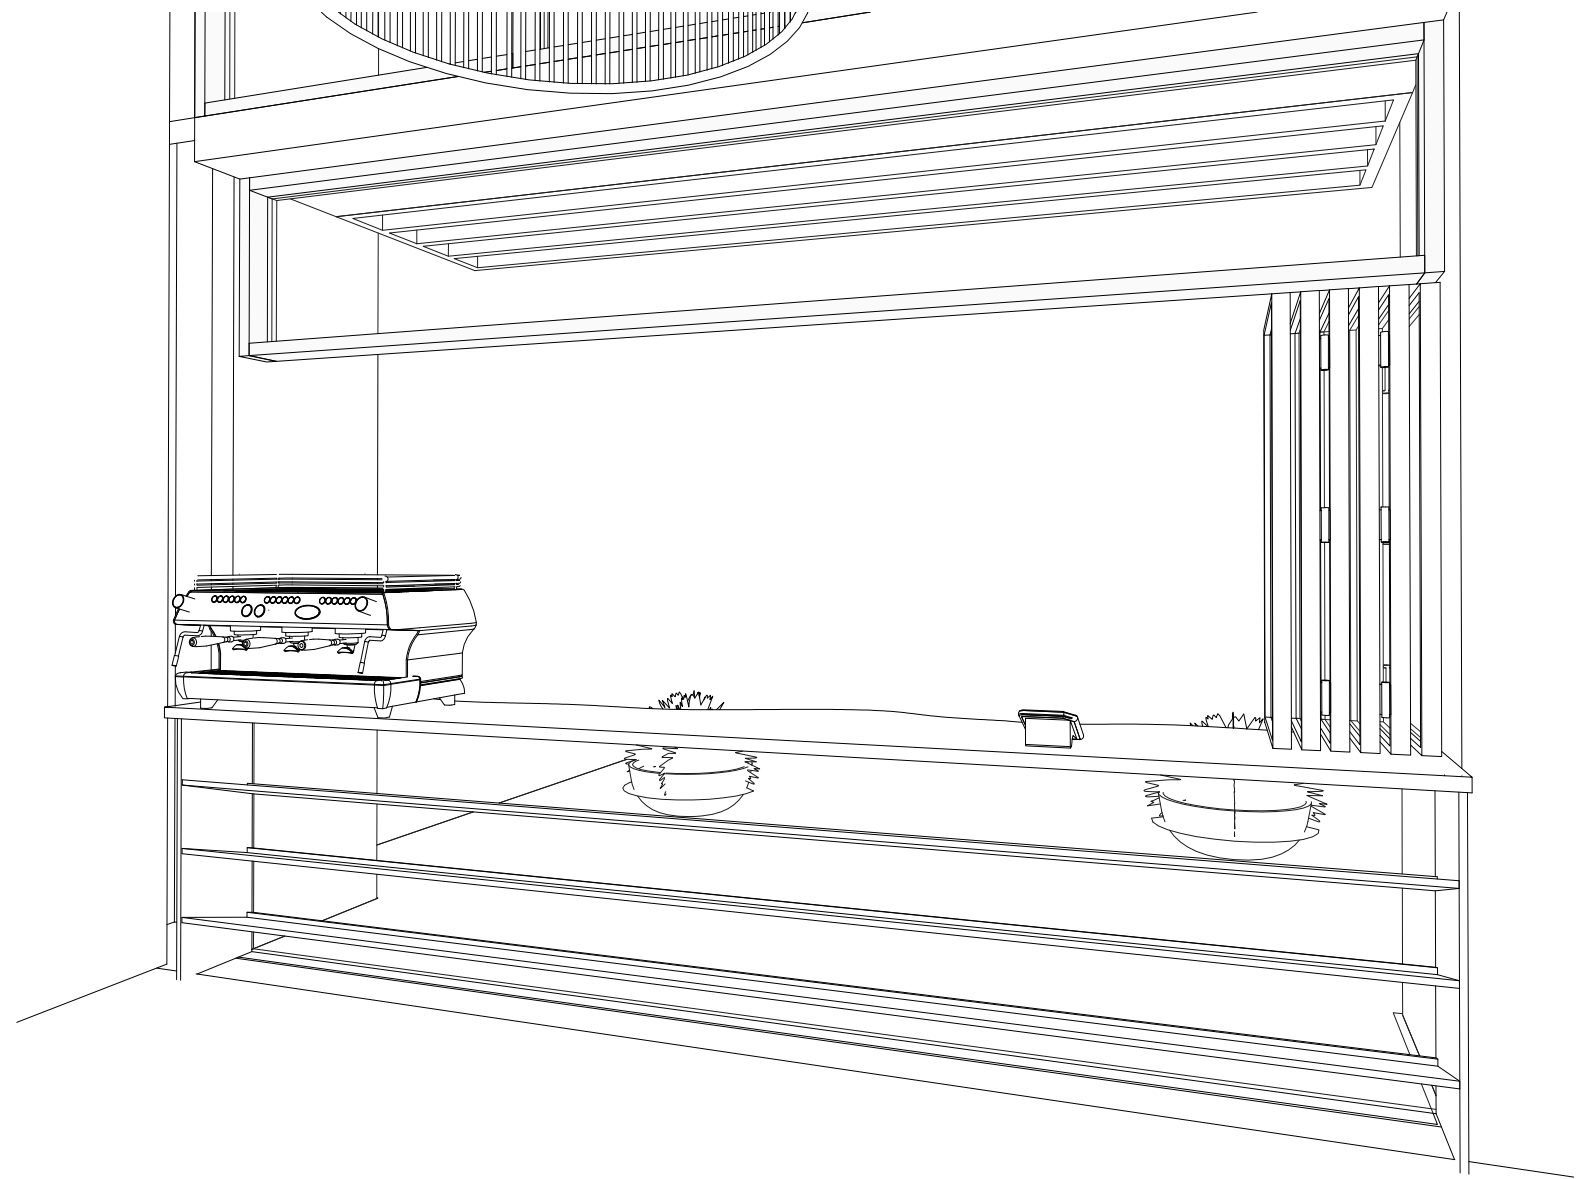

3 Take-Away Bar Back

LEGEND

Cut Material			
	Existing Structure		Concrete
	Plaster Board		Steel
	Tiles		Glass

Wall Types	
WT1	2mm glue + 70mm Recycled Brick
WT2	2mm glue + 70mm Recycled Brick + 2mm Artwork finish
WT3	Timber stud wall 100 x 50 w/ 13mm FC + 2mm glue + 3mm Micro topping finish to each side
WT4	13mm FC + 2mm glue + 3mm Micro topping finish
WT5	Timber stud wall 100 x 50 w/ 13mm FC + 2mm glue + 3mm Micro topping finish

Door Types	
DO1	Flush Door 810mm x 2110mm
DO2	Toilet cubicle Door 650mm x 2110mm
DO3	Flush Double Doors 1510mm x 2110mm

Abbreviations			
AP	Appliances	MA	Material
D	Door	PB	Plaster Board
DA	Development Application	SA	Sanitary
EQ	Equipment	SS	Stainless Steel
FU	Furniture	WT	Wall Type
		W/	With

Tag Legend	
MA01	Wall Paint White by Porters paints
MA02	Wall Concrete by Hanson
MA03	Wall Tiles by Beaumont tiles
MA04	Wall Bricks by Austral bricks
MA05	Bar Glass by Express Glass
MA06	Bar Cement slab by Bunnings
MA11	Stairs Steel by Pacific Metal work
MA12	Bathroom Walls
MA16	Wall Paint Grey by porters paints
MA18	Glass by Express glass
MA19	Female/Male Sign
MA20	Concrete Slab Table
MA21	Aluminum Seat Swing
MA22	Steel Shipping Container
MA23	Repair Stand
MA24	Pot Plant
MA25	Ceiling Plant by Porters Paints
AP01	IMC Refrigeration Module B16704S
AP02	IMC Glass Door Module B16700S
AP05	IMC Wine Chiller Module B16703S
AP08	Waldorf Pasta Cooker PC8140G
AP09	Waldorf Kitchen Benchtops BT8600CB
AP12	Waldorf 8820 series8 Burners Double Static Oven RN8820G
AP13	Waldorf Refrigerator RN8100GRB
AP16	Waldorf Charrill CH8900G-LS
AP18	Waldorf Gas fryer FN8120G
EQ02	IMC Bar Ice Chest BZ54060
EQ06	IMC Shelf Drainer BZ38100
EQ08	IMC Perforated Worktop BZ69100
EQ09	IMC Beer Station BZ34060
EQ11	IMC Basket Rack BZ23050
EQ13	IMC Double Sink BZ52100
EQ14	IMC Worktop Unit BZ50060
EQ18	IMC Storage Cupboard BZ61060
EQ20	IMC Three Drawer Unit BZ64040
EQ41	Waldorf BenchTop BT8450LS
EQ42	Ryno 600Series Bench SB6150A
EQ44	Street Furniture Bin 80LLB4
EQ45	Street Furniture Semi Hoop Bike Stand BST03
EQ56	IPS Paypoint Electronic Cash Register
EQ57	CommBank TapPay Contacless Payment
EQ50	LaMarzococ Coffee Machine FB80
EQ61	Toyko Bike SS
EQ62	Dog Bowl
EQ63	Bike RepairStand
EQ64	Mesh Gallery Partitions
EQ65	Outdoor Swing Seating
EQ67	Overhead Shelving Bar
EQ68	Retail Bar Table
FU10	Tait Linear Table & Benches
FU16	Style craft Spike Low Stool H450mm
FU11	Arper Dizzie Side Table Black
FU12	Take Away Counter
SA01	Dyson Hand Dryer Unit BZ50
SA03	Contura Recessed Soap Dispenser
SA05	RBA Jumbo Toilet Dispenser BZ690
SA06	RBA Sanitary Mounted Napkin Disposal B270
SA11	RBA Full Height Basin RBA8881-100
SA12	Plumbing Fixtures Urinal
SA13	Toilet Plumbing Fixtures WC
SA14	Toilet Handicapped Grab Bars

Revisions		
No	Date	Description
01	21.08.21	PRESENTATION DRAWINGS

Do not scale drawings. Use figured dimensions only. Check and verify levels and dimensions on site prior to commencement of any work, the preparation of drawings or the fabrication of components.
This drawing is copyright and can not be reproduced without written consent.

Client
Sue & Andy Baker

Le Velo

True North

Billy Blue College of Design
46-52 Mountain Street, Ultimo, NSW 2007, Australia
+61 (0)2 9999 9999



Project
IDC302A
48 Baywater Drive, Wentworth Point, NSW, 2127
Project number
20,001

Drawing Title
Take-Away Bar
Drawing Status
PRESENTATION DRAWINGS
NOT FOR CONSTRUCTION

Scale
Drawing No
Issue
Date
21.08.21
Drawn by
MB

LEGEND

Cut Material

	Existing Structure		Concrete
	Plaster Board		Steel
	Tiles		Glass

Wall Types

	WT1	2mm glue + 70mm Recycled Brick
	WT2	2mm glue + 70mm Recycled Brick + 2mm Artwork finish
	WT3	Timber stud wall 100 x 50 w/ 13mm FC + 2mm glue + 3mm Micro topping finish to each side
	WT4	13mm FC + 2mm glue + 3mm Micro topping finish
	WT5	Timber stud wall 100 x 50 w/ 13mm FC + 2mm glue + 3mm Micro topping finish

Door Types

	DO1	Flush Door 810mm x 2110mm
	DO2	Toilet cubicle Door 650mm x 2110mm
	DO3	Flush Double Doors 1510mm x 2110mm

Abbreviations


AP	Appliances	MA	Material
D	Door	PB	Plaster Board
DA	Development Application	SA	Sanitary
EQ	Equipment	SS	Stainless Steel
FU	Furniture	WT	Wall Type
		W/	With

Tag Legend


MA01	Wall Paint White by Porters paints
MA02	Wall Concrete by Hanson
MA03	Wall Tiles by Beaumont tiles
MA04	Wall Bricks by Austral bricks
MA05	Bar Glass by Express Glass
MA06	Bar Cement slab by Bunnings
MA11	Stairs Steel by Pacific Metal work
MA12	Bathroom Walls
MA16	Wall Paint Grey by porters paints
MA18	Glass by Express glass
MA19	Female/Male Sign
MA20	Concrete Slab Table
MA21	Aluminum Seat Swing
MA22	Steel Shipping Container
MA23	Repair Stand
MA24	Pot Plant
MA25	Ceiling Plant by Porters Paints
AP01	IMC Refrigeration Module B16704S
AP02	IMC Glass Door Module B16700S
AP05	IMC Wine Chiller Module B16703S
AP08	Waldorf Pasta Cooker PC8140G
AP09	Waldorf Kitchen Benchtops BT8600CB
AP12	Waldorf 8620 series8 Burners Double Static Oven RN8920C
AP13	Waldorf Refridgerator RN8100GRB
AP16	Waldorf Chargrill CH8900G-LS
AP18	Waldorf Gas fryer FN8120G
EQ02	IMC Bar Ice Chest BZ54060
EQ06	IMC Shelf Drainer BZ38100
EQ08	IMC Perforated Worktop BZ69100
EQ09	IMC Beer Station BZ34060
EQ11	IMC Basket Rack BZ23050
EQ13	IMC Double Sink BZ52100
EQ14	IMC Worktop Unit BZ50060
EQ18	IMC Storage Cupboard BZ61060
EQ20	IMC Three Drawer Unit BZ64040
EQ41	Waldorf BenchTop BT8450LS
EQ42	Ryno 600Series Bench SB6150A
EQ44	Street Furniture Bin 80LLB4
EQ45	Street Furniture Semi Hoop Bike Stand BST03
EQ56	IPS Paypoint Electronic Cash Register
EQ57	CommBank TapPay Contactless Payment
EQ50	LaMarzococc Coffee Machine FB80
EQ61	Toyko Bike SS
EQ62	Dog Bowl
EQ63	Bike RepairStand
EQ64	Mesh Gallery Partitions
EQ65	Outdoor Swing Seating
EQ67	Overhead Shelving Bar
EQ68	Retail Bar Table
FU10	Tait Linear Table & Benches
FU16	Style craft Spike Low Stool H450mm
FU11	Arper Dizzie Side Table Black
FU12	Take Away Counter
SA01	Dyson Hand Dryer Unit BZ50
SA03	Contura Recessed Soap Dispenser
SA05	RBA Jumbo Toilet Dispenser B2890
SA06	RBA Sanitary Mounted Napkin Disposal B270
SA11	RBA Full Height Basin RBA8881-100
SA12	Plumbing Fixtures Urinal
SA13	Toilet Plumbing Fixtures WC
SA14	Toilet Handicaped Grab Bars




3 Staircase View 1

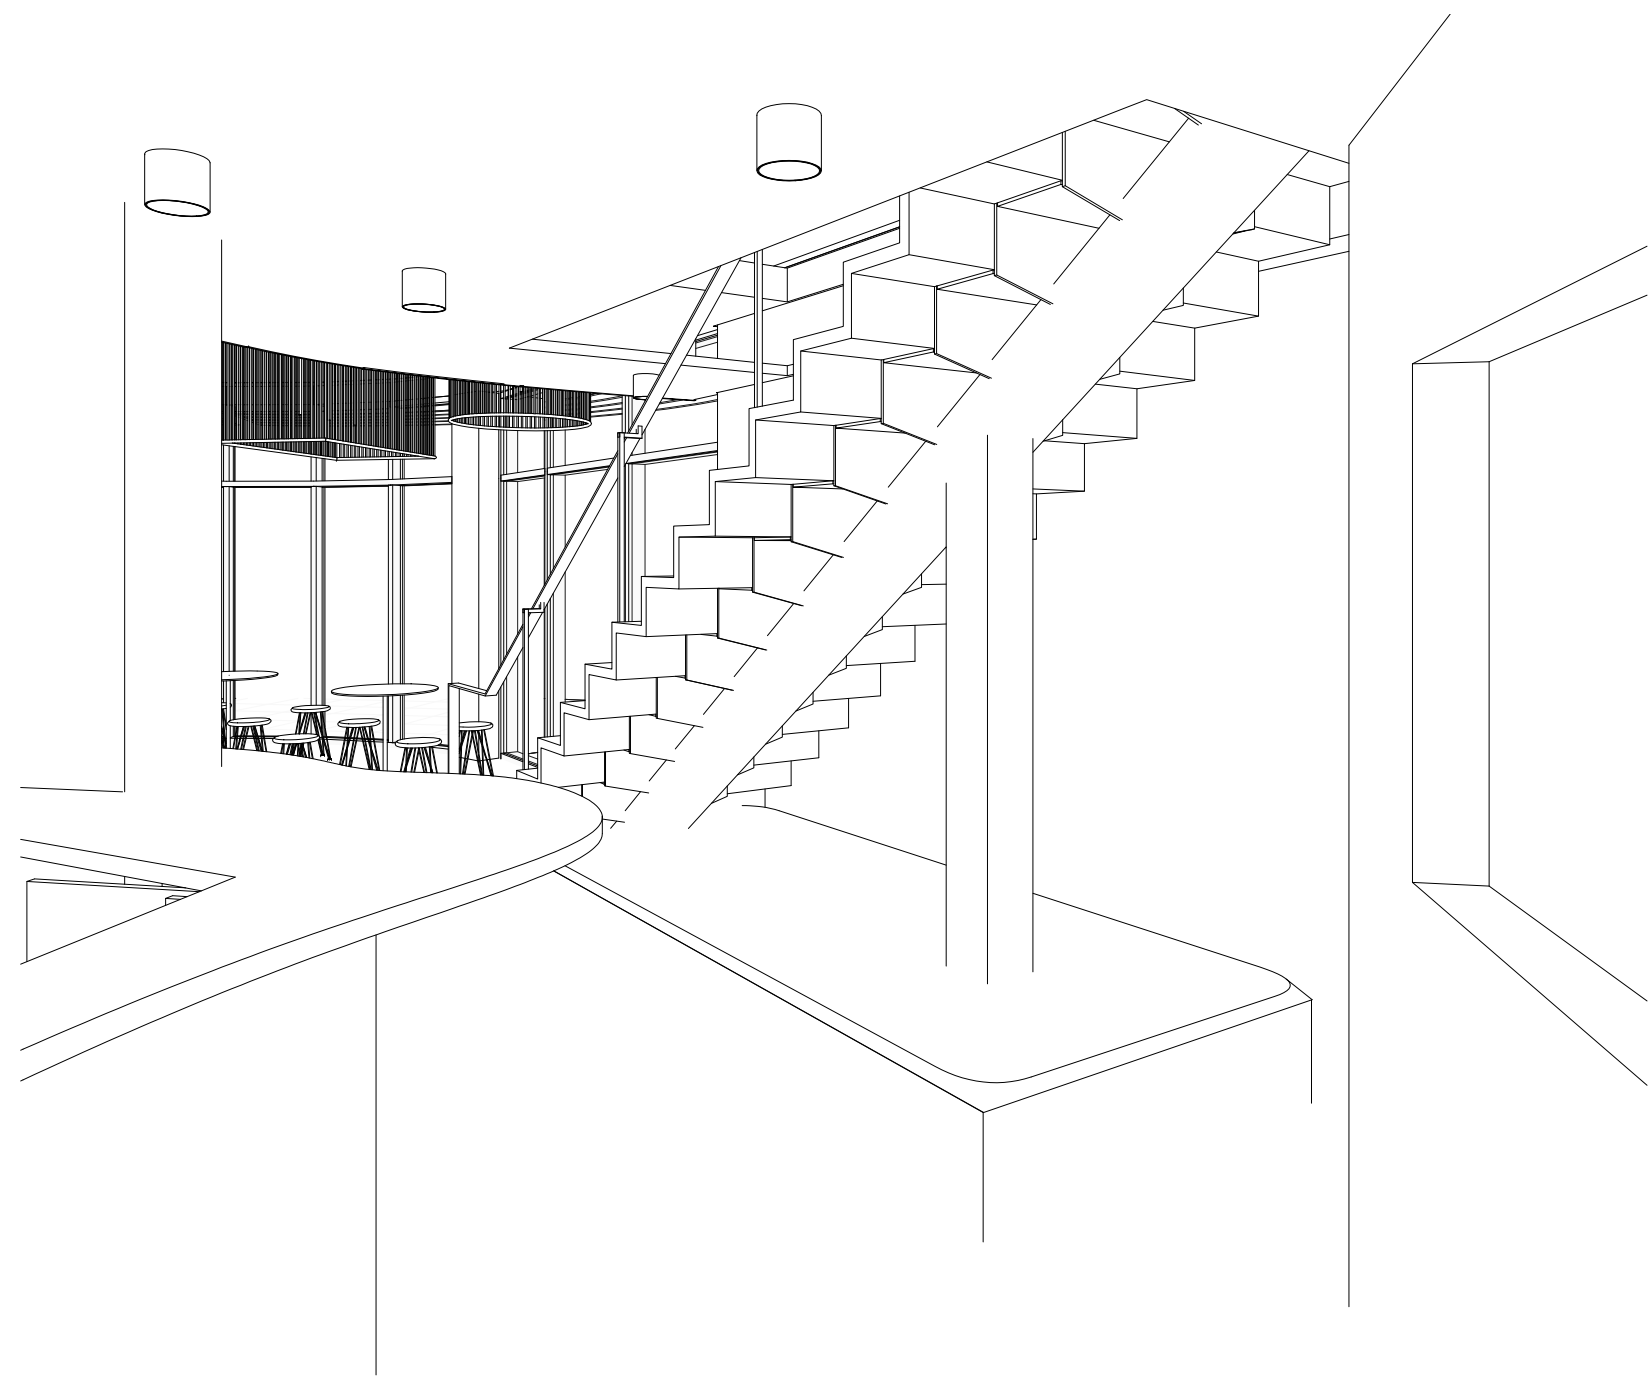


4 Staircase View 2

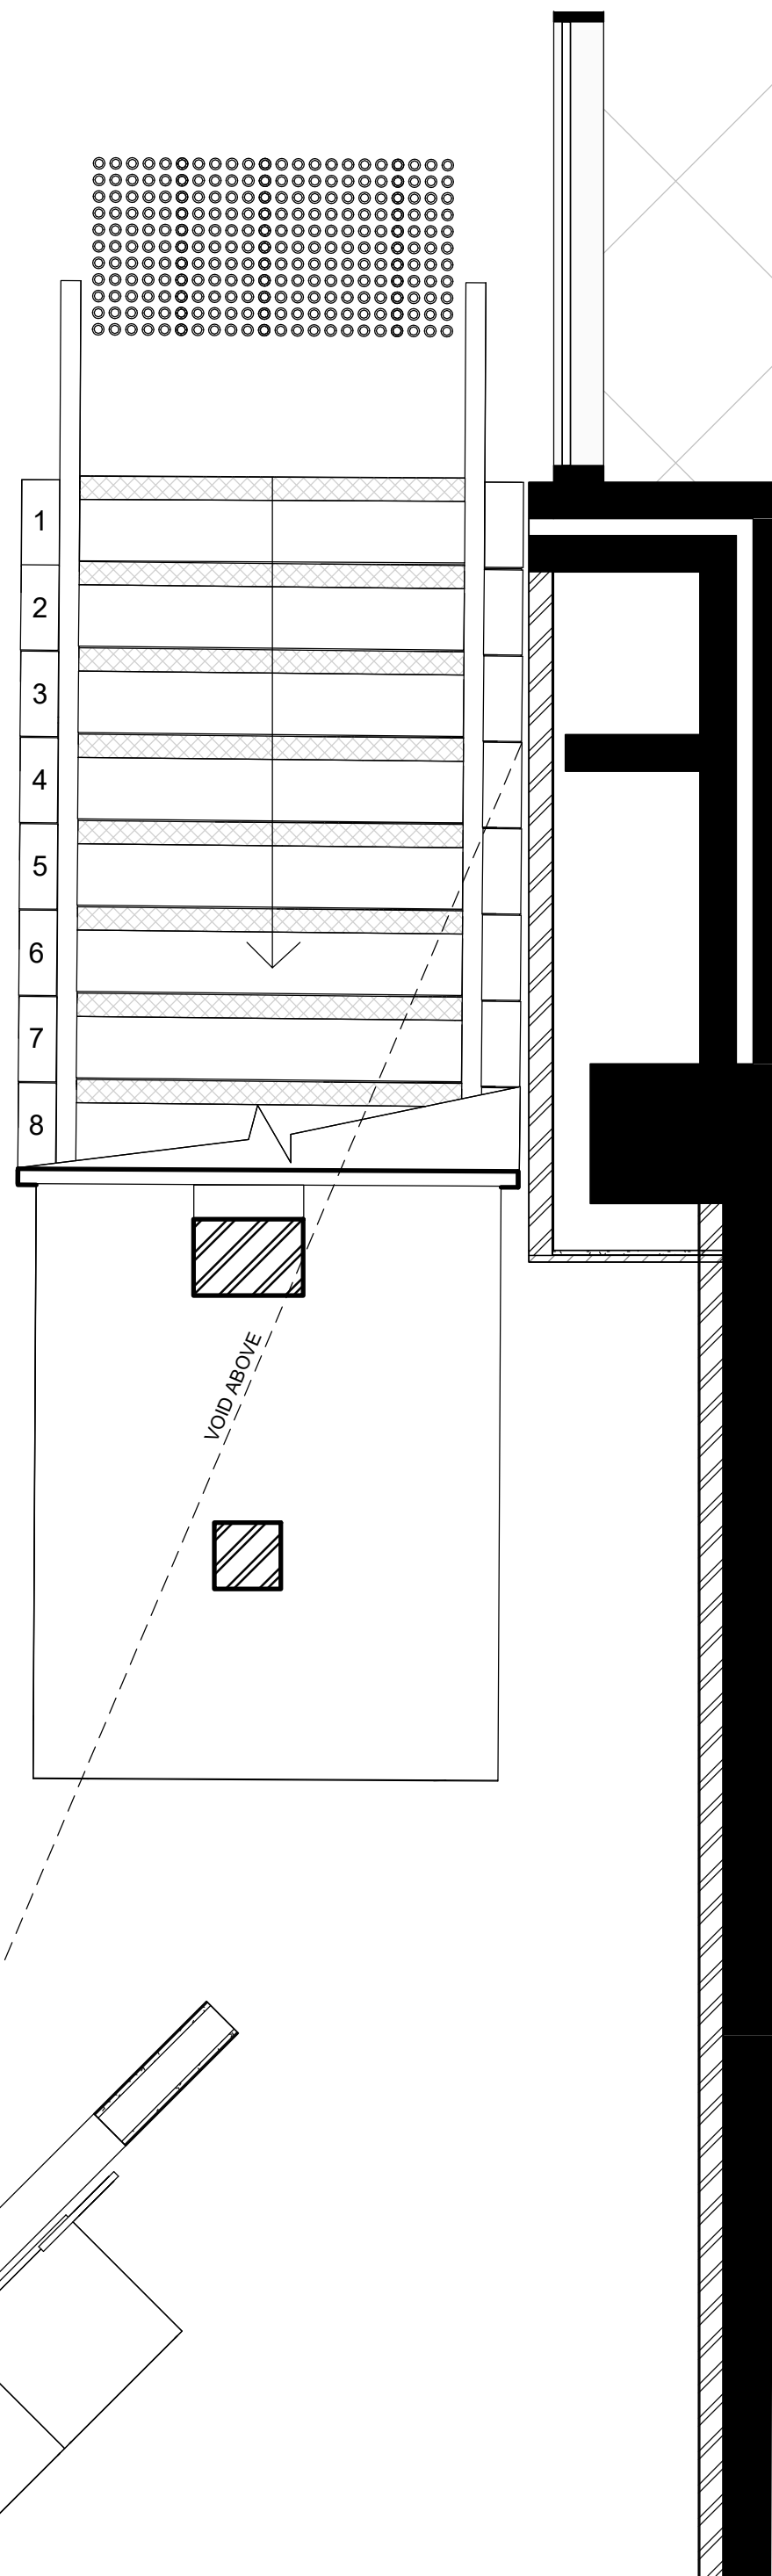


1 Staircase lower
1 : 20

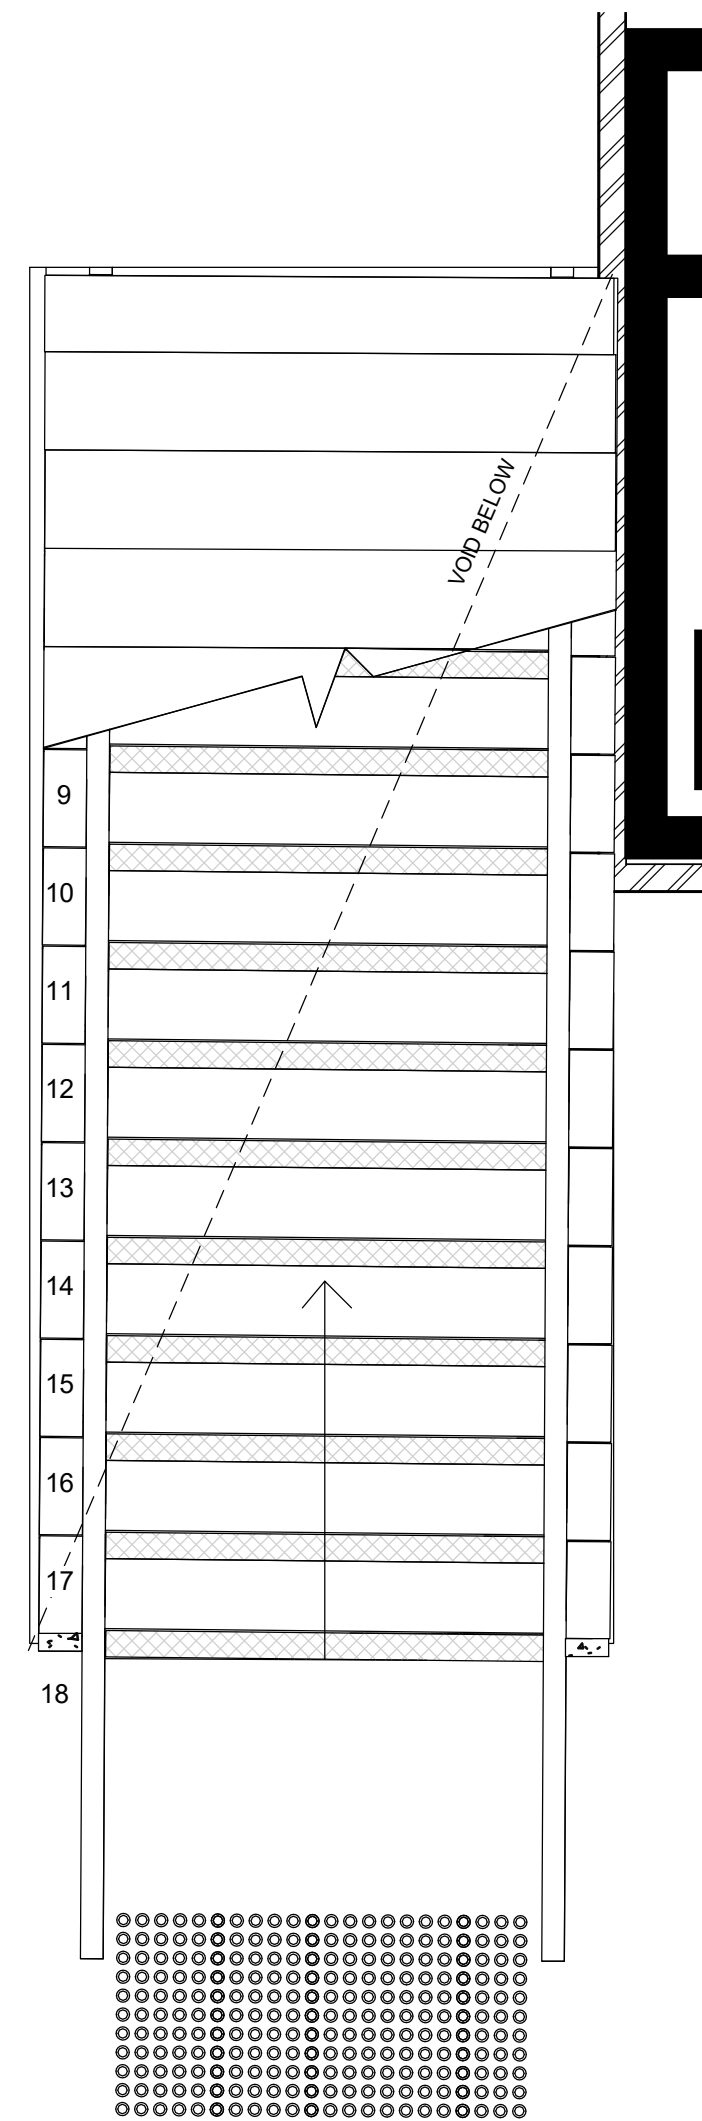


2 Staircase Upper
1 : 20

 

Revisions			Do not scale drawings. Use figured dimensions only. Check and verify levels and dimensions on site prior to commencement of any work, the preparation of drawings or the fabrication of components. This drawing is copyright and can not be reproduced without written consent.	Client Sue & Andy Baker <i>Le Velo</i>	True North	Billy Blue College of Design 46-52 Mountain Street, Ultimo, NSW 2007, Australia +61 (0)2 9999 9999  BILLY BLUE COLLEGE OF DESIGN[®] TORRENS UNIVERSITY AUSTRALIA  LAUREATE INTERNATIONAL UNIVERSITIES	Project IDC302A 48 Baywater Drive, Wentworth Point, NSW, 2127 Project number 20,001	Drawing Title Staircase plan Drawing Status PRESENTATION DRAWINGS NOT FOR CONSTRUCTION	Scale			Drawing No	Issue
No	Date	Description							Ver. App'd	1:20	A15	01	
01	21.08.21	PRESENTATION DRAWINGS							XX App'd	Date	21.08.21		
									Drawn by	MB			

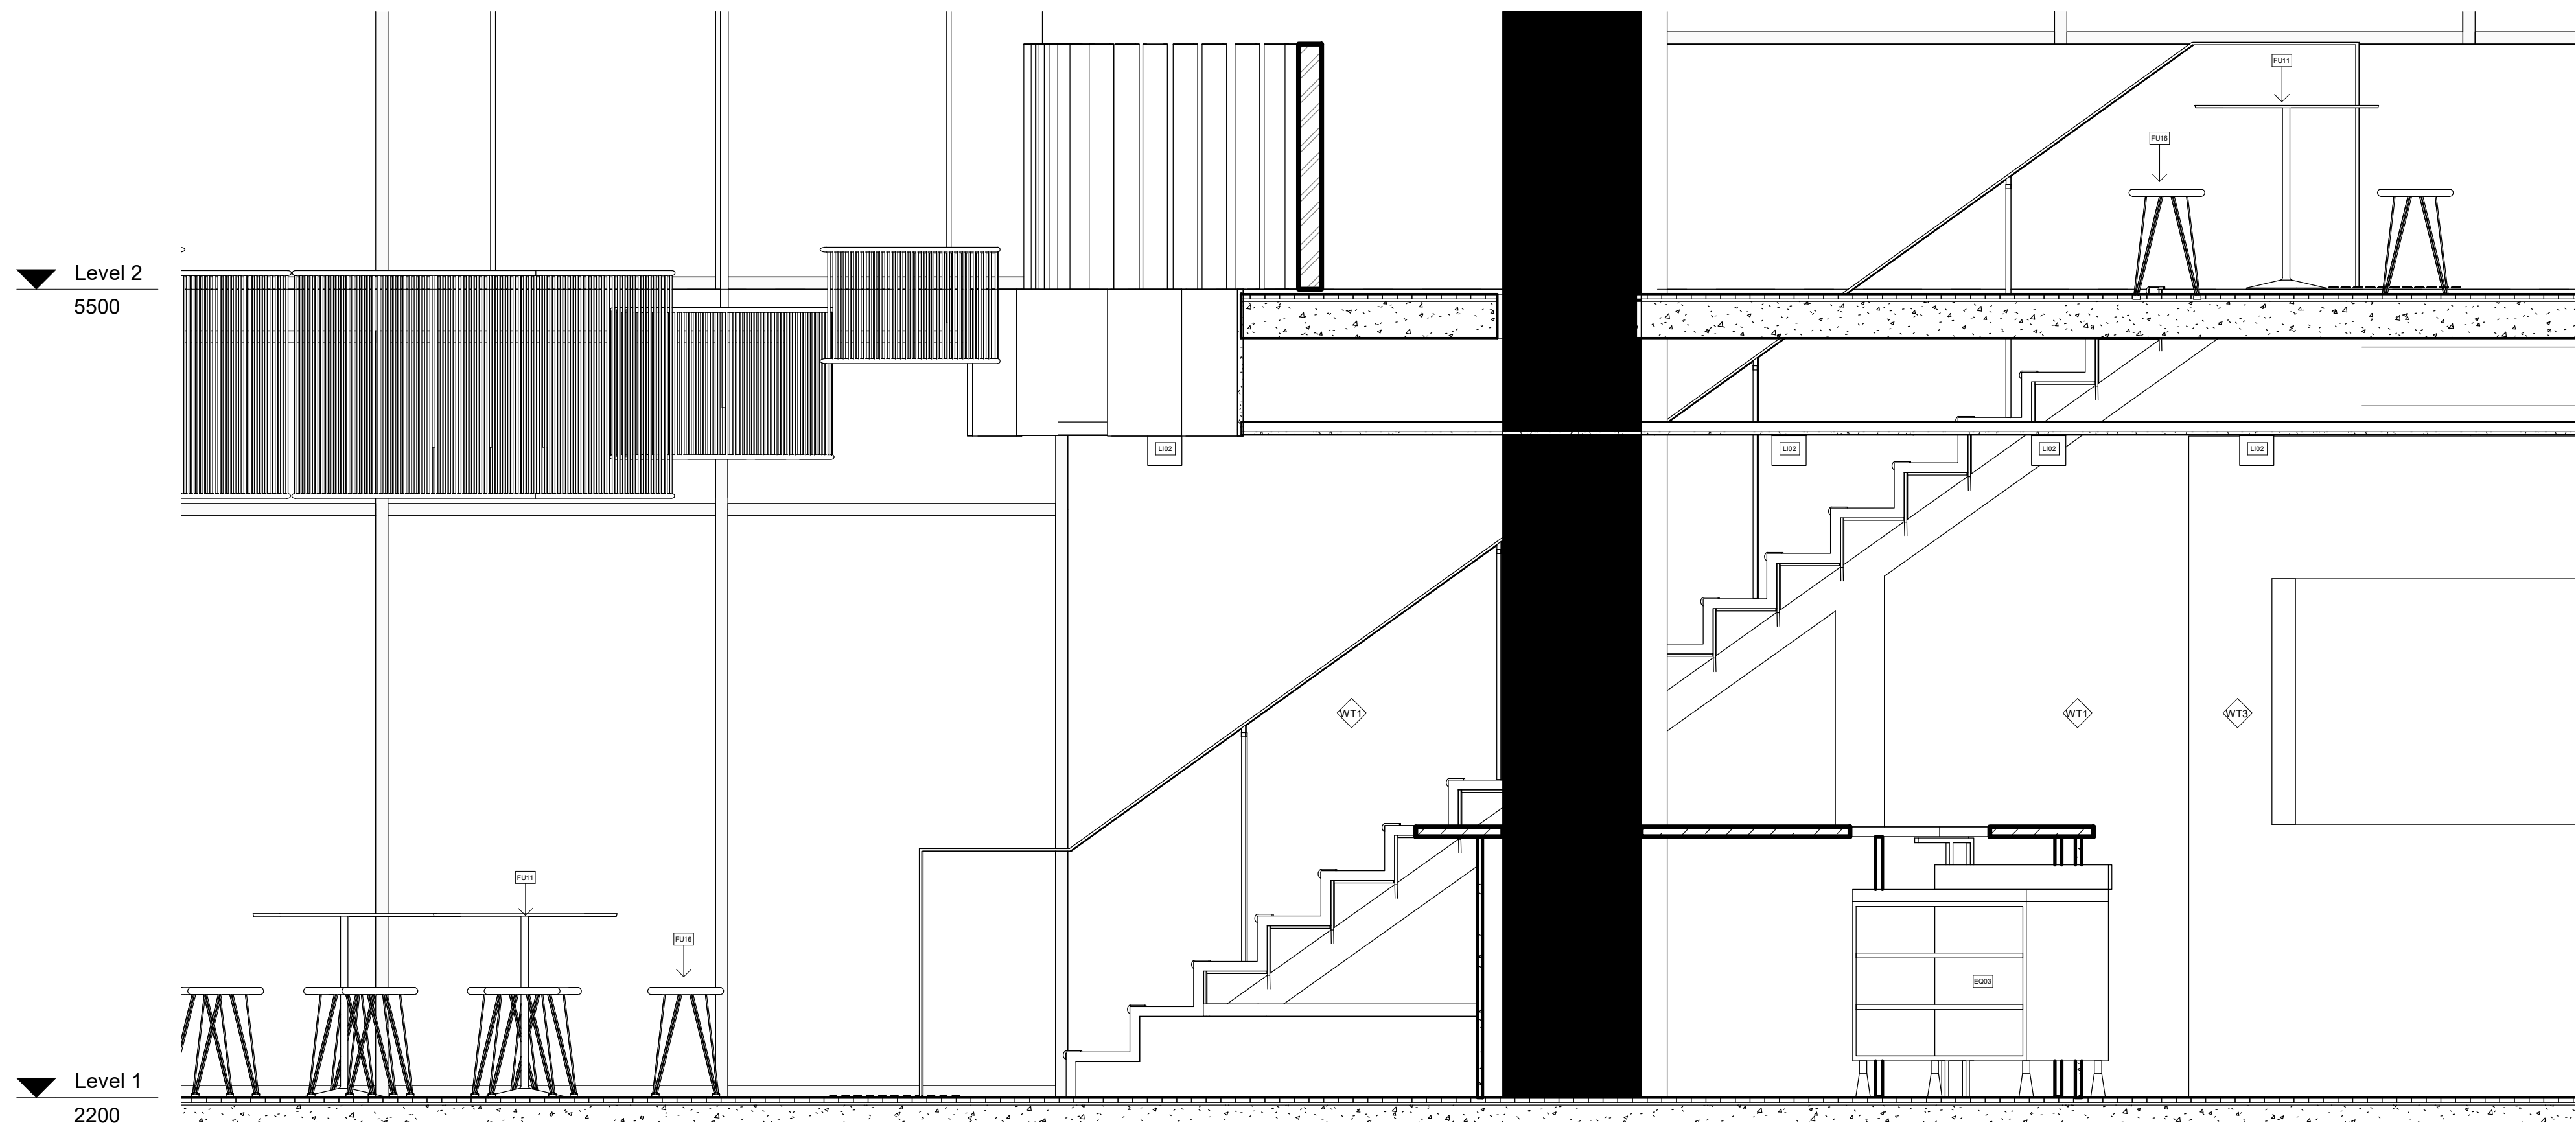

1 Staircase Elevation 1
1 : 20

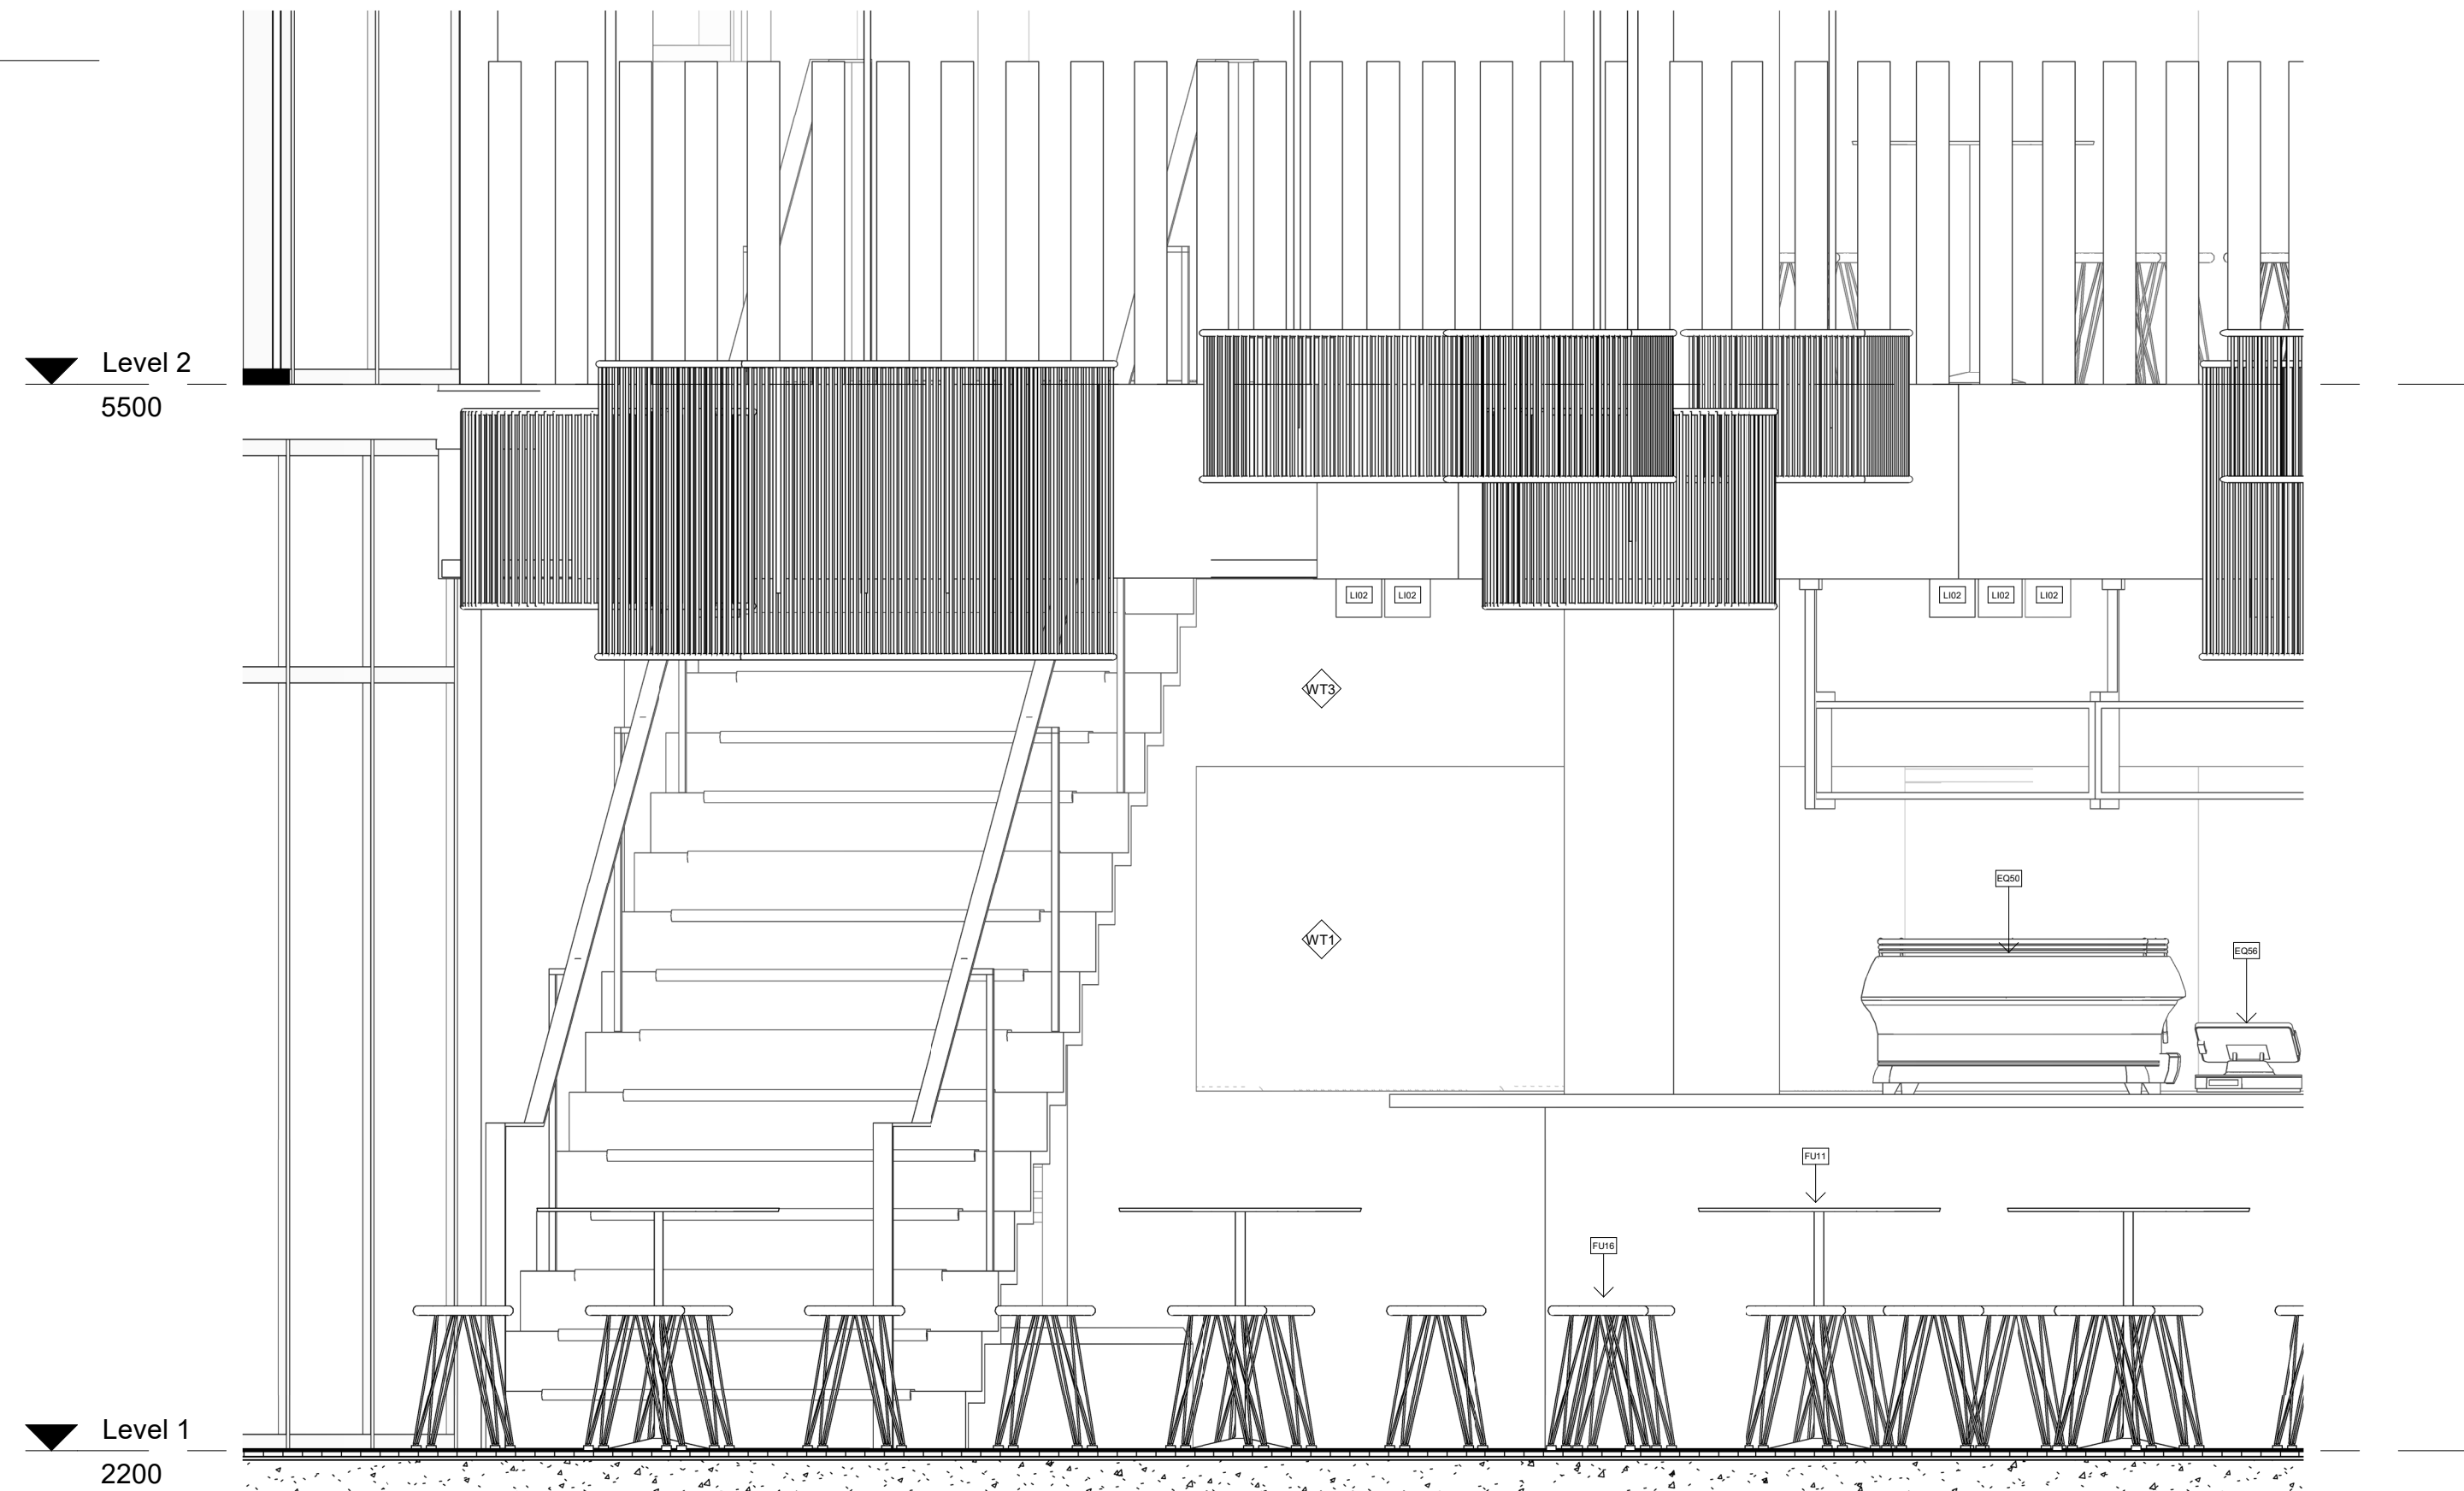

2 Staircase Elevation 2
1 : 20

LEGEND

Cut Material

	Existing Structure		Concrete
	Plaster Board		Steel
	Tiles		Glass

Wall Types

	WT1	2mm glue + 70mm Recycled Brick
	WT2	2mm glue + 70mm Recycled Brick + 2mm Artwork finish
	WT3	Timber stud wall 100 x 50 w/ 13mm FC + 2mm glue + 3mm Micro topping finish to each side
	WT4	13mm FC + 2mm glue + 3mm Micro topping finish
	WT5	Timber stud wall 100 x 50 w/ 13mm FC + 2mm glue + 3mm Micro topping finish

Door Types

	DO1	Flush Door 810mm x 2110mm
	DO2	Toilet cubicle Door 650mm x 2110mm
	DO3	Flush Double Doors 1510mm x 2110mm

Abbreviations

AP	Appliances	MA	Material
D	Door	PB	Plaster Board
DA	Development Application	SA	Sanitary
EQ	Equipment	SS	Stainless Steel
FU	Furniture	WT	Wall Type
		W/	With

Tag Legend


MA01	Wall Paint White by Porters paints
MA02	Wall Concrete by Hanson
MA03	Wall Tiles by Beaumont tiles
MA04	Wall Bricks by Austral bricks
MA05	Bar Glass by Express Glass
MA06	Bar Cement slab by Bunnings
MA11	Stairs Steel by Pacific Metal work
MA12	Bathroom Walls
MA16	Wall Paint Grey by porters paints
MA18	Glass by Express glass
MA19	Female/Male Sign
MA20	Concrete Slab Table
MA21	Aluminum Seat Swing
MA22	Steel Shipping Container
MA23	Repair Stand
MA24	Pot Plant
MA25	Ceiling Plant by Porters Paints
AP01	IMC Refrigeration Module B16704S
AP02	IMC Glass Door Module B16700S
AP05	IMC Wine Chiller Module B16703S
AP08	Waldorf Pasta Cooker PC8140G
AP09	Waldorf Kitchen Benchtops BT8600CB
AP12	Waldorf 8820 series8 Burners Double Static Oven RN8820G
AP13	Waldorf Refrigerator RN8100GRB
AP16	Waldorf Chargrill CH8900C-LS
AP18	Waldorf Gas fryer FN8120G
EQ02	IMC Bar Ice Chest BZ54060
EQ06	IMC Shelf Drainer BZ38100
EQ08	IMC Perforated Worktop BZ69100
EQ09	IMC Beer Station BZ34060
EQ11	IMC Basket Rack BZ23050
EQ13	IMC Double Sink BZ52100
EQ14	IMC Worktop Unit BZ50060
EQ18	IMC Storage Cupboard BZ61060
EQ20	IMC Three Drawer Unit BZ64040
EQ41	Waldorf BenchTop BT8450LS
EQ42	Ryno 600Series Bench SB6150A
EQ44	Street Furniture Bin 80LLB4
EQ45	Street Furniture Semi Hoop Bike Stand BST03
EQ56	IPS Paypoint Electronic Cash Register
EQ57	CommBank TapPay Contactless Payment
EQ50	LaMarzocco Coffee Machine FB80
EQ61	Toyko Bike SS
EQ62	Dog Bowl
EQ63	Bike RepairStand
EQ64	Mesh Gallery Partitions
EQ65	Outdoor Swing Seating
EQ67	Overhead Shelving Bar
EQ68	Retail Bar Table
FU10	Tall Linear Table & Benches
FU16	Style craft Spike Low Stool H450mm
FU11	Arper Dizzie Side Table Black
FU12	Take Away Counter
SA01	Dyson Hand Dryer Unit BZ50
SA03	Contura Recessed Soap Dispenser
SA05	RBA Jumbo Toilet Dispenser B2890
SA06	RBA Sanitary Mounted Napkin Disposal B270
SA11	RBA Full Height Basin RBA8881-100
SA12	Plumbing Fixtures Urinal
SA13	Toilet Plumbing Fixtures WC
SA14	Toilet Handicapped Grab Bars





Revisions			Do not scale drawings. Use figured dimensions only. Check and verify levels and dimensions on site prior to commencement of any work, the preparation of drawings or the fabrication of components. This drawing is copyright and can not be reproduced without written consent.	Client Sue & Andy Baker	True North	Billy Blue College of Design 46-52 Mountain Street, Ultimo, NSW 2007, Australia +61 (0)2 9999 9999	Project IDC302A 48 Baywater Drive, Wentworth Point, NSW, 2127 Project number 20,001	Drawing Title Starcase Elevation	Scale 1:20	Drawing No A16	Issue 01
No	Date	Description									
01	21.08.21	PRESENTATION DRAWINGS	Ver. App'd Approver					Drawing Status PRESENTATION DRAWINGS NOT FOR CONSTRUCTION	Date 21.08.21	Drawn by MB	

Le Velo




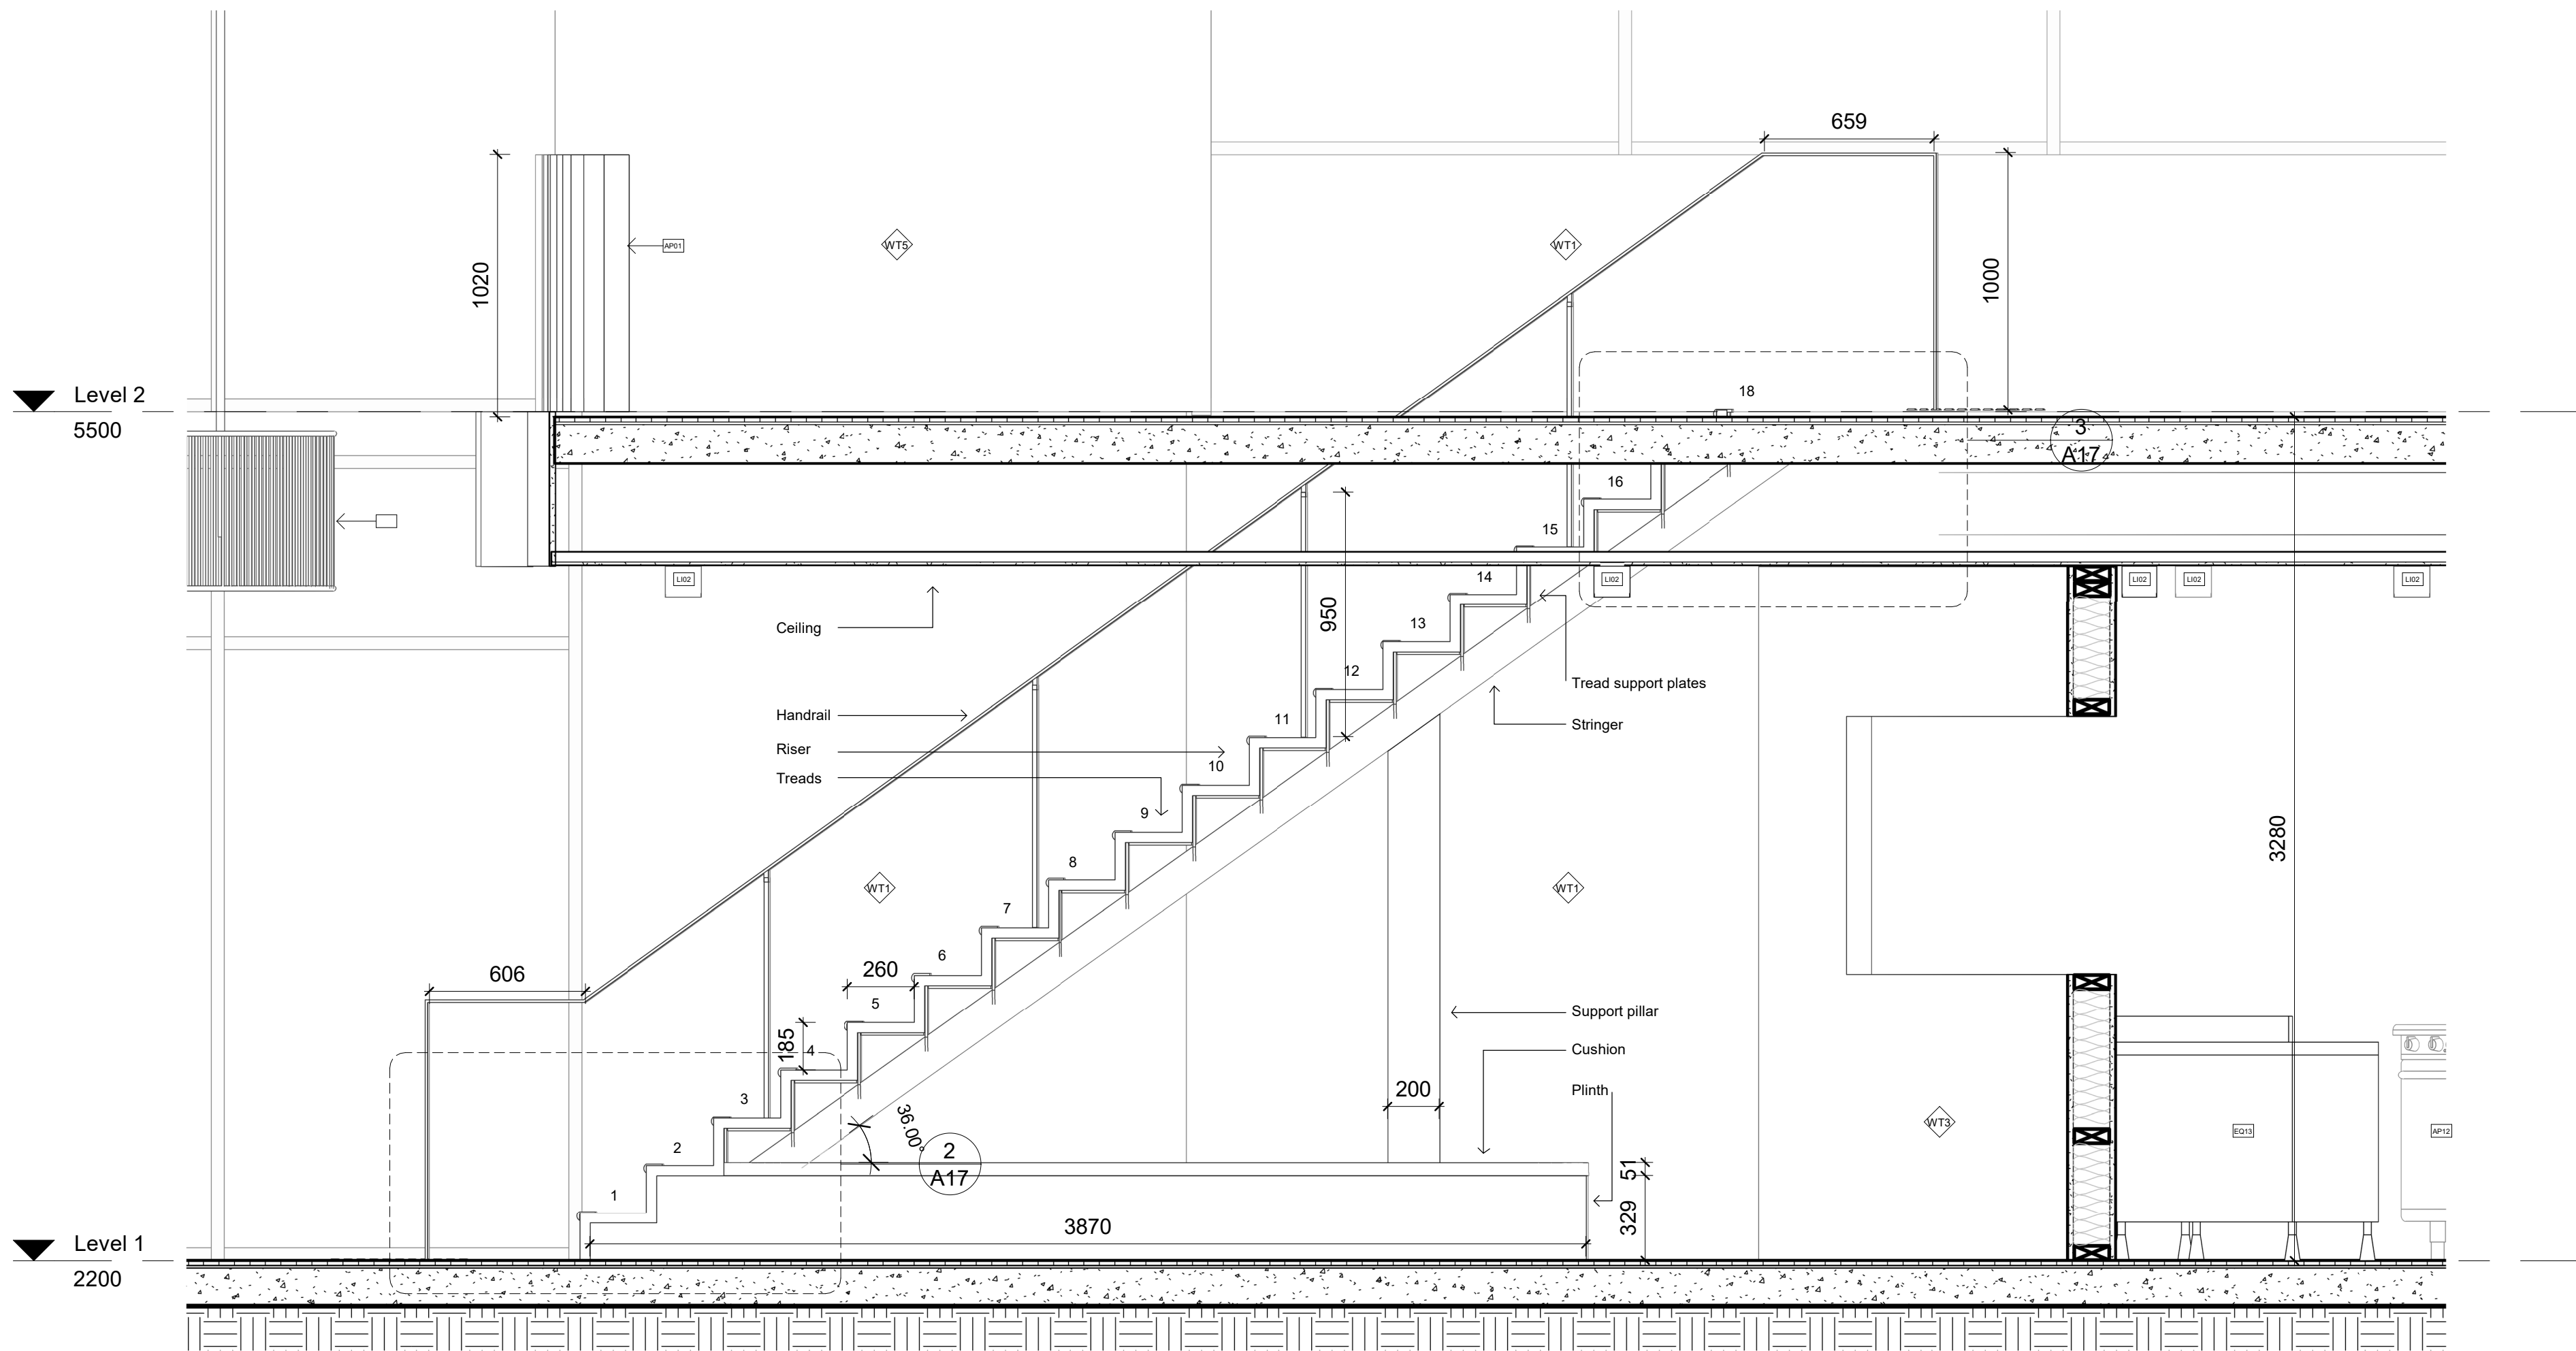


1 Staircase Section 3
1 : 20

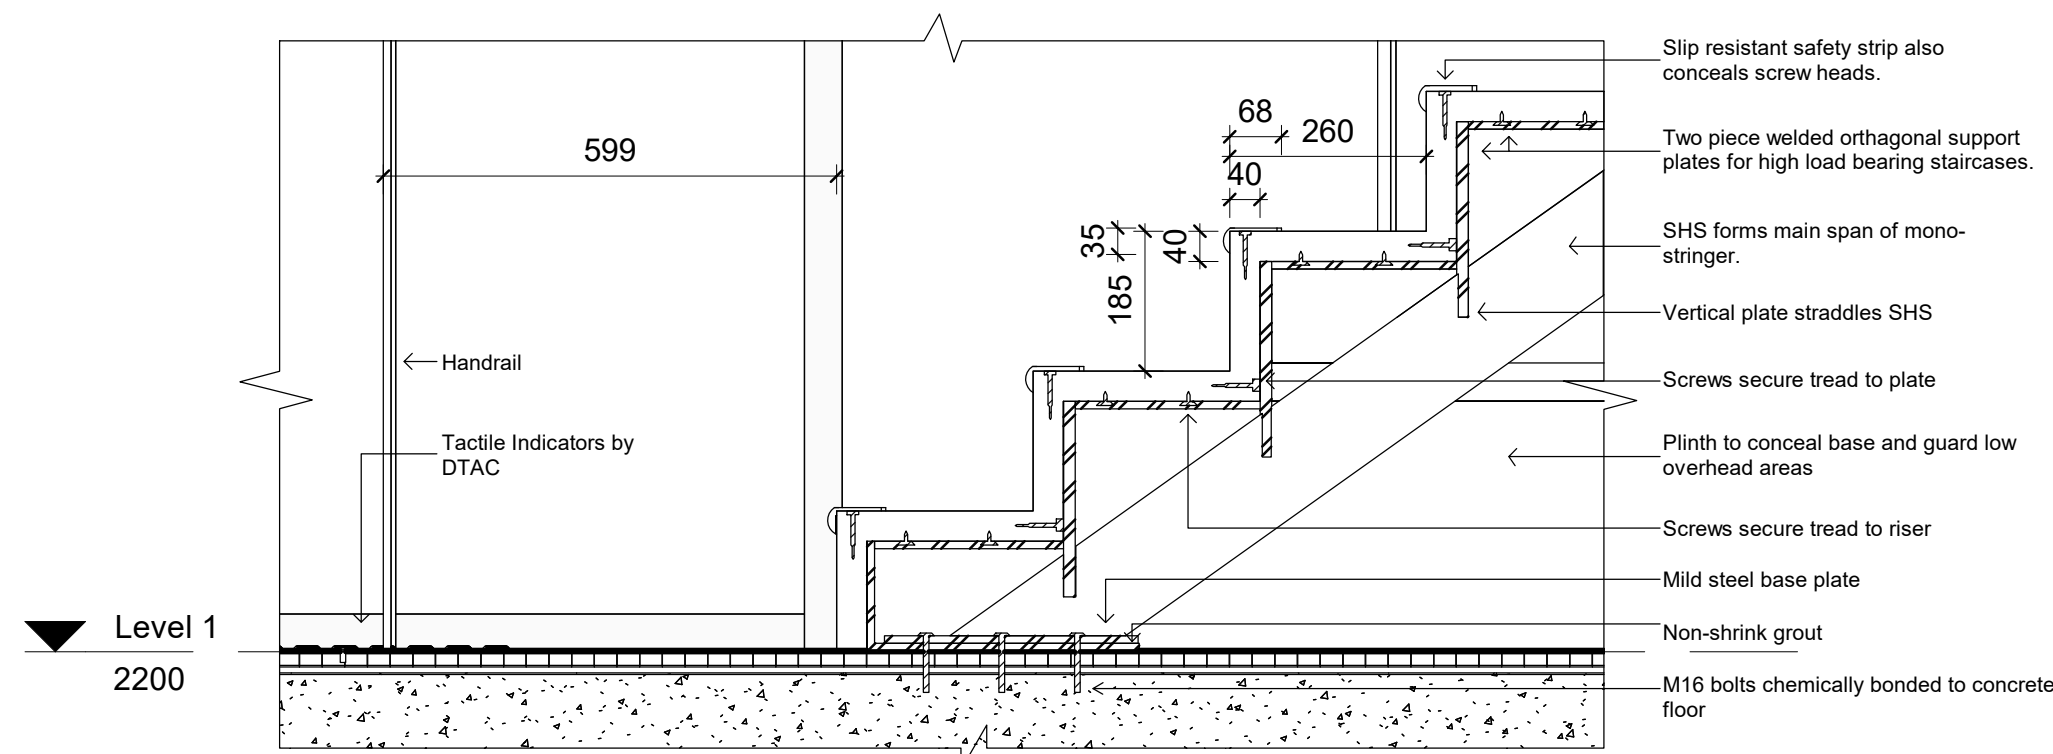 

2 Staircase Base Detail
1 : 10

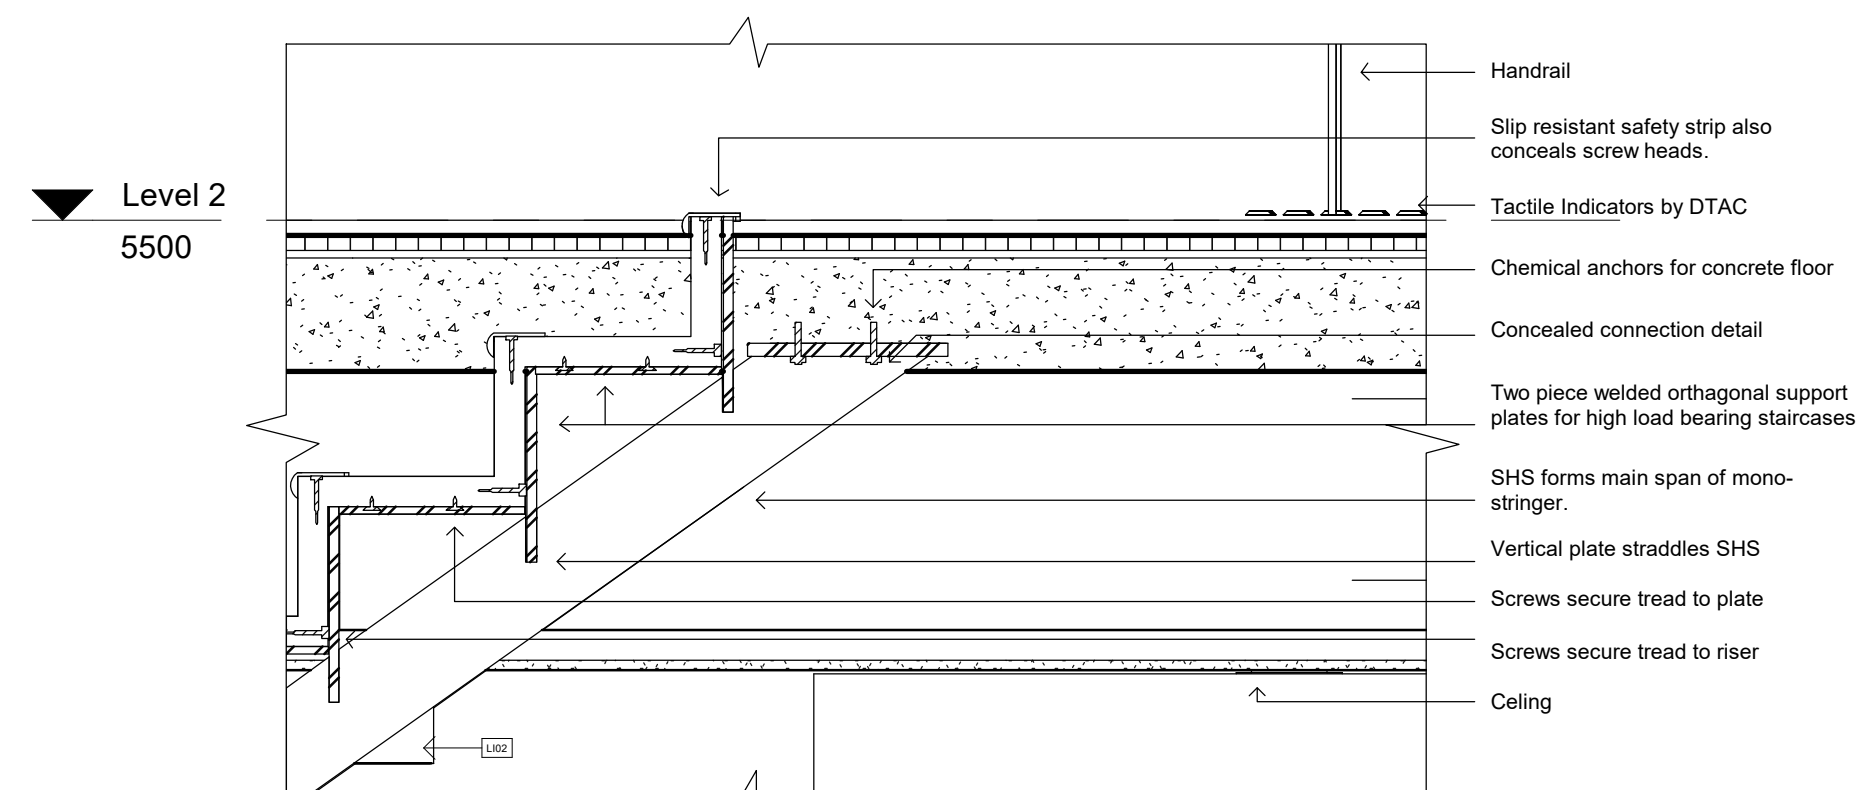

3 Staircase Level 2 Detail
1 : 10

 

LEGEND

Cut Material			
	Existing Structure		Concrete
	Plaster Board		Steel
	Tiles		Glass

Wall Types

	WT1	2mm glue + 70mm Recycled Brick
	WT2	2mm glue + 70mm Recycled Brick + 2mm Artwork finish
	WT3	Timber stud wall 100 x 50 w/ 13mm FC + 2mm glue + 3mm Micro topping finish to each side
	WT4	13mm FC + 2mm glue + 3mm Micro topping finish
	WT5	Timber stud wall 100 x 50 w/ 13mm FC + 2mm glue + 3mm Micro topping finish

Door Types

	DO1	Flush Door 810mm x 2110mm
	DO2	Toilet cubicle Door 650mm x 2110mm
	DO3	Flush Double Doors 1510mm x 2110mm

Abbreviations

AP	Appliances	MA	Material
D	Door	PB	Plaster Board
DA	Development Application	SA	Sanitary
EQ	Equipment	SS	Stainless Steel
FU	Furniture	WT	Wall Type
		W/	With

Tag Legend

MA01	Wall Paint White by Porters paints
MA02	Wall Concrete by Hanson
MA03	Wall Tiles by Beaumont tiles
MA04	Wall Bricks by Austral bricks
MA05	Bar Glass by Express Glass
MA06	Bar Cement slab by Bunnings
MA11	Stairs Steel by Pacific Metal work
MA12	Bathroom Walls
MA16	Wall Paint Grey by porters paints
MA18	Glass by Express glass
MA19	Female/Male Sign
MA20	Concrete Slab Table
MA21	Aluminum Seat Swing
MA22	Steel Shipping Container
MA23	Repair Stand
MA24	Pot Plant
MA25	Ceiling Plant by Porters Paints
AP01	IMC Refrigeration Module B16704S
AP02	IMC Glass Door Module B16700S
AP05	IMC Wine Chiller Module B16703S
AP08	Waldorf Pasta Cooker PC8140G
AP09	Waldorf Kitchen Benchtops BT8600CB
AP12	Waldorf 8820 series8 Burners Double Static Oven RN8920G
AP13	Waldorf Refrigerator RN8100GRB
AP16	Waldorf Charnill CH8900G-LS
AP18	Waldorf Gas fryer FN8120G
EQ02	IMC Bar Ice Chest BZ54060
EQ06	IMC Shelf Drainer BZ38100
EQ08	IMC Perforated Worktop BZ69100
EQ09	IMC Beer Station BZ34060
EQ11	IMC Basket Rack BZ23050
EQ13	IMC Double Sink BZ52100
EQ14	IMC Worktop Unit BZ50060
EQ18	IMC Storage Cupboard BZ61060
EQ20	IMC Three Drawer Unit BZ64040
EQ41	Waldorf BenchTop BT8450LS
EQ42	Ryno 600Series Bench SB6150A
EQ44	Street Furniture Bin 80LLB4
EQ45	Street Furniture Semi Hoop Bike Stand BS103
EQ56	IPS Paypoint Electronic Cash Register
EQ57	CommBank TapPay Contactless Payment
EQ50	LaMarzocco Coffee Machine FB80
EQ61	Toyko Bike SS
EQ62	Dog Bowl
EQ63	Bike RepairStand
EQ64	Mesh Gallery Partitions
EQ65	Outdoor Swing Seating
EQ67	Overhead Shelving Bar
EQ68	Retail Bar Table
FU10	Tait Linear Table & Benches
FU16	Style craft Spike Low Stool H450mm
FU11	Arper Dizzie Side Table Black
FU12	Take Away Counter
SA01	Dyson Hand Dryer Unit BZ50
SA03	Contura Recessed Soap Dispenser
SA05	RBA Jumbo Toilet Dispenser B2890
SA06	RBA Sanitary Mounted Napkin Disposal B270
SA11	RBA Full Height Basin RBA8881-100
SA12	Plumbing Fixtures Urinal
SA13	Toilet Plumbing Fixtures WC
SA14	Toilet Handicaped Grab Bars

Revisions		
No	Date	Description
01	21.08.21	PRESENTATION DRAWINGS

Ver. App'd
XX App'd

Do not scale drawings. Use figured dimensions only. Check and verify levels and dimensions on site prior to commencement of any work, the preparation of drawings or the fabrication of components.
This drawing is copyright and can not be reproduced without written consent.

Client
Sue & Andy Baker

Le Velo

True North

Billy Blue College of Design
46-52 Mountain Street, Ultimo, NSW 2007, Australia
+61 (0)2 9999 9999



Project
IDC302A

48 Baywater Drive, Wentworth Point, NSW, 2127

Project number
20,001

Drawing Title
Staircase Section

Drawing Status
PRESENTATION DRAWINGS
NOT FOR CONSTRUCTION

Scale
Drawing No
Issue

Date
21.08.21

Drawn by
MB

