


Frontline Fitness
630 Canterbury road,
Belmore, NSW. 2192

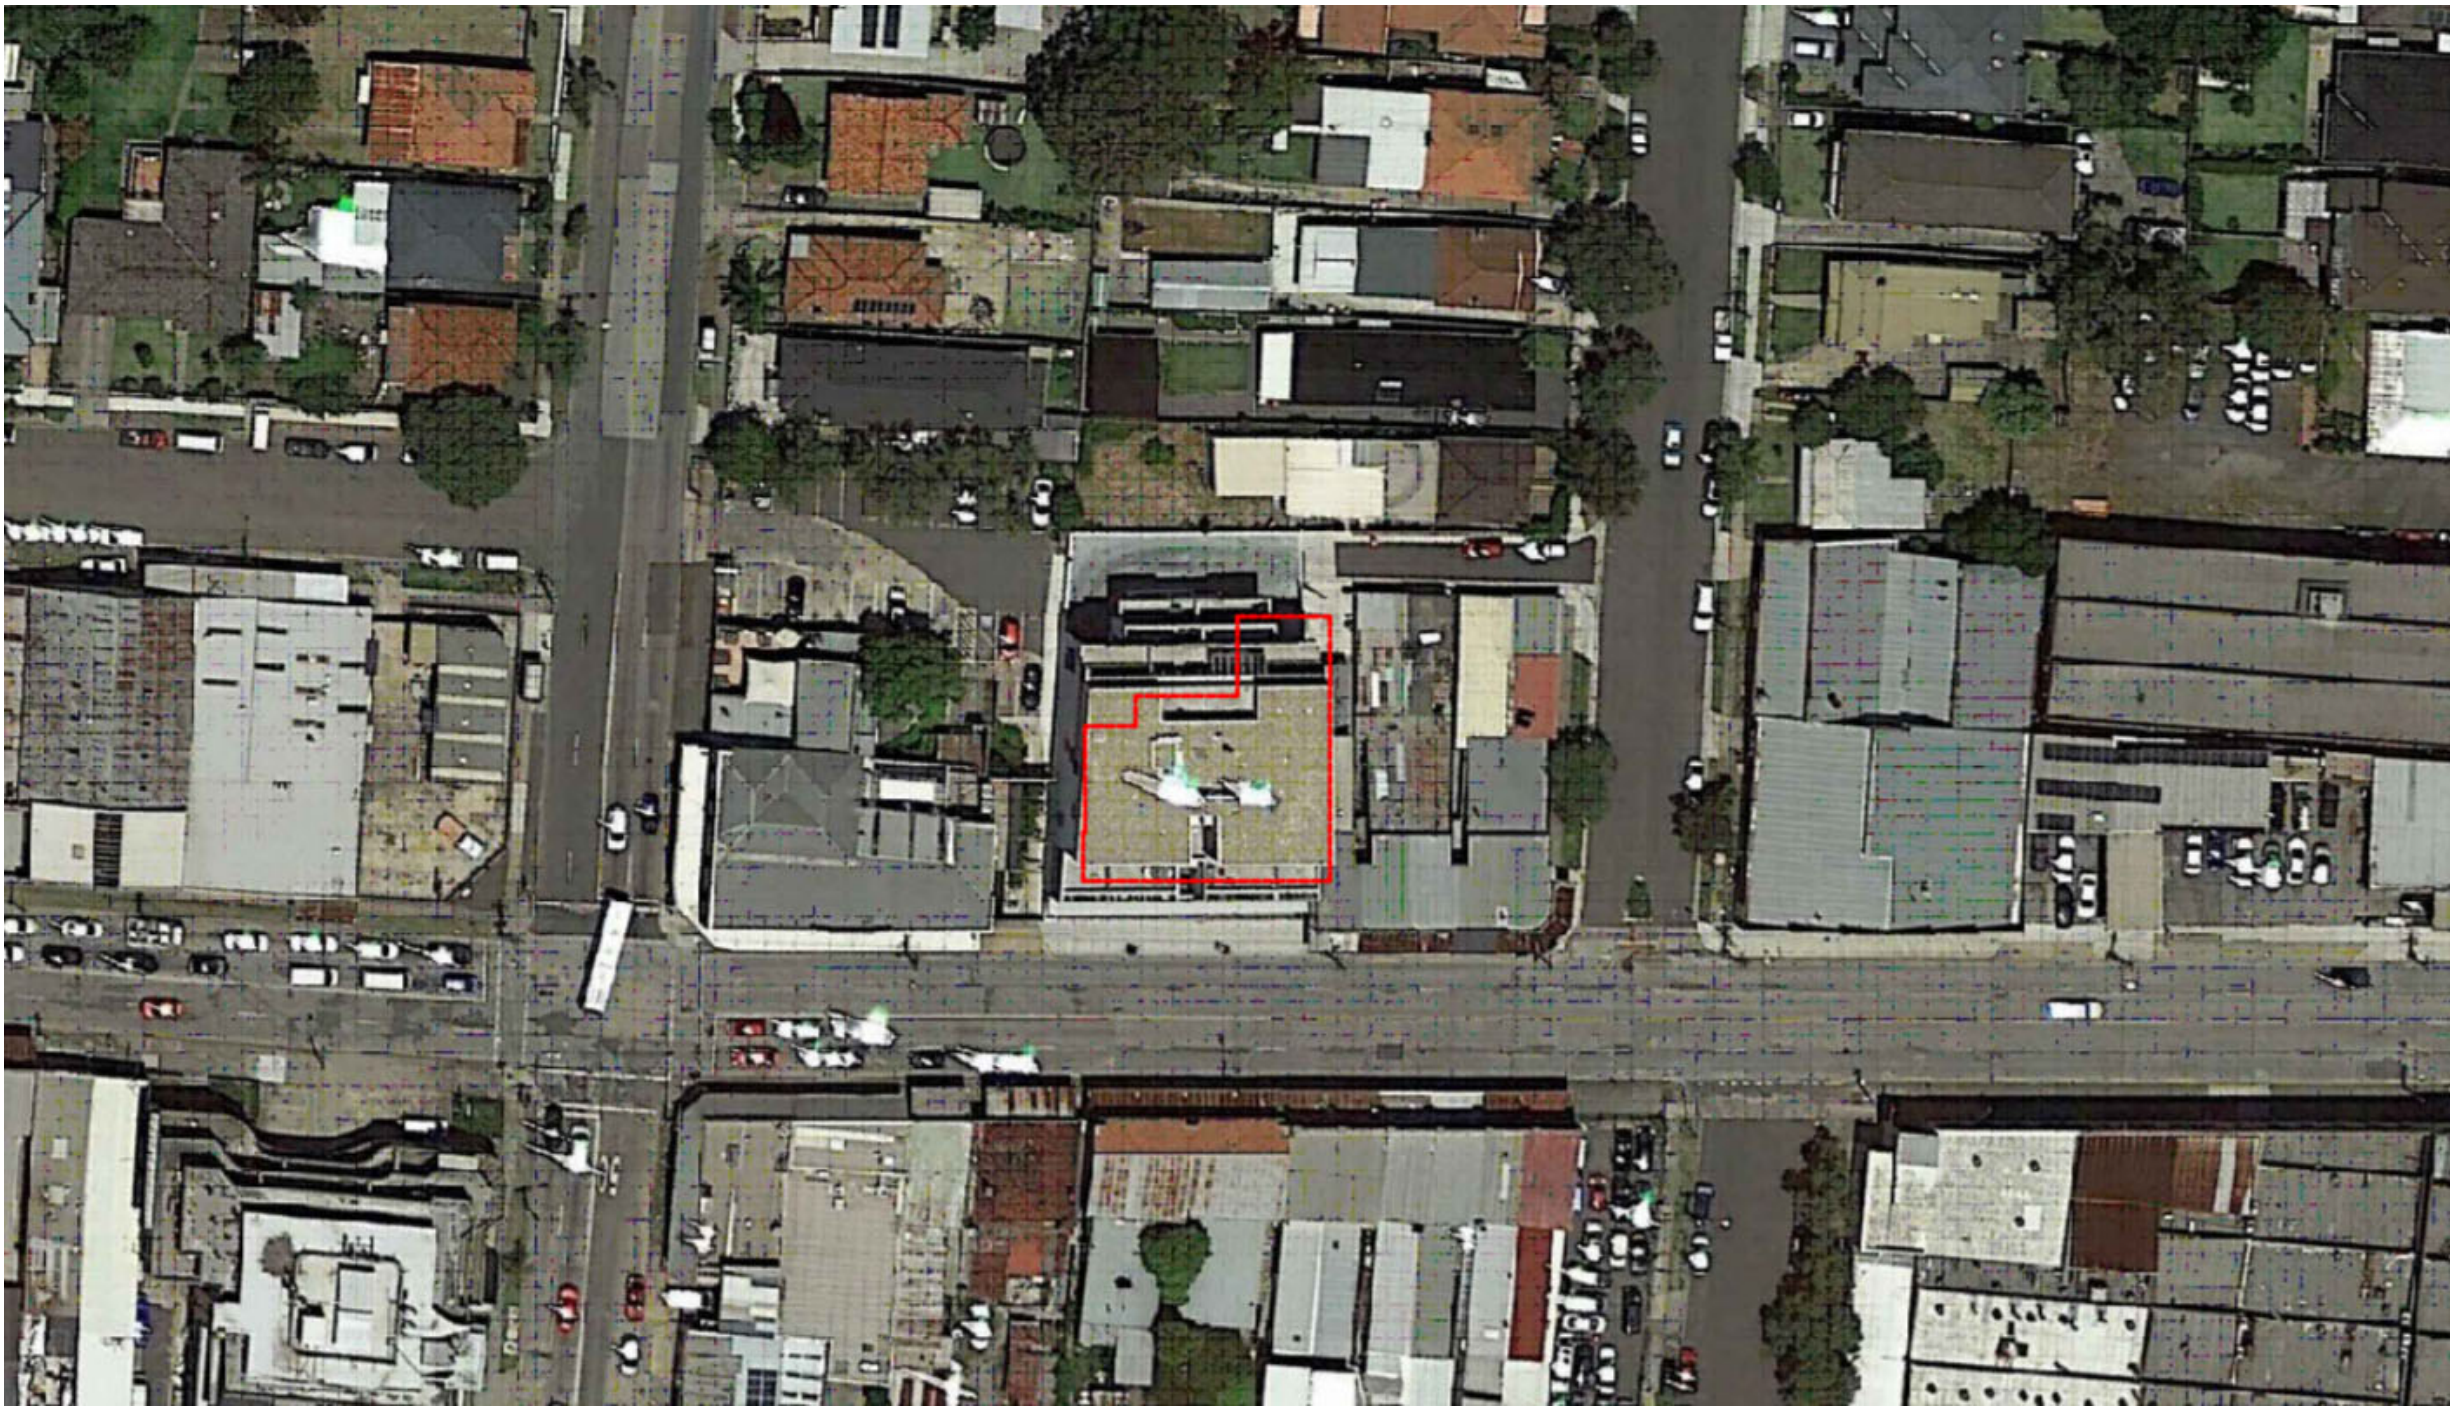

Room Schedule

Name	Area
Chill Out Zone	38 m²
Class/Hire Room	35 m²
D	5 m²
F	3 m²
GYM Floor	215 m²
Infrared Sauna	7 m²
Kitchen	5 m²
M	3 m²
Office	13 m²
Reception	20 m²
Showers	6 m²

Sheet List

Sheet Number	Sheet Name	Scale
D00	Cover Sheet	N/A
D01	Existing Plan	1 : 50
D02	Demolition Plan	1 : 50
D03	Proposed Floor Plan	1 : 50
D04	Proposed Furniture Plan	1 : 50
D05	Electrical plan	1 : 50
D06	RCP	1 : 50
D07	External Elevations	1 : 50
D08	Section 1	1 : 50
D09	Section 2	1 : 50
D10	Section 3	1 : 25
D11	Section 4	1 : 25
D12	Infrared Sauna Plan	1 : 10
D13	Infrared Sauna Elevation 1	1 : 10
D14	Infrared Sauna Elevation 2	1 : 10
D15	Infrared Sauna Elevation 3	1 : 10
D16	Infrared Sauna Elevation 4	1 : 10
D17	Infrared Sauna Section Detail 1	As Indicated
D18	Infrared Sauna Section Detail 2	As Indicated
D19	Infrared Sauna Isometric View Detail	N/A
D20	Reception Plan	1 : 10
D21	Reception Elevation 1	1 : 10
D22	Reception Elevation 2	1 : 10
D23	Reception Elevation 3	1 : 10
D24	Reception Elevation 4	1 : 10
D25	Reception Cross-section	1 : 10
D26	Reception Isometric View	N/A

LEGEND

Cut Material

Glass

Cedar

Concrete

Gym Mat

Tiles

Plaster Board

Existing Structure

Wall Types

WT1

Timber stud wall 90mm x 45mm w/ 9mm Plaster board and 'Mountain Ash - Low sheen' Paint finish

WT2

'Custom Frontline Green - Low sheen' Paint finish (1200mm H)

WT3

Timber stud wall 90mm x 45mm w/ 12mm timber cedar top

WT4

24mm Melamine (2400mm H)

WT5

Timber stud wall 90mm x 45mm w/ 2mm glue + 6mm Bricklane tile

WT6

Timber stud wall 90mm x 45mm w/ 2mm glue + 6mm square tile

Door Types

DO1

915mm x 2134mm Flush w/ Blk Frame

DO2

813mm x 2134mm Flush w/ Blk Frame

DO3

762mm x 2000mm Toilet Cubicle Door

DO4

915mm x 2134mm Glass w/ Blk Frame

DO5

762mm x 2134mm Glass w/ Blk Frame

Window Types

W01

815mm x 2850mm Frosted Glass w/ Blk Frame

W02

815mm x 2210mm Glass w/ Blk Frame

Abbreviations

BLK

Black

DO

Door

EQ

Equipment

FJ

Fixture

FJ

Furniture

SA

Sanitary

SS

Stainless Steel

W0

Window

WT

Wall Type

WJ

With

Tag Legend

FU01 - 2x Medium Locker by Elite Office Furniture

FU02 - Chair by Coalesse 'Joel'

FU03 - Chair by Coalesse 'Sidewalk'

FU04 - 2 Seater Lounge by by Coalesse 'Sidewalk'

FU05 - Coffee table by Metro 'Tippo'

FU06 - Coffee table by Temple and Webster

FU07 - Office Chair by Coalesse 'Bindu'

FU08 - Reception Desk by Elite Office Furniture 'Casnan Premier Sorrento Reception Counter'

FU09 - Office Desk by Modern Furniture 'Atlan Executive Desk'

EQ01 - Drinking Fountain by Filtrine 'FSC-107-14-HL-VF'

EQ02 - Treadmill by Nordic Track 'Sport 50'

EQ03 - Exercise bike by Nordic Track 'S10 Studio Bike'

EQ04 - Leg press by Aussie Fitness 'Gym King HS'

EQ05 - Gym Bench by Aussie Fitness 'Gym King Flat bench'

EQ06 - Squat Rack by Aussie Fitness 'Gym King Commercial Smith Machine'

EQ07 - Power Rack by Aussie Fitness 'Gym King Commercial Power Rack'

EQ08 - Dumbbell Rack by Commercial Fitness Equipment 'Titanium USA Monster Series'

EQ09 - Weight Rack by Sumo Strenight 'barbarian Rack Package'

EQ10 - Sauna Panel by Jacuzzi Clearlight Saunas 'Custom Kit'

SA01 - Basin by Temple and Webster 'Tulip Wall Hung Basin'

SA02 - Toilet by Temple and Webster 'White Minna Rimless BTW'

SA03 - Shower Head by Temple and Webster '2 Piece Square Shower Head'

SA04 - Drain by Temple and Webster '11x11 Square Shower Grate Floor Drain'

SA08 - Disable toilet sign by Keeler Hardware 'AS1428 Compliant Toilet Sign SILVER Unisex Disabled'

SA10 - Bathroom mirror / dryer / soap by Bradley Australia 'bradley behind mirror foam soap and hand dryer'

SA11 - Toilet Roll Holder by Estlio 'Chrome Bela Single roll Holder'

SA12 - Shower Mixer by The Blue Space 'Phoenix Vivid Slimline Shower/Wall Mixer'

SA13 - Toilet flush button by Icon Bathware 'Invisil Series II'

F104 - Sled Track by Raw Fitness Equipment 'Custom Gym Sled'

L01 - Light up Mirror by ATS Tiles and Bathroom 'Retti Rectangular LED Mirror'

L02 - LED Logo by Big Banner

MA01 - Polished Concrete

MA02 - GYM MAT

MA03 - Custome Sled turf by Raw Fitness Equipment 'Custom Gym Sled'

MA04 - Brick Lane Tiles by National Tiles

MA05 - Paint finish by Porters Paints 'Mountain Ash'

MA06 - Paint finish by Porters Paints 'Custom Frontline Green'

MA07 - Tiles by National Tiles 'Zellige White Matt Tile'

MA08 - Paint finish by Porters Paints 'Anisced'

MA09 - Cedar Wood

REVISIONS

No Date

01 27.10.21

Description

PRESENTATION DRAWINGS
NOT FOR CONSTRUCTION

Ver. App'd

XX App'd

Do not scale drawings. Use figured dimensions only. Check and verify levels and dimensions on site prior to commencement of any work, the preparation of drawings or the fabrication of components.
This drawing is copyright and can not be reproduced without written consent.

Client

Moey Faour



Frontline Fitness
"LEADING FROM THE FRONT"

True North



Billy Blue College of Design
46-52 Mountain Street, Ultimo, NSW 2007, Australia
+61 (0)2 9999 9999

BILLY BLUE
COLLEGE OF DESIGN

TORRENS
UNIVERSITY
AUSTRALIA

LAUREATE INTERNATIONAL UNIVERSITIES

Project

Frontline Fitness

630 Canterbury Road,
Belmore, NSW. 2192

Project number
01

Drawing Title

Cover Sheet

Drawing Status

PRESENTATION
DRAWINGS
NOT FOR
CONSTRUCTION

Scale

N/A

Drawing No

D00

Issue

01

Date


27.10.21

Drawn by

MB

6/12/2021 3:50:47 AM

A1

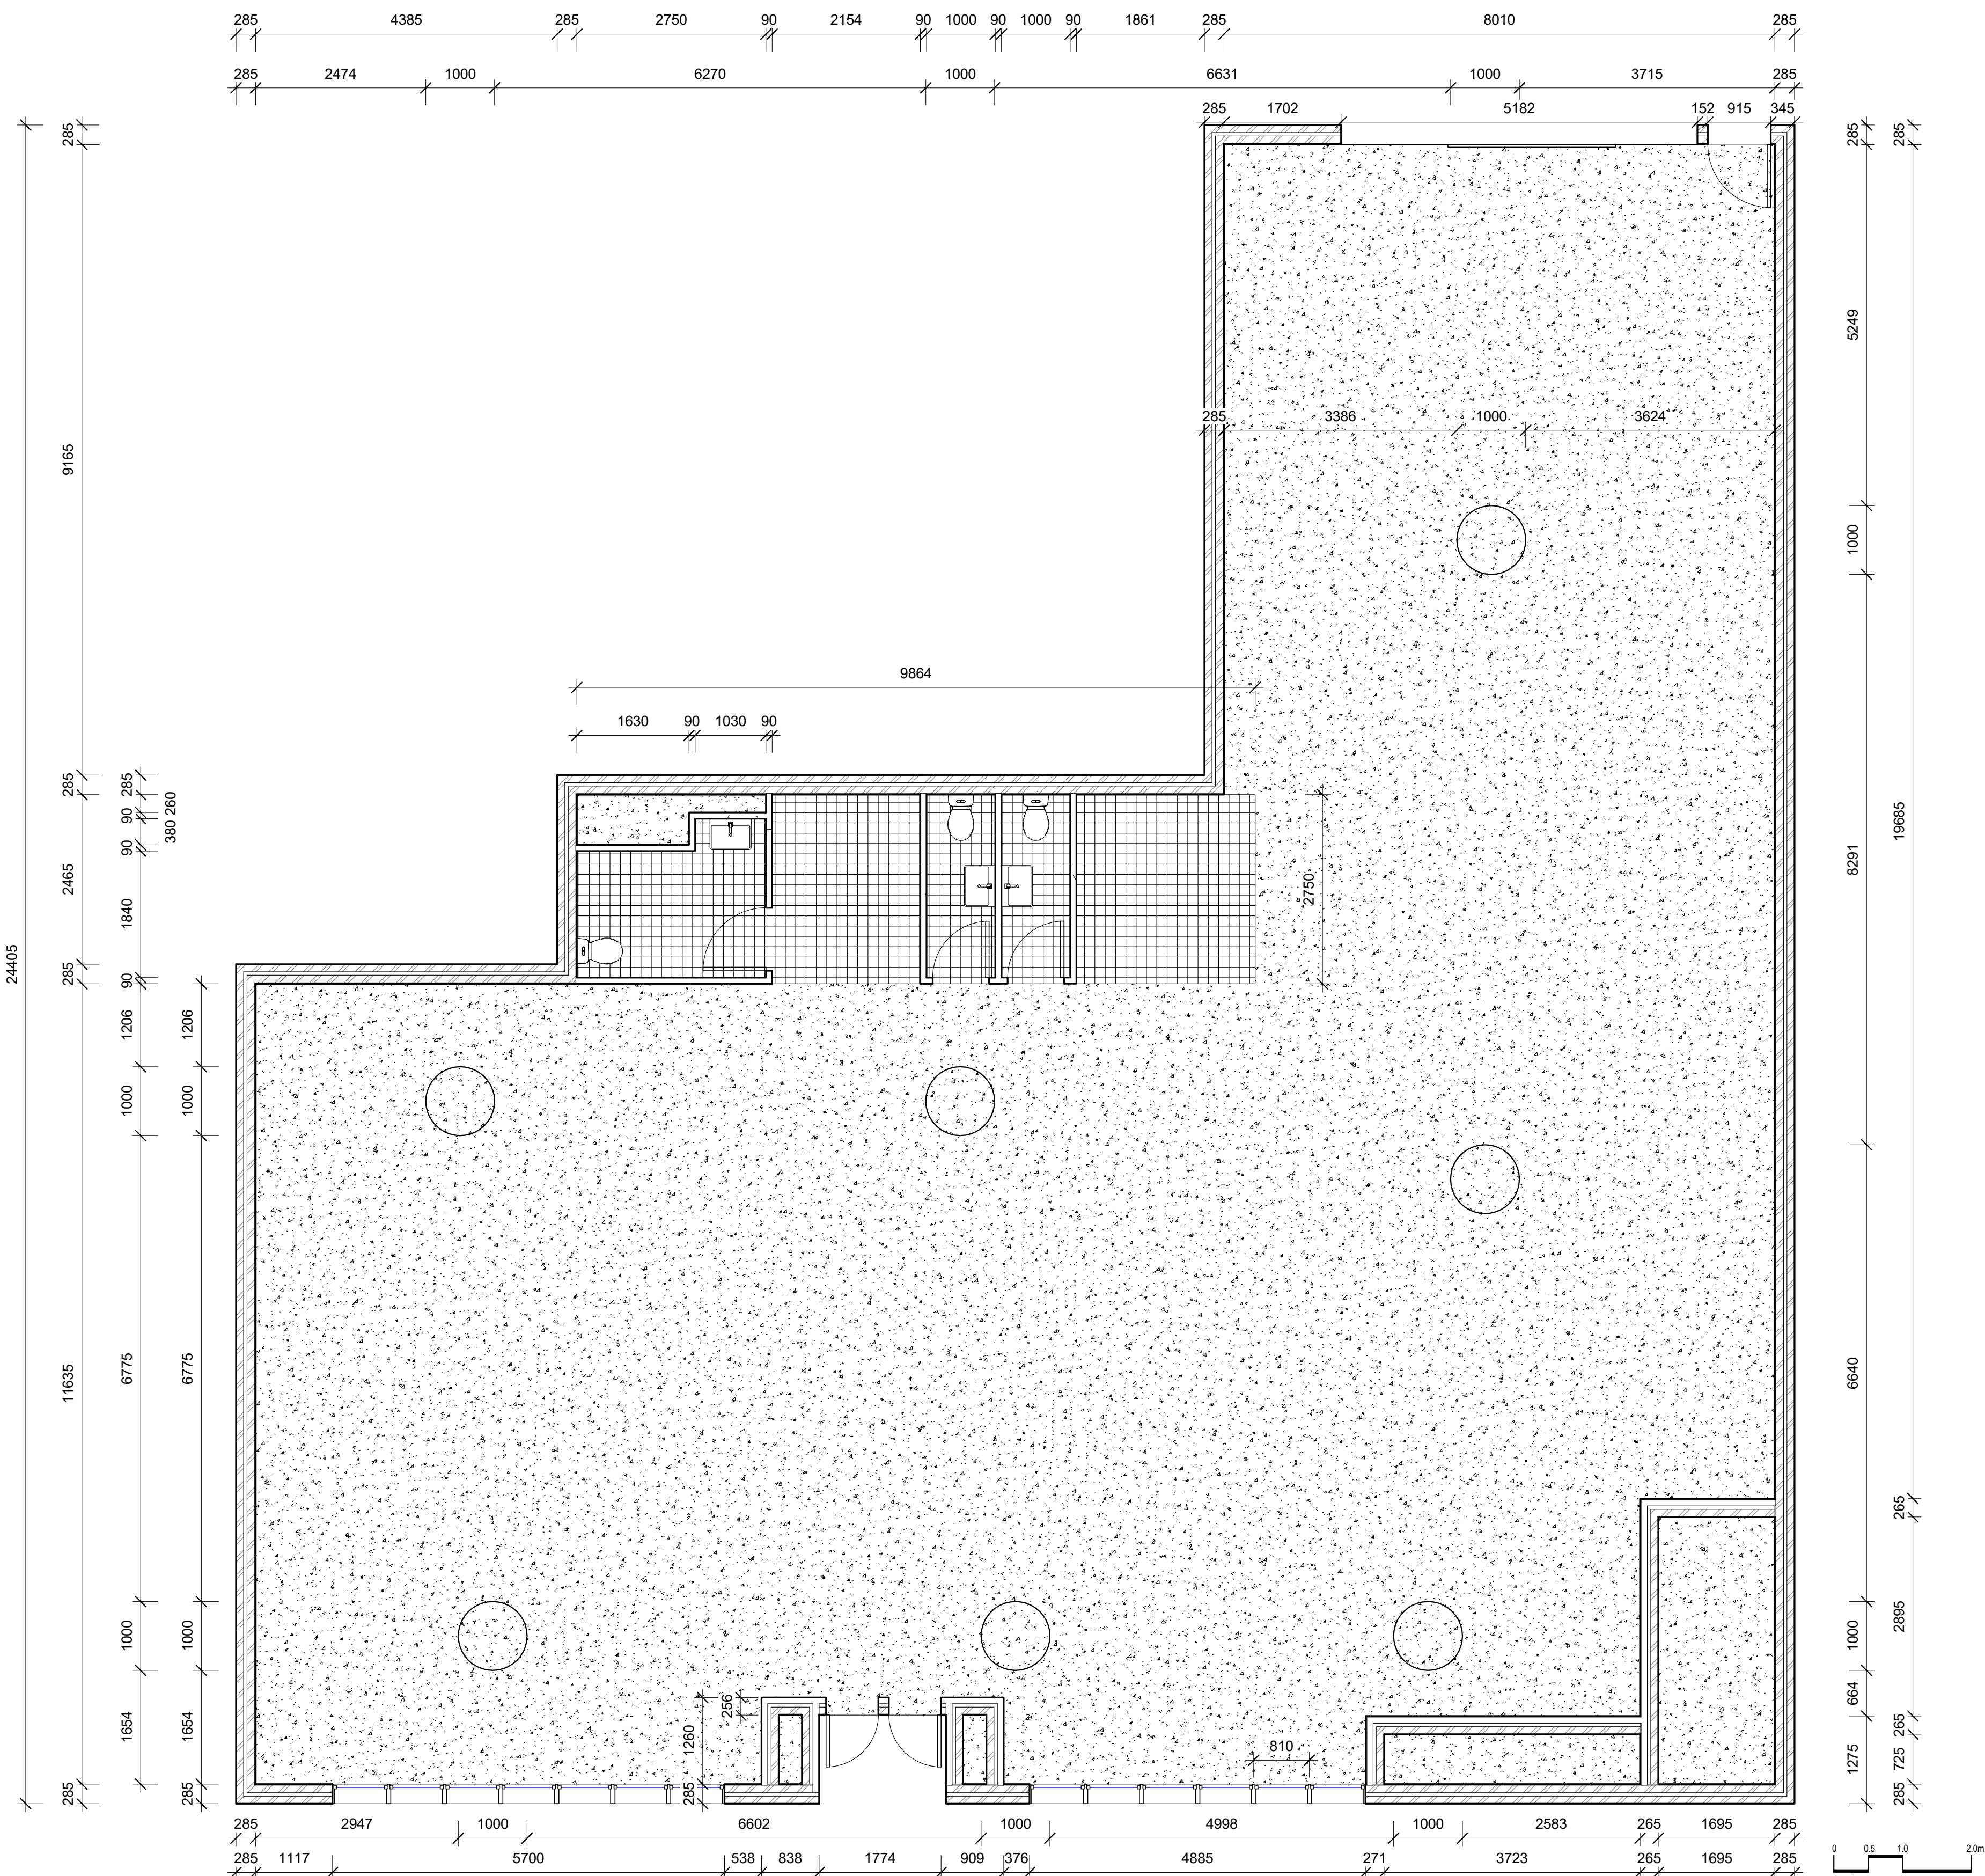

LEGEND

Cut Material

	Glass		Tiles
	Cedar		Plaster Board
	Concrete		Existing Structure
	Gym Mat		

Wall Types

	WT1	Timber stud wall 90mm x 45mm w/ 9mm Plaster board and 'Mountain Ash - Low sheen' Paint finish
	WT2	'Custom Frontline Green - Low sheen' Paint finish (1200mm H)
	WT3	Timber stud wall 90mm x 45mm w/ 12mm timber cedar top
	WT4	24mm Melamine (2400mm H)
	WT5	Timber stud wall 90mm x 45mm w/ 2mm glue + 6mm Bricklane tile
	WT6	Timber stud wall 90mm x 45mm w/ 2mm glue + 6mm square tile

Door Types

	DO1	915mm x 2134mm Flush w/ Blk Frame
	DO2	813mm x 2134mm Flush w/ Blk Frame
	DO3	762mm x 2000mm Toilet Cubicle Door
	DO4	915mm x 2134mm Glass w/ Blk Frame
	DO5	762mm x 2134mm Glass w/ Blk Frame

Window Types

	W01	815mm x 2850mm Frosted Glass w/ Blk Frame
	W02	815mm x 2210mm Glass w/ Blk Frame

Abbreviations

BLK	Black	SA	Sanitary
DO	Door	SS	Stainless Steel
EQ	Equipment	W0	Window
FI	Fixture	WT	Wall Type
FU	Furniture	W	With

Tag Legend

FU01 - 2x Medium Locker by Elite Office Furniture
FU02 - Chair by Coalesse 'Joel'
FU03 - Chair by Coalesse 'Sidewalk'
FU04 - 2 Seater Lounge by by Coalesse 'Sidewalk'
FU05 - Coffee table by Metro 'Toppo'
FU06 - Coffee table by Temple and Webster
FU07 - Office Chair by Coalesse 'Bindu'
FU08 - Reception Desk by Elite Office Furniture 'Casnan Premier Serrano Reception Counter'
FU09 - Office Desk by Modern Furniture 'Athan Executive Desk'
EQ01 - Drinking Fountain by Fitline 'FCG-107-14-HL-VF'
EQ02 - Treadmill by Nordic Track 'Sport 50'
EQ03 - Exercise bike by Nordic Track 'S10i Studio Bike'
EQ04 - Leg press by Aussie Fitness 'Gym King RS'
EQ05 - Gym Bench by Aussie Fitness 'Gym King Flat bench'
EQ06 - Squat Rack by Aussie Fitness 'Gym King Commercial Smith Machine'
EQ07 - Power Rack by Aussie Fitness 'Gym King Commercial Power Rack'
EQ08 - Dumbbell Rack by Commercial Fitness Equipment 'Titanium USA Monster Series'
EQ09 - Weight Rack by Sumo Strength 'barbarian Rack Package'
EQ10 - Sauna Panel by Jacuzzi Clearlight Saunas 'Custom Kit'
SA01 - Basin by Temple and Webster 'Tulip Wall Hung Basin'
SA02 - Toilet by Temple and Webster 'White Minna Rimless BTW'
SA03 - Shower Head by Temple and Webster '2 Piece Square Shower Head'
SA04 - Drain by Temple and Webster '11x11 Square Shower Grate Floor Drain'
SA05 - Disable toilet sign by Keeler Hardware 'AS1428 Compliant Toilet Sign SILVER Unisex Disabled'
SA10 - Bathroom mirror / dryer / soap by Bradley Australia 'Bradley behind mirror foam soap and hand dryer'
SA11 - Toilet Roll Holder by Estilo 'Chrome Bela Single roll Holder'
SA12 - Shower Mixer by The Blue Space 'Phoenix Vivid Slimline Shower/Wall Mixer'
SA13 - Toilet flush button by Icon Bathware 'Invisi Series II'
FI04 - Sled Track by Raw Fitness Equipment 'Custom Gym Sled'
LI01 - Light up Mirror by ATS Tiles and Bathroom 'Reti Rectangular LED Mirror'
LI02 - LED Logo by Big Banner
MA01 - Polished Concrete
MA02 - GYM MAT
MA03 - Custom Sled turf by Raw Fitness Equipment 'Custom Gym Sled'
MA04 - Brick Lane Tiles by National Tiles
MA05 - Paint finish by Porters Paints 'Mountain Ash'
MA06 - Paint finish by Porters Paints 'Custom Frontline Green'
MA07 - Tiles by National Tiles 'Zellige White Matt Tile'
MA08 - Paint finish by Porters Paints 'Anisced'
MA09 - Cedar Wood

REVISIONS

No Date
01 27.10.21

Description
PRESENTATION DRAWINGS
NOT FOR CONSTRUCTION

Ver. App'd
XX App'd

Do not scale drawings. Use figured dimensions only. Check and verify levels and dimensions on site prior to commencement of any work, the preparation of drawings or the fabrication of components.
This drawing is copyright and can not be reproduced without written consent.

Client

Moey Faour



Frontline Fitness
"LEADING FROM THE FRONT"

True North



Billy Blue College of Design
46-52 Mountain Street, Ultimo, NSW 2007,
Australia
+61 (0)2 9999 9999



LAUREATE INTERNATIONAL UNIVERSITIES

Project

Frontline Fitness

630 Canterbury Road,
Belmore, NSW. 2192

Project number

01

Drawing Title

Existing Plan

Drawing Status


PRESENTATION
DRAWINGS
NOT FOR
CONSTRUCTION

Scale Drawing No Issue
1 : 50 D01 01

Date 27.10.21

Drawn by MB

6/12/2021 3:51:05 AM

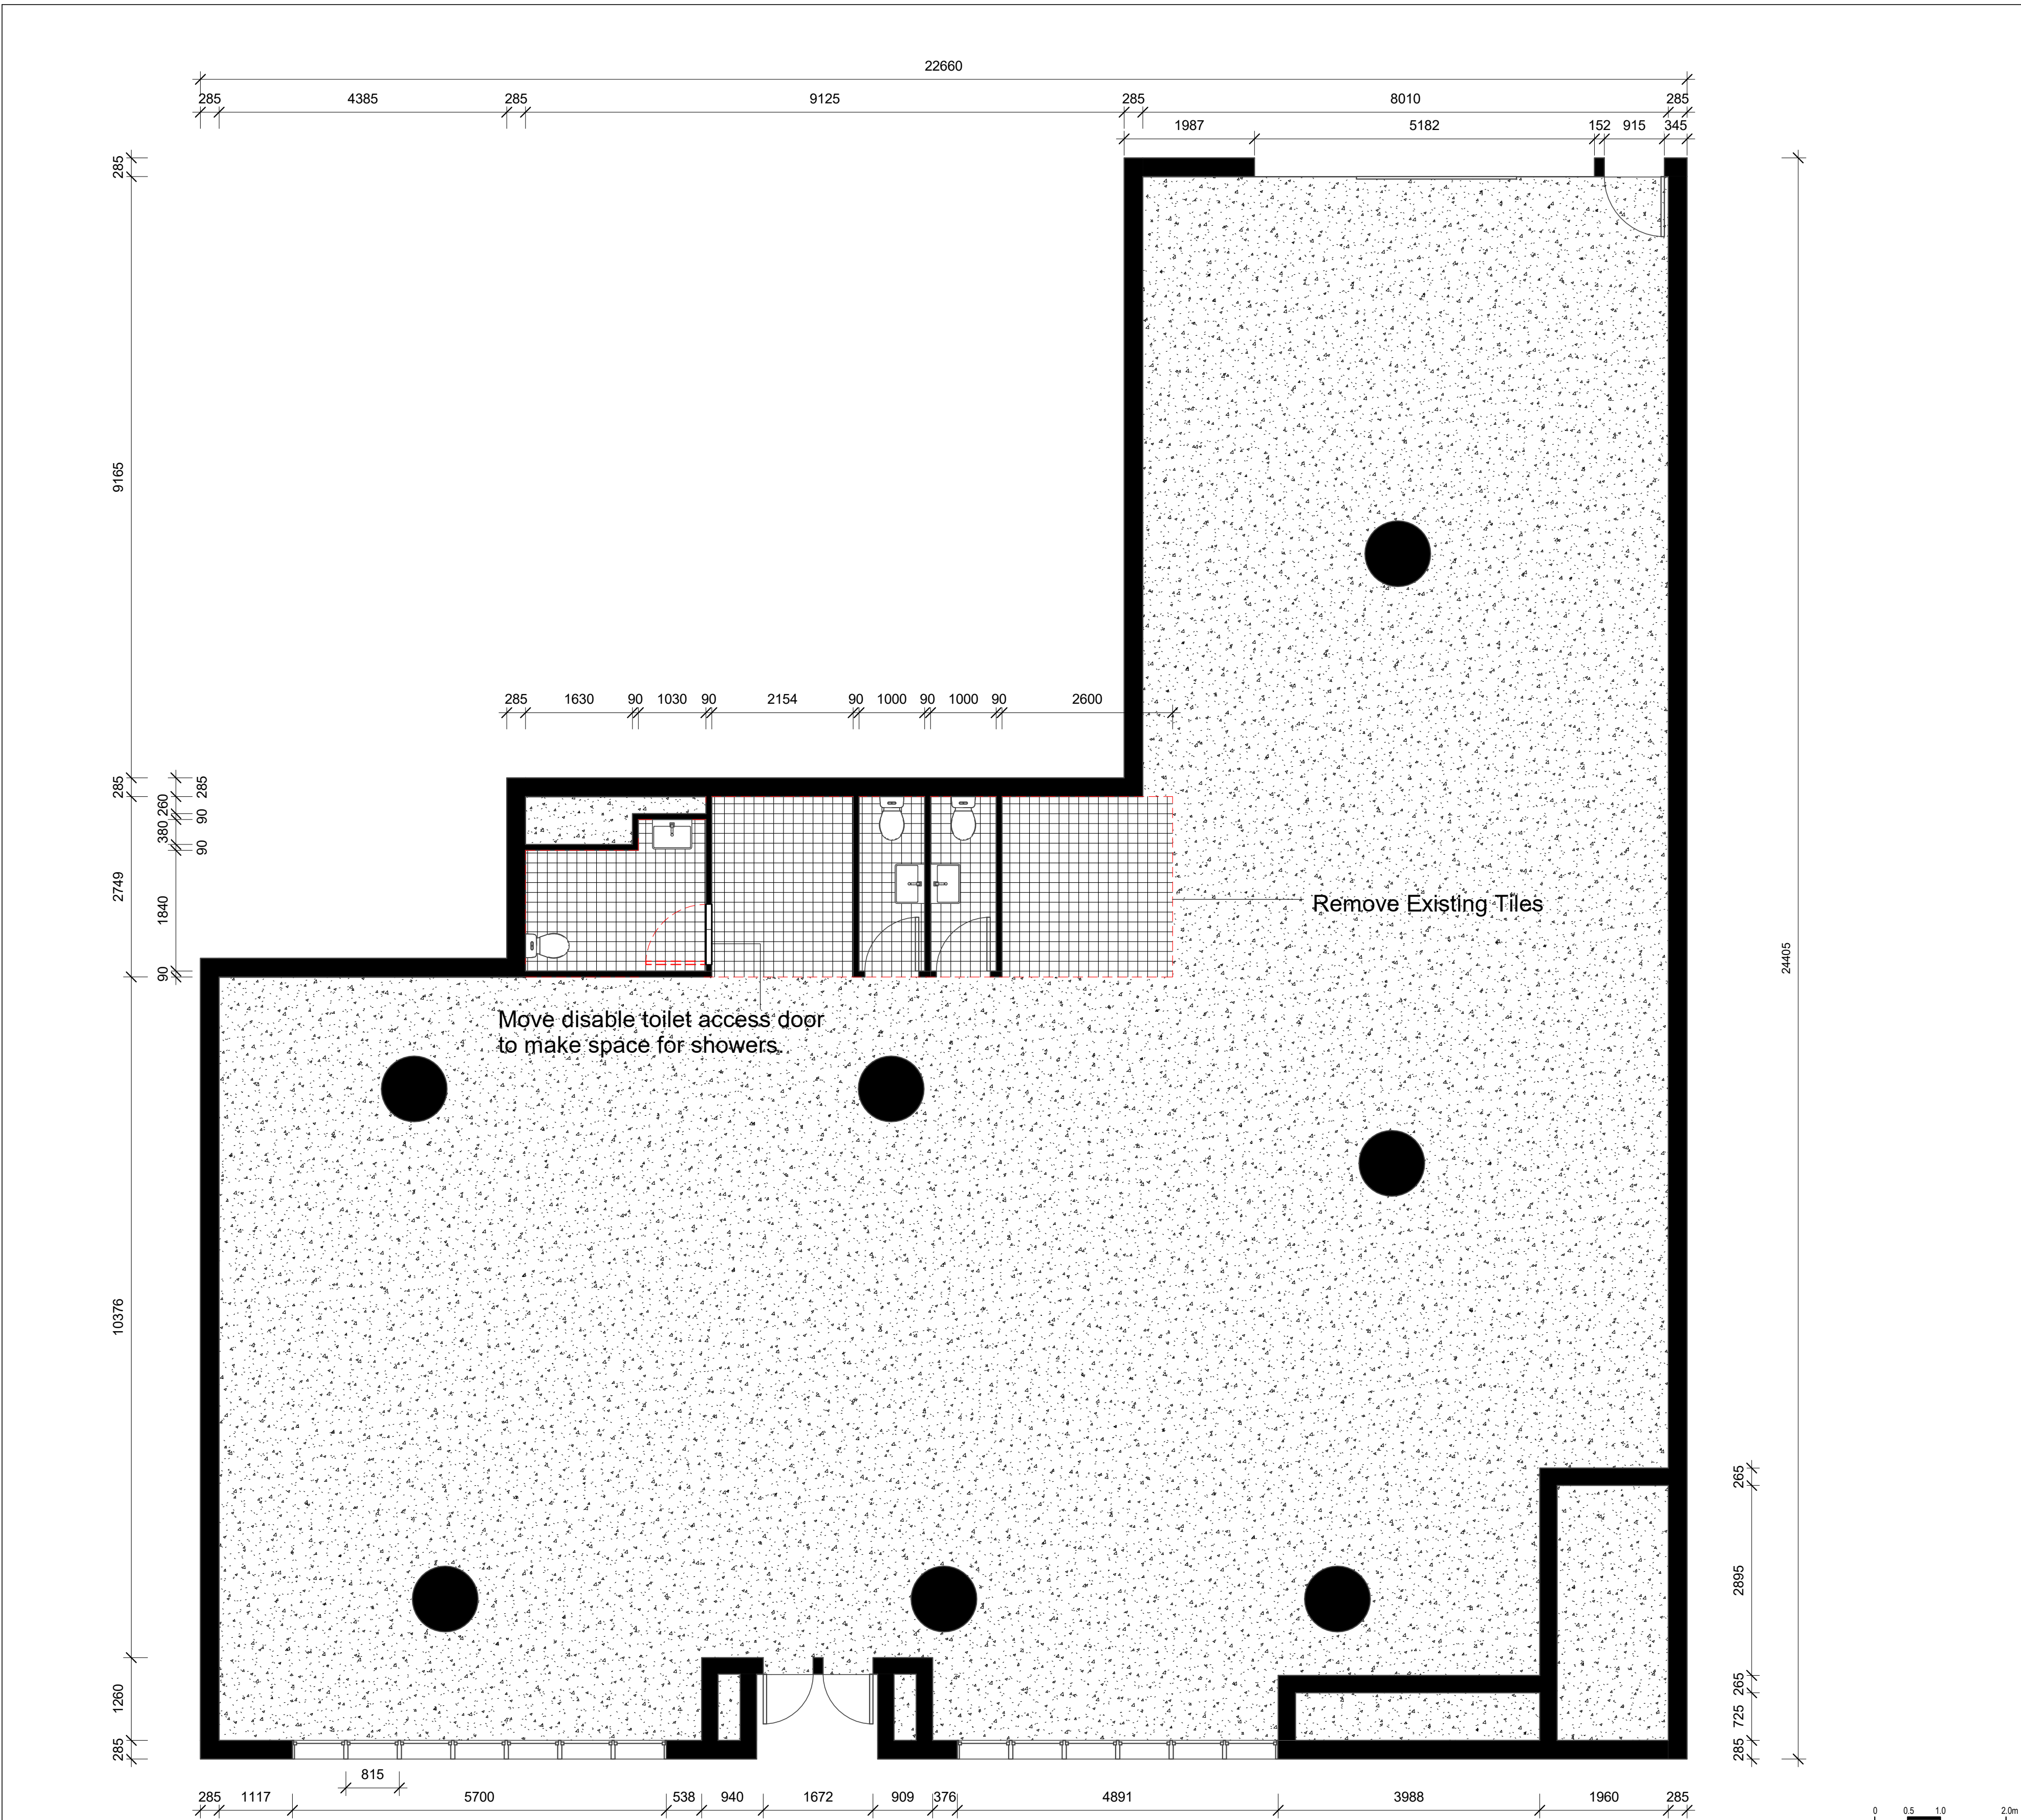

LEGEND

Cut Material

Glass

Cedar

Concrete

Gym Mat

Tiles

Plaster Board

Existing Structure

Wall Types

WT1

WT2

WT3

WT4

WT5

WT6

Timber stud wall 90mm x 45mm w/ 9mm Plaster board and 'Mountain Ash - Low sheen' Paint finish

'Custom Frontline Green - Low sheen' Paint finish (1200mm H)

Timber stud wall 90mm x 45mm w/ 12mm timber cedar top

24mm Melamine (2400mm H)

Timber stud wall 90mm x 45mm w/ 2mm glue + 6mm Bricklane tile

Timber stud wall 90mm x 45mm w/ 2mm glue + 6mm square tile

Door Types

DO1

DO2

DO3

DO4

DO5

915mm x 2134mm Flush w/ Blk Frame

813mm x 2134mm Flush w/ Blk Frame

762mm x 2000mm Toilet Cubicle Door

915mm x 2134mm Glass w/ Blk Frame

762mm x 2134mm Glass w/ Blk Frame

Window Types

W01

W02

815mm x 2850mm Frosted Glass w/ Blk Frame

815mm x 2210mm Glass w/ Blk Frame

Abbreviations

BLK - Black

D0 - Door

EQ - Equipment

FI - Fixture

FU - Furniture

SA - Sanitary

SS - Stainless Steel

WO - Window

WT - Wall Type

W/ - With

Tag Legend

FU01 - 2x Medium Locker by Elite Office Furniture

FU02 - Chair by Coalesse 'Joni'

FU03 - Chair by Coalesse 'Sidewalk'

FU04 - 2 Seater Lounge by by Coalesse 'Sidewalk'

FU05 - Coffee table by Metro 'Topo'

FU06 - Coffee table by Temple and Webster

FU07 - Office Chair by Coalesse 'Bridu'

FU08 - Reception Desk by Elite Office Furniture 'Casnan Premier Sonento Reception Counter'

FU09 - Office Desk by Modern Furniture 'Aftan Executive Desk'

EQ01 - Drinking Fountain by Filtrine 'FCC-107-14-HL-VP'

EQ02 - 'Treadmill by Nordic Track 'Sport 50'

EQ03 - Exercise bike by Nordic Track 'S10i Studio Bike'

EQ04 - Leg press by Aussie Fitness 'Gym King HS'

EQ05 - Gym Bench by Aussie Fitness 'Gym King Flat bench'

EQ06 - Squat Rack by Aussie Fitness 'Gym King Commercial Smith Machine'

EQ07 - Power Rack by Aussie Fitness 'Gym King Commercial Power Rack'

EQ08 - Dumbbell Rack by Commercial Fitness Equipment 'Titanium USA Monster Series'

EQ09 - Weight Rack by Sumo Strengh't 'barbarian Rack Package'

EQ10 - Sauna Panel by Jacuzzi Clearlight Saunas 'Custom Kit'

SA01 - Basin by Temple and Webster 'Tulip Wall Hung Basin'

SA02 - Toilet by Temple and Webster 'White Minna Rimless

BTW - Shower Head by Temple and Webster '2 Piece Square Shower Head'

SA04 - Drain by Temple and Webster '11x11 Square Shower Grate Floor Drain'

SA06 - Disable toilet sign by Keeler Hardware 'AS1428 Compliant Toilet Sign SILVER Unisex Disabled'

SA10 - Bathroom mirror / dryer / soap by Bradley Australia 'Bradley behind mirror foam soap and hand dryer'

SA11 - Toilet Roll Holder by Estlio 'Chroma Beta Single roll Holder

SA12 - Shower Mixer by The Blue Space 'Phoenix Vivid Slimline Shower/Wall Mixer'

SA13 - Toilet flush button by Icon Bathware 'Invisi Series II'

F104 - Sled Track by Raw Fitness Equipment 'Custom Gym Sled'

L01 - Light up Mirror by ATS Tiles and Bathroom 'Retti Rectangular LED Mirror'

L02 - LED Logo by Big Banner

MA01 - Polished Concrete

MA02 - GYM MAT

MA03 - Custom Sled surf by Raw Fitness Equipment 'Custom Gym Sled'

MA04 - Brick Lane Tiles by National Tiles

MA05 - Paint finish by Porters Paints 'Mountain Ash'

MA06 - Paint finish by Porters Paints 'Custom Frontline Green'

MA07 - Tiles by National Tiles 'Zellige White Matt Tile'

MA08 - Paint finish by Porters Paints 'Anisced'

MA09 - Cedar Wood

REVISIONS

No Date

01 27.10.21

Description

PRESENTATION DRAWINGS NOT FOR CONSTRUCTION

Ver. App'd

XX App'd

Do not scale drawings. Use figured dimensions only. Check and verify levels and dimensions on site prior to commencement of any work, the preparation of drawings or the fabrication of components. This drawing is copyright and can not be reproduced without written consent.

Client

Moey Faour

Frontline Fitness

LEADING FROM THE FRONT

True North

Billy Blue College of Design

46-52 Mountain Street, Ultimo, NSW 2007, Australia

+61 (0)2 9999 9999

BILLY BLUE

COLLEGE OF DESIGN

TORRENS

UNIVERSITY

AUSTRALIA

LAUREATE INTERNATIONAL UNIVERSITIES

Project

Frontline Fitness

630 Canterbury Road, Belmore, NSW. 2192

Project number

01

Drawing Title

Demolition Plan

Drawing Status

PRESENTATION DRAWINGS NOT FOR CONSTRUCTION

Scale

1 : 50

Drawing No

D02

Issue

01

Date


27.10.21

Drawn by

MB

6/12/2021 3:51:17 PM

A1

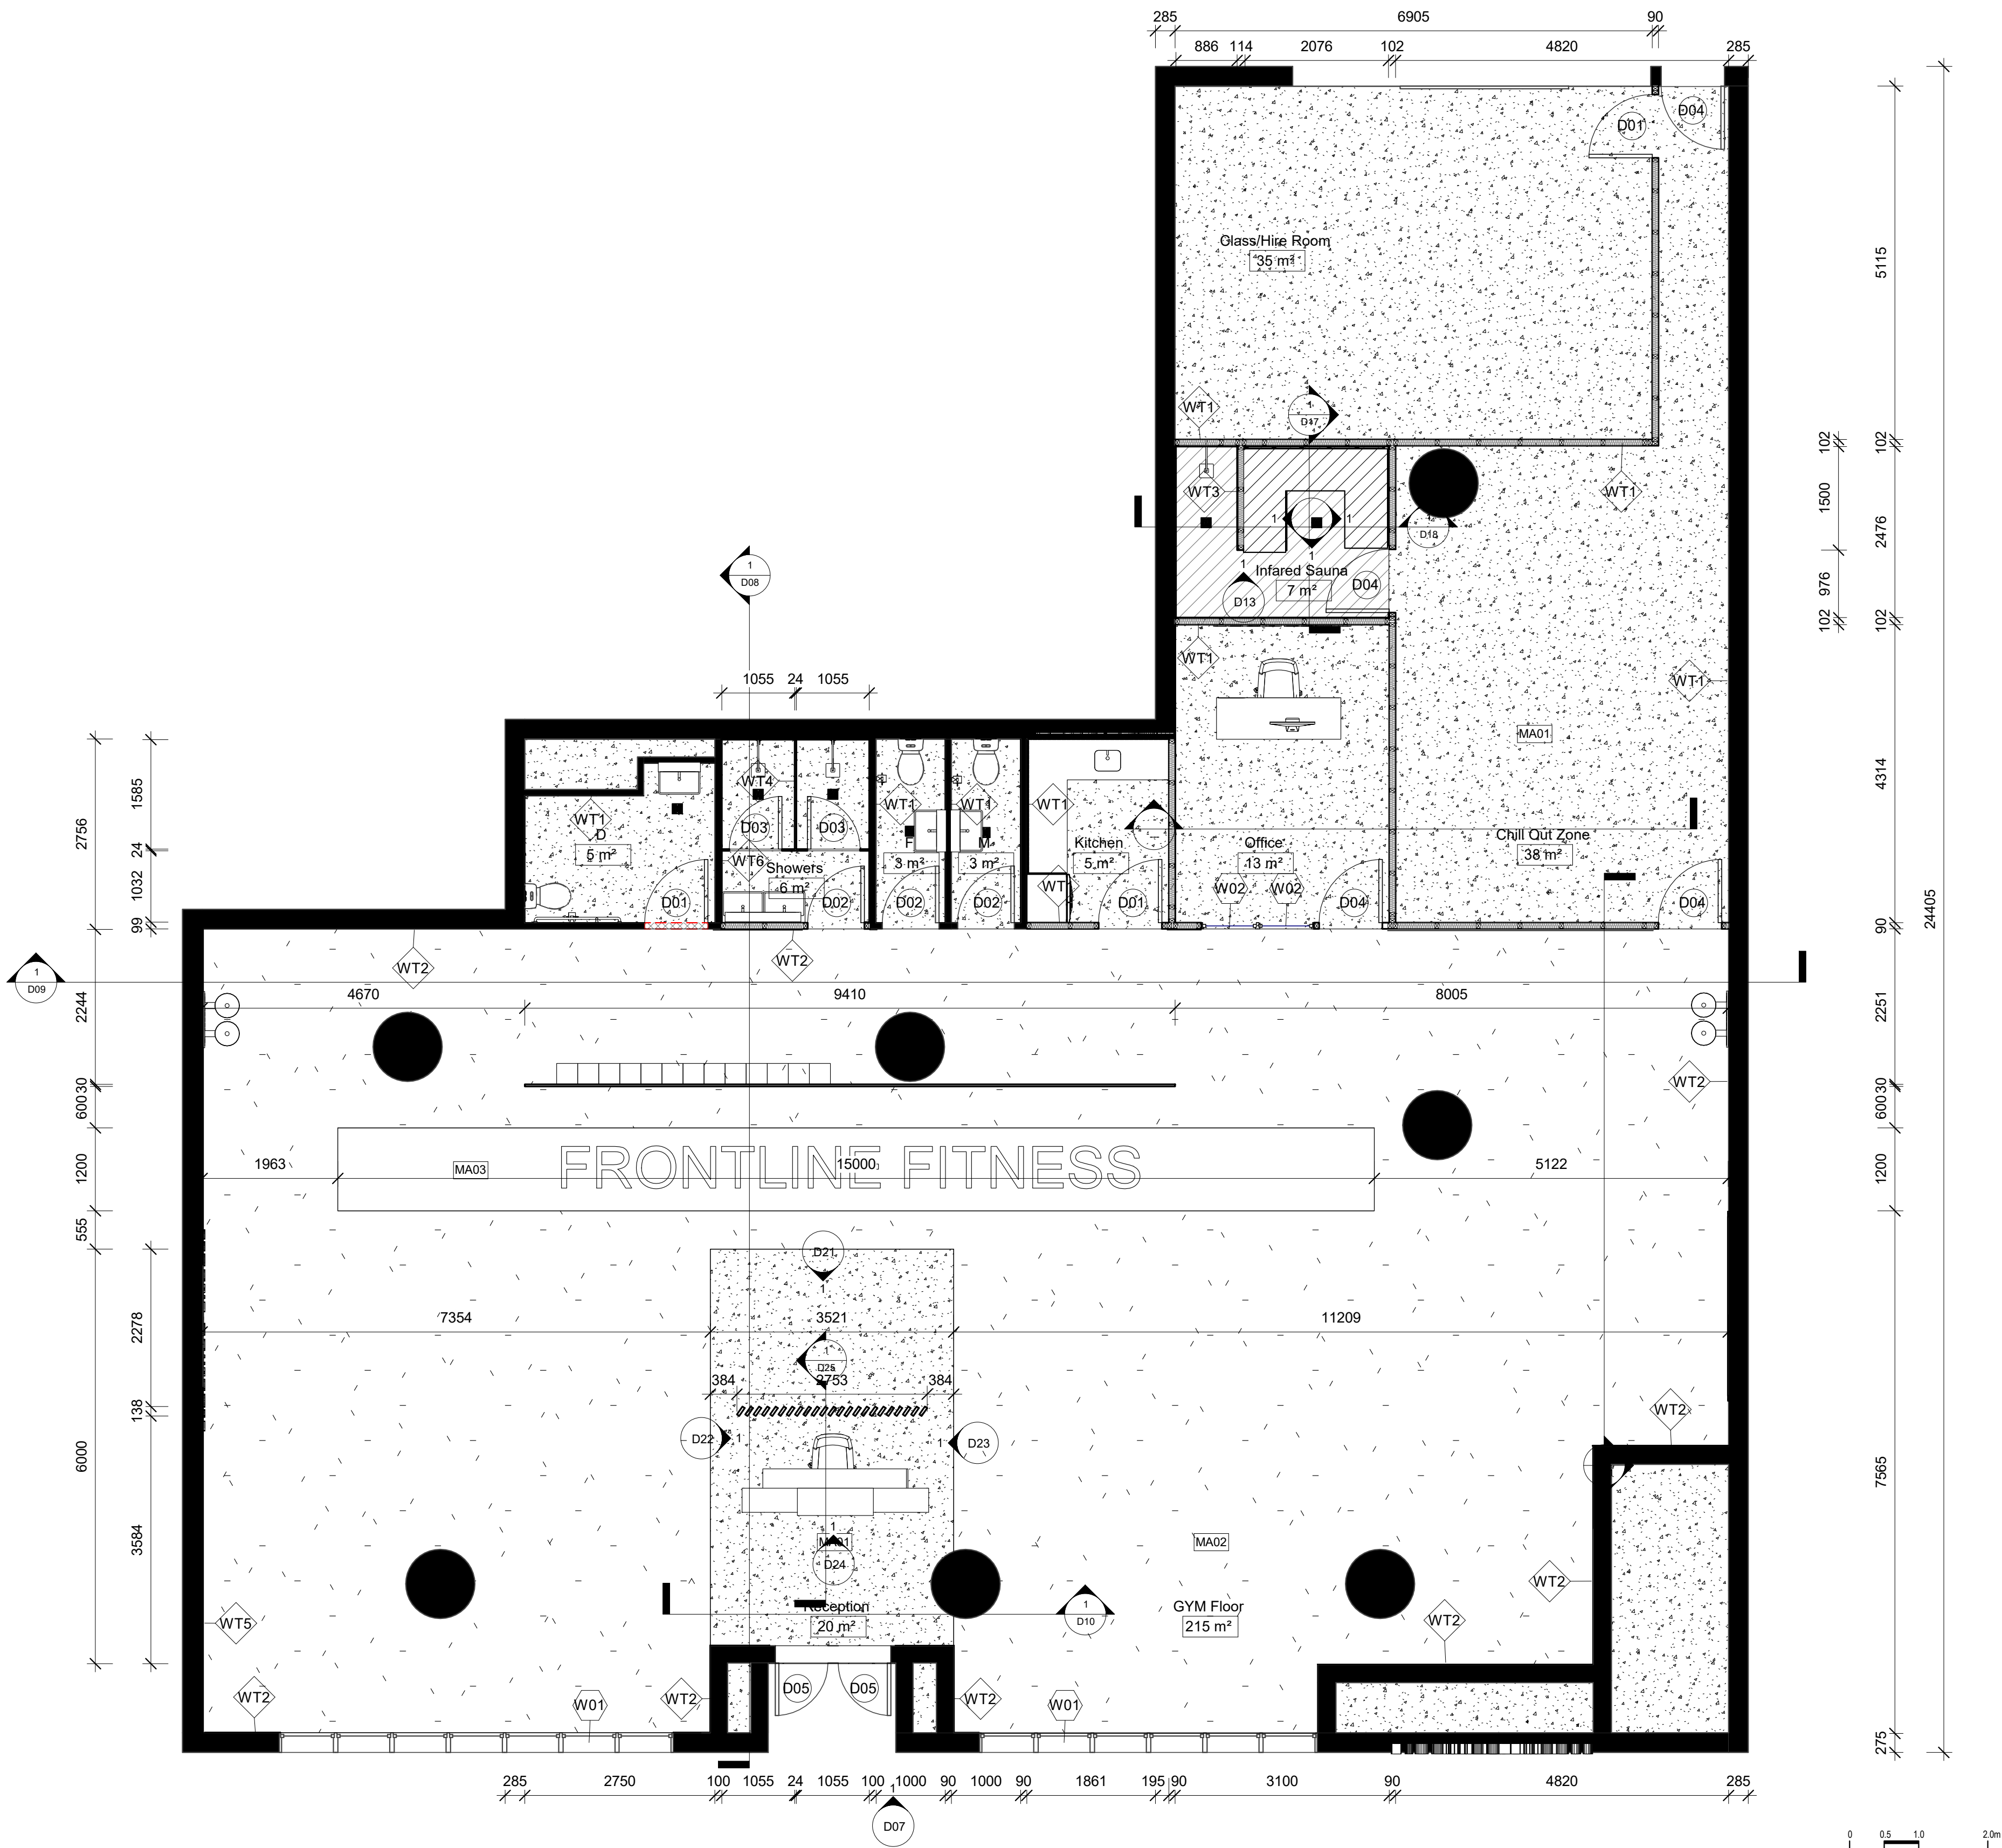

LEGEND

Cut Material

	Glass		Tiles
	Cedar		Plaster Board
	Concrete		Existing Structure
	Gym Mat		

Wall Types

	Timber stud wall 90mm x 45mm w/ 9mm Plaster board and 'Mountain Ash' - Low sheen' Paint finish
	'Custom Frontline Green' - Low sheen' Paint finish (1200mm H)
	Timber stud wall 90mm x 45mm w/ 12mm timber cedar top
	24mm Melamine (2400mm H)
	Timber stud wall 90mm x 45mm w/ 2mm glue + 6mm Bricklane tile
	Timber stud wall 90mm x 45mm w/ 2mm glue + 6mm square tile

Door Types

	915mm x 2134mm Flush w/ Blk Frame
	813mm x 2134mm Flush w/ Blk Frame
	762mm x 2000mm Toilet Cubicle Door
	915mm x 2134mm Glass w/ Blk Frame
	762mm x 2134mm Glass w/ Blk Frame

Window Types

	815mm x 2850mm Frosted Glass w/ Blk Frame
	815mm x 2210mm Glass w/ Blk Frame

Abbreviations

BLK	Black	SA	Sanitary
D0	Door	SS	Stainless Steel
EQ	Equipment	W0	Window
FI	Fixture	WT	Wall Type
FU	Furniture	W/	With

Tag Legend

FU01 - 2x Medium Locker by Elite Office Furniture
FU02 - Chair by Colesse 'Joel'
FU03 - Chair by Colesse 'Sidewalk'
FU04 - 2 Seater Lounge by Colesse 'Sidewalk'
FU05 - Coffee table by Metro 'Topo'
FU06 - Coffee table by Temple and Webster
FU07 - Office Chair by Colesse 'Tendu'
FU08 - Reception Desk by Elite Office Furniture 'Casnan Premier Sorrento Reception Counter'
FU09 - Office Desk by Modern Furniture 'Aftan Executive Desk'
EQ01 - Drinking Fountain by Filtrine 'FCC-107-14-HL-VIP'
EQ02 - Treadmill by Nordic Track 'Sport 50'
EQ03 - Exercise bike by Nordic Track 'S10 Studio Bike'
EQ04 - Leg press by Aussie Fitness 'Gym King HS'
EQ05 - Gym Bench by Aussie Fitness 'Gym King Flat bench'
EQ06 - Squat Rack by Aussie Fitness 'Gym King Commercial Smith Machine'
EQ07 - Power Rack by Aussie Fitness 'Gym King Commercial Power Rack'
EQ08 - Dumbbell Rack by Commercial Fitness Equipment 'Titanium USA Monster Series'
EQ09 - Weight Rack by Sumo Strength 'barbarian Rack Package'
EQ10 - Sauna Panel by Jacuzzi Clearlight Saunas 'Custom Kit'
SA01 - Basin by Temple and Webster 'Tulip Wall Hung Basin'
SA02 - Toilet by Temple and Webster 'White Minna Rimless BTW'
SA03 - Shower Head by Temple and Webster '2 Piece Square Shower Head'
SA04 - Drain by Temple and Webster '11x11 Square Shower Grate Floor Drain'
SA05 - Disable toilet sign by Keeler Hardware 'AS1428 Compliant Toilet Sign SILVER Unisex Disabled'
SA10 - Bathroom mirror / dryer / soap by Bradley Australia 'tandley behind mirror foam soap and hand dryer'
SA11 - Toilet Roll Holder by Estlio 'Chrome Bela Single roll Holder'
SA12 - Shower Mixer by The Blue Space 'Phoenix Vivid Slimline Shower/Wall Mixer'
SA13 - Toilet flush button by Icon Bathware 'Invisi Series II'
F104 - Sled Track by Raw Fitness Equipment 'Custom Gym Sled'
LI01 - Light up Mirror by ATS Tiles and Bathroom 'Reti Rectangular LED Mirror'
LI02 - LED Logo by Big Banner
MA01 - Polished Concrete
MA02 - GYM MAT
MA03 - Custom Sled turf by Raw Fitness Equipment 'Custom Gym Sled'
MA04 - Brick Lane Tiles by National Tiles
MA05 - Paint finish by Porters Paints 'Mountain Ash'
MA06 - Paint finish by Porters Paints 'Custom Frontline Green'
MA07 - Tiles by National Tiles 'Zellige White Matt Tile'
MA08 - Paint finish by Porters Paints 'Anisced'
MA09 - Cedar Wood

REVISIONS

No Date
01 27.10.21

Description
PRESENTATION DRAWINGS
NOT FOR CONSTRUCTION

Ver. App'd
XX App'd

Do not scale drawings. Use figured dimensions only. Check and verify levels and dimensions on site prior to commencement of any work, the preparation of drawings or the fabrication of components.
This drawing is copyright and can not be reproduced without written consent.

Client

Moey Faour



Frontline Fitness
"LEADING FROM THE FRONT"

True North



Billy Blue College of Design
46-52 Mountain Street, Ultimo, NSW 2007,
Australia
+61 (0)2 9999 9999



LAUREATE INTERNATIONAL UNIVERSITIES

Project

Frontline Fitness

630 Canterbury Road,
Belmore, NSW. 2192

Project number
01

Drawing Title

Proposed Floor Plan

Drawing Status


PRESENTATION
DRAWINGS
NOT FOR
CONSTRUCTION

Scale Drawing No Issue
1 : 50 D03 01

Date 27.10.21

Drawn by MB

6/12/2021 3:51:28 AM

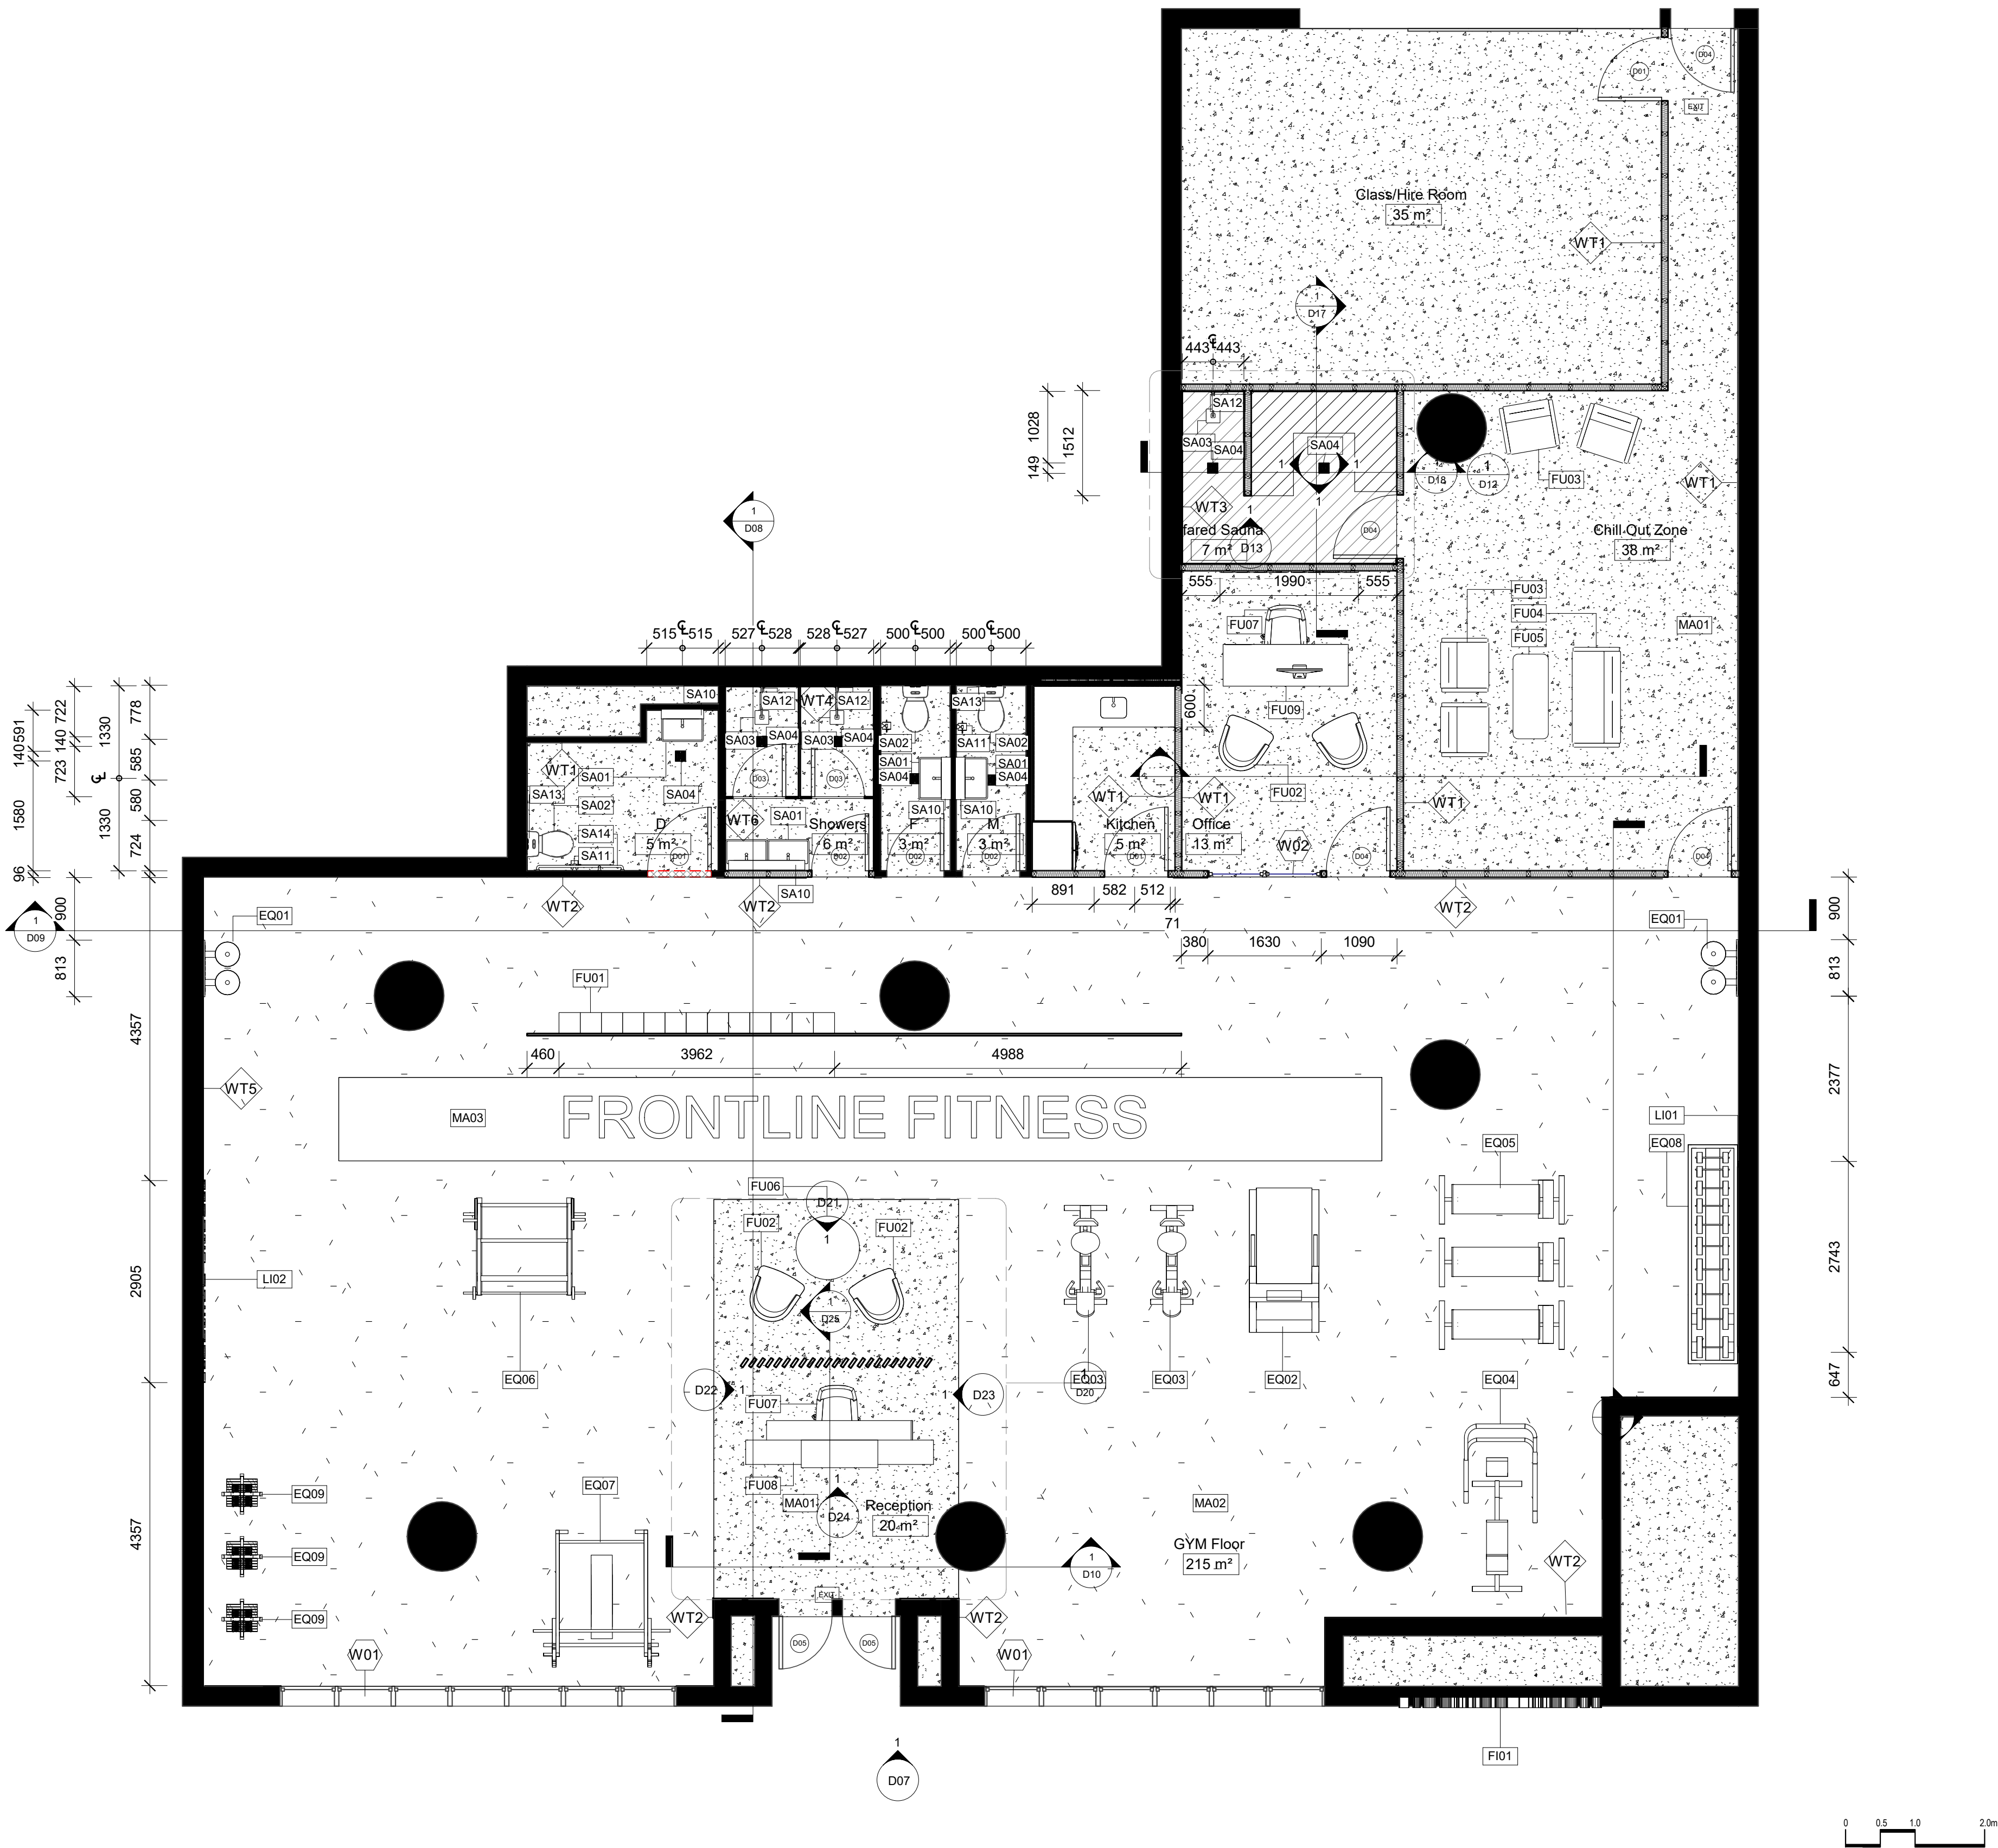

LEGEND

Cut Material

	Glass		Tiles
	Cedar		Plaster Board
	Concrete		Existing Structure
	Gym Mat		

Wall Types

	Timber stud wall 90mm x 45mm w/ 9mm Plaster board and 'Mountain Ash - Low sheen' Paint finish
	'Custom Frontline Green - Low sheen' Paint finish (1200mm H)
	Timber stud wall 90mm x 45mm w/ 12mm timber cedar top
	24mm Melamine (2400mm H)
	Timber stud wall 90mm x 45mm w/ 2mm glue + 6mm Bricklane tile
	Timber stud wall 90mm x 45mm w/ 2mm glue + 6mm square tile

Door Types

	915mm x 2134mm Flush w/ Blk Frame
	813mm x 2134mm Flush w/ Blk Frame
	762mm x 2000mm Toilet Cubicle Door
	915mm x 2134mm Glass w/ Blk Frame
	762mm x 2134mm Glass w/ Blk Frame

Window Types

	815mm x 2850mm Frosted Glass w/ Blk Frame
	815mm x 2210mm Glass w/ Blk Frame

Abbreviations

BLK	Black	SA	Sanitary
D0	Door	SS	Stainless Steel
EQ	Equipment	W0	Window
FI	Fixture	WT	Wall Type
FU	Furniture	W	With

Tag Legend

FU01 - 2x Medium Locker by Elite Office Furniture
FU02 - Chair by Coalesse 'Jost'
FU03 - Chair by Coalesse 'Sidewalk'
FU04 - 2 Seater Lounge by by Coalesse 'Sidewalk'
FU05 - Coffee table by Metro 'Topo'
FU06 - Coffee table by Temple and Webster
FU07 - Office Chair by Coalesse 'Bridle'
FU08 - Reception Desk by Elite Office Furniture 'Casnan Premier Sorrento Reception Counter'
FU09 - Office Desk by Modern Furniture 'Aftan Executive Desk'
EQ01 - Drinking Fountain by Fitline 'FCO-107-14-HL-VF'
EQ02 - Treadmill by Nordic Track 'Sport 50'
EQ03 - Exercise bike by Nordic Track '310 Studio Bike'
EQ04 - Leg press by Aussie Fitness 'Gym King HS'
EQ05 - Gym Bench by Aussie Fitness 'Gym King Flat bench'
EQ06 - Squat Rack by Aussie Fitness 'Gym King Commercial Smith Machine'
EQ07 - Power Rack by Aussie Fitness 'Gym King Commercial Power Rack'
EQ08 - Dumbel Rack by Commercial Fitness Equipment 'Titanium USA Monster Series'
EQ09 - Weight Rack by Sumo Strength 'barbarian Rack Package'
EQ10 - Sauna Panel by Jacuzzi Clearlight Saunas 'Custom Kit'
SA01 - Basin by Temple and Webster 'Tulip Wall Hung Basin'
SA02 - Toilet by Temple and Webster 'White Minna Rimless BTW'
SA03 - Shower Head by Temple and Webster '2 Piece Square Shower Head'
SA04 - Drain by Temple and Webster '11x11 Square Shower Grate Floor Drain'
SA08 - Disable toilet sign by Keeler Hardware 'AS1428 Compliant Toilet Sign SILVER Unisex Disabled'
SA10 - Bathroom mirror / dryer / soap by Bradley Australia 'Bradley behind mirror foam soap and hand dryer'
SA11 - Toilet Roll Holder by Estilo 'Chrome Beta Single roll Holder'
SA12 - Shower Mixer by The Blue Space 'Phoenix Vivid Slimline Shower/Wall Mixer'
SA13 - Toilet flush button by Icon Bathware 'Invisal Series II'
FI04 - Sled Track by Raw Fitness Equipment 'Custom Gym Sled'
LI01 - Light up Mirror by ATS Tiles and Bathroom 'Reti Rectangular LED Mirror'
LI02 - LED Logo by Big Banner
MA01 - Polished Concrete
MA02 - GYM MAT
MA03 - Custom Sled turf by Raw Fitness Equipment 'Custom Gym Sled'
MA04 - Brick Lane Tiles by National Tiles
MA05 - Paint finish by Porters Paints 'Mountain Ash'
MA06 - Paint finish by Porters Paints 'Custom Frontline Green'
MA07 - Tiles by National Tiles 'Zellige White Matt Tile'
MA08 - Paint finish by Porters Paints 'Anisced'
MA09 - Cedar Wood

REVISIONS

No Date
01 27.10.21

Description
PRESENTATION DRAWINGS
NOT FOR CONSTRUCTION

Ver. App'd
XX App'd

Do not scale drawings. Use figured dimensions only. Check and verify levels and dimensions on site prior to commencement of any work, the preparation of drawings or the fabrication of components.
This drawing is copyright and can not be reproduced without written consent.

Client
Moey Faour



Frontline Fitness
"LEADING FROM THE FRONT"

True North



Billy Blue College of Design
46-52 Mountain Street, Ultimo, NSW 2007, Australia
+61 (0)2 9999 9999



LAUREATE INTERNATIONAL UNIVERSITIES

Project

Frontline Fitness

630 Canterbury Road,
Belmore, NSW. 2192

Project number
01

Drawing Title

Proposed Furniture Plan

Drawing Status

PRESENTATION
DRAWINGS
NOT FOR
CONSTRUCTION


Scale Drawing No Issue
1 : 50 D04 01

Date 27.10.21

Drawn by MB

6/12/2021 4:05:39 AM

Electrical Legend			
	Single Receptacle Outlet		Wall-Mounted Light Fixture
	Double Receptacle Outlet		Fire Alarm Panel
	Double Waterproof Receptacle Outlet		Data Access Point
	Double Floor Mounted Outlet		

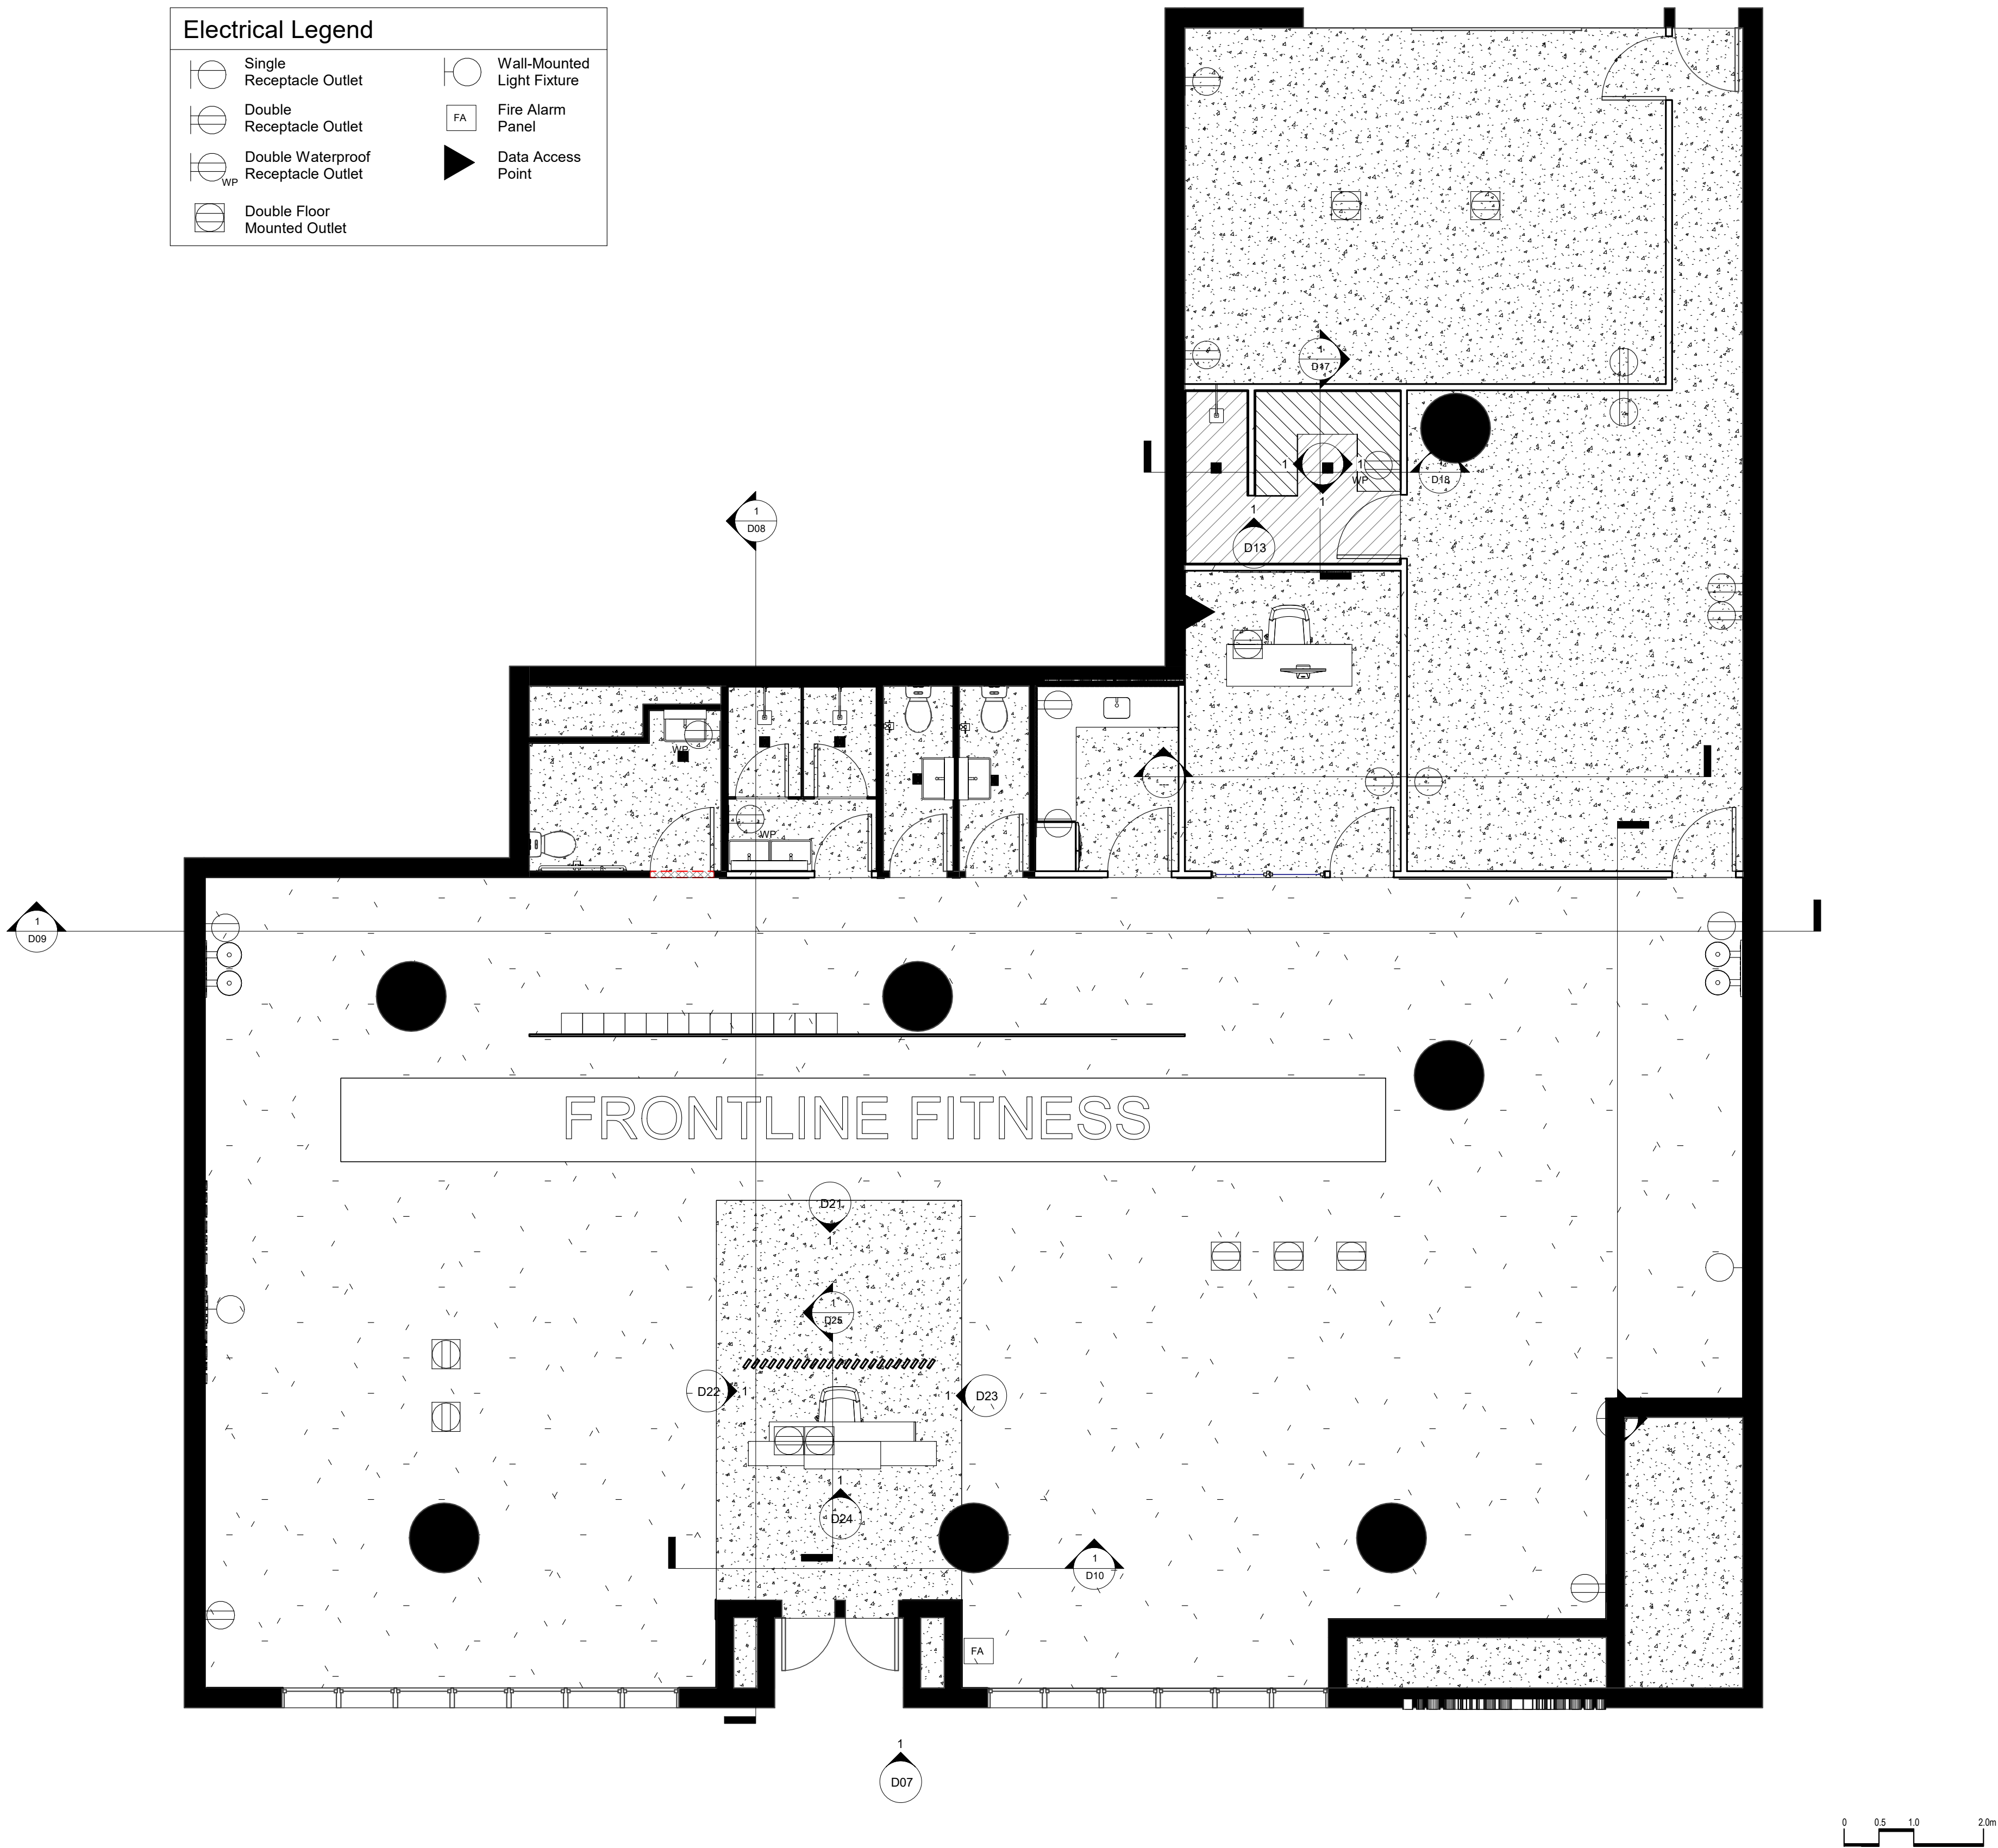

LEGEND

Cut Material	
	Glass
	Cedar
	Concrete
	Gym Mat
	Tiles
	Plaster Board
	Existing Structure

Wall Types

	Timber stud wall 90mm x 45mm w/ 9mm Plaster board and Mountain Ash - Low sheen' Paint finish
	'Custom Frontline Green - Low sheen' Paint finish (1200mm H)
	Timber stud wall 90mm x 45mm w/ 12mm timber cedar top
	24mm Melamine (2400mm H)
	Timber stud wall 90mm x 45mm w/ 2mm glue + 6mm Bricklane tile
	Timber stud wall 90mm x 45mm w/ 2mm glue + 6mm square tile

Door Types

	915mm x 2134mm Flush w/ Blk Frame
	813mm x 2134mm Flush w/ Blk Frame
	762mm x 2000mm Toilet Cubicle Door
	915mm x 2134mm Glass w/ Blk Frame
	762mm x 2134mm Glass w/ Blk Frame

Window Types

	815mm x 2850mm Frosted Glass w/ Blk Frame
	815mm x 2210mm Glass w/ Blk Frame

Abbreviations

BLK	Black	SA	Sanitary
D0	Door	SS	Stainless Steel
EQ	Equipment	W0	Window
FI	Fixture	WT	Wall Type
FU	Furniture	WI	With

Tag Legend

FU01 - 2x Medium Locker by Elite Office Furniture
FU02 - Chair by Colesse 'Joel'
FU03 - Chair by Colesse 'Sidewalk'
FU04 - 2 Seater Lounge by by Colesse 'Sidewalk'
FU05 - Coffee table by Metro 'Topo'
FU06 - Coffee table by Temple and Webster
FU07 - Office Chair by Colesse 'Bindu'
FU08 - Reception Desk by Elite Office Furniture 'Casnan Premier Sorrento Reception Counter'
FU09 - Office Desk by Modern Furniture 'Aftan Executive Desk'
EQ01 - Drinking Fountain by Filtrine 'FOC-107-14-HL-VIP'
EQ02 - Treadmill by Nordic Track 'Sport 60'
EQ03 - Exercise bike by Nordic Track 'S10 Studio Bike'
EQ04 - Leg press by Aussie Fitness 'Gym King HS'
EQ05 - Gym Bench by Aussie Fitness 'Gym King Flat bench'
EQ06 - Squat Rack by Aussie Fitness 'Gym King Commercial Smith Machine'
EQ07 - Power Rack by Aussie Fitness 'Gym King Commercial Power Rack'
EQ08 - Dumbell Rack by Commercial Fitness Equipment 'Titanium USA Monster Series'
EQ09 - Weight Rack by Sumo Strength 'barbarian Rack Package'
EQ10 - Sauna Panel by Jacuzzi Clearlight Saunas 'Custom Kit'
SA01 - Basin by Temple and Webster 'Tulip Wall Hung Basin'
SA02 - Toilet by Temple and Webster 'White Minna Rimless BTW'
SA03 - Shower Head by Temple and Webster '2 Piece Square Shower Head'
SA04 - Drain by Temple and Webster '11x11 Square Shower Grate Floor Drain'
SA05 - Disable toilet sign by Keeler Hardware 'AS1428 Compliant Toilet Sign SILVER Unisex Disabled'
SA10 - Bathroom mirror / dryer / soap by Bradley Australia 'Bradley behind mirror foam soap and hand dryer'
SA11 - Toilet Roll Holder by Estlio 'Chrome Bela Single roll Holder'
SA12 - Shower Mixer by The Blue Space 'Phoenix Vivid Slimline Shower/Wall Mixer'
SA13 - Toilet flush button by Icon Bathware 'Invisi Series II'
FI04 - Sled Track by Raw Fitness Equipment 'Custom Gym Sled'
LI01 - Light up Mirror by ATS Tiles and Bathroom 'Reti Rectangular LED Mirror'
LI02 - LED Logo by Big Banner
MA01 - Polished Concrete
MA02 - GYM MAT
MA03 - Custom Sled turf by Raw Fitness Equipment 'Custom Gym Sled'
MA04 - Brick Lane Tiles by National Tiles
MA05 - Paint finish by Porters Paints 'Mountain Ash'
MA06 - Paint finish by Porters Paints 'Custom Frontline Green'
MA07 - Tiles by National Tiles 'Zellige White Matt Tile'
MA08 - Paint finish by Porters Paints 'Aniseed'
MA09 - Cedar Wood

REVISIONS

No	Date
01	27.10.21
Description	
PRESENTATION DRAWINGS NOT FOR CONSTRUCTION	
Ver. App'd XX App'd	
Do not scale drawings. Use figured dimensions only. Check and verify levels and dimensions on site prior to commencement of any work, the preparation of drawings or the fabrication of components. This drawing is copyright and can not be reproduced without written consent.	

Client

Moey Faour



LEADING FROM THE FRONT

True North



Billy Blue College of Design
46-52 Mountain Street, Ultimo, NSW 2007,
Australia
+61 (0)2 9999 9999



LAUREATE INTERNATIONAL UNIVERSITIES

Project

Frontline Fitness

630 Canterbury Road,
Belmore, NSW. 2192

Project number

01

Drawing Title

Electrical plan

Drawing Status


PRESENTATION
DRAWINGS
NOT FOR
CONSTRUCTION

Scale Drawing No Issue
1 : 50 D05 01

Date 27.10.21

Drawn by MB

RCP Legend	
	Lighting Fixture Wire
	Lighting Fixture Grid
	Lighting Power Switch
	Lighting Two Way Switch
	Smoke Alarm
	Exit Signs
	Lighting fixtures

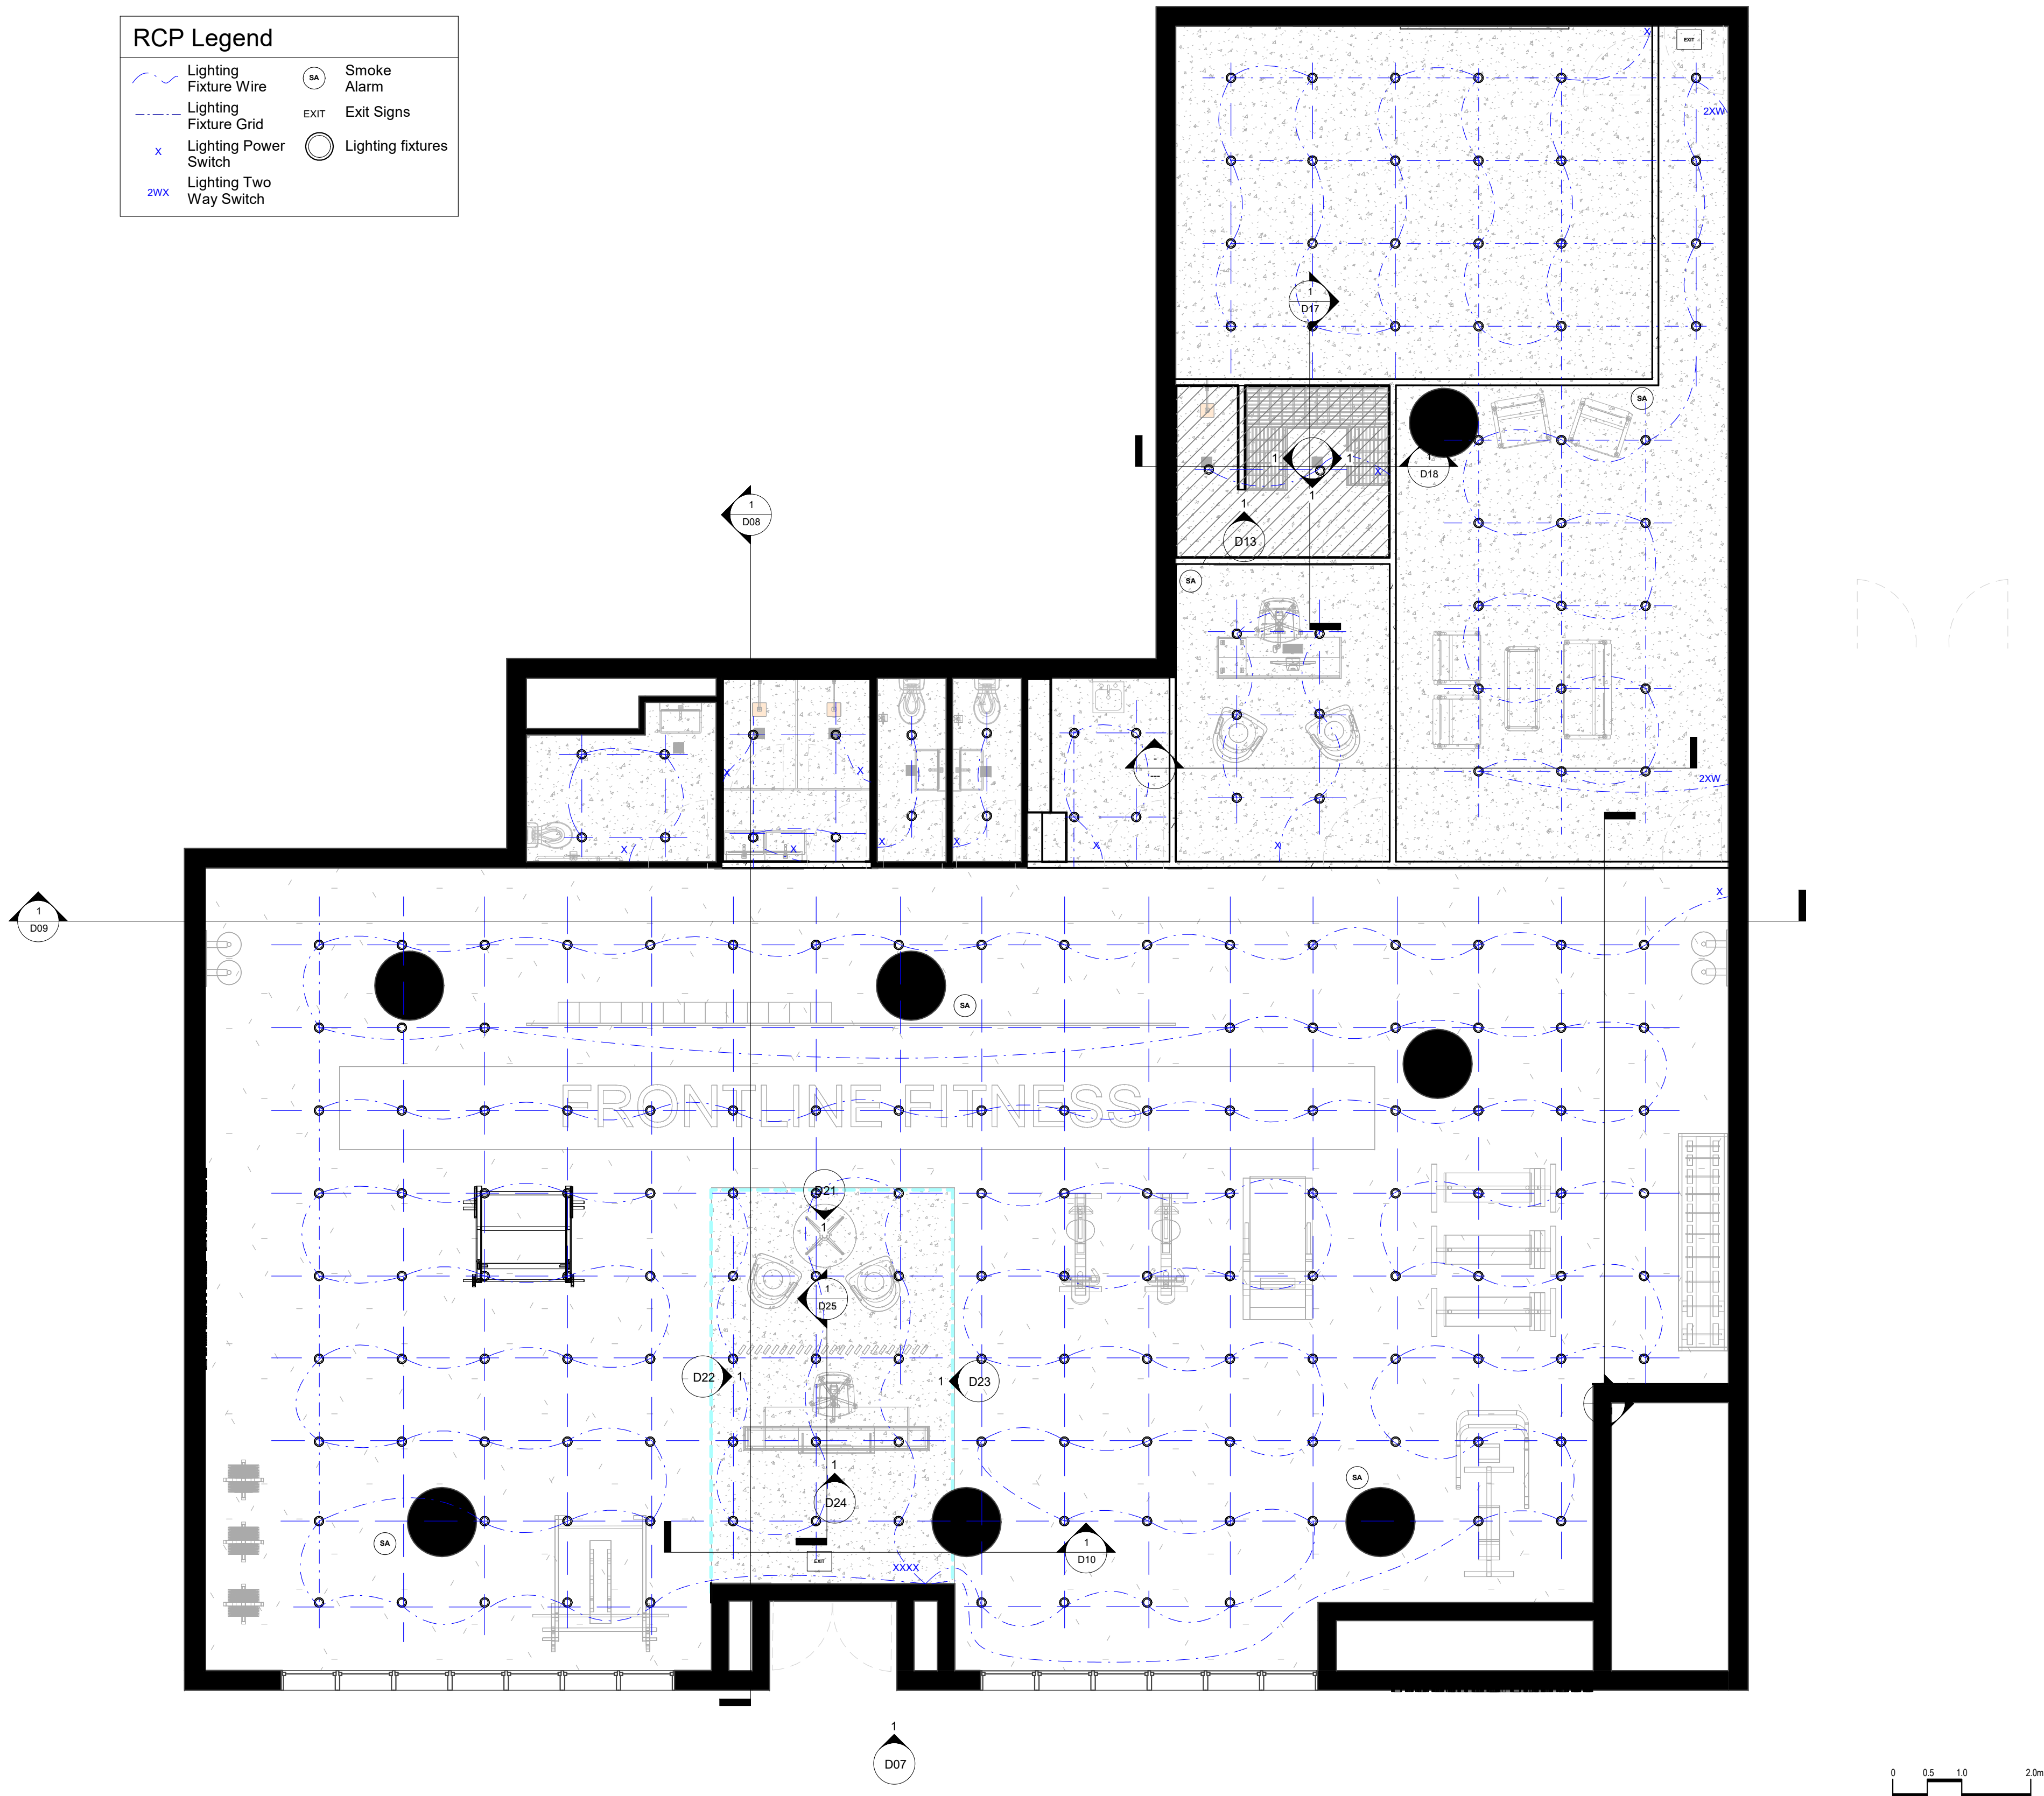

LEGEND

Cut Material

	Glass		Tiles
	Cedar		Plaster Board
	Concrete		Existing Structure
	Gym Mat		

Wall Types

	Timber stud wall 90mm x 45mm w/ 9mm Plaster board and 'Mountain Ash - Low sheen' Paint finish
	'Custom Frontline Green - Low sheen' Paint finish (1200mm H)
	Timber stud wall 90mm x 45mm w/ 12mm timber cedar top
	24mm Melamine (2400mm H)
	Timber stud wall 90mm x 45mm w/ 2mm glue + 6mm Bricklaine tile
	Timber stud wall 90mm x 45mm w/ 2mm glue + 6mm square tile

Door Types

	915mm x 2134mm Flush w/ Blk Frame
	813mm x 2134mm Flush w/ Blk Frame
	762mm x 2000mm Toilet Cubicle Door
	915mm x 2134mm Glass w/ Blk Frame
	762mm x 2134mm Glass w/ Blk Frame

Window Types

	815mm x 2850mm Frosted Glass w/ Blk Frame
	815mm x 2210mm Glass w/ Blk Frame

Abbreviations

BLK	Black	SA	Sanitary
D0	Door	SS	Stainless Steel
EQ	Equipment	W0	Window
FI	Fixture	WT	Wall Type
FU	Furniture	W	With

Tag Legend

FU01 -	2x Medium Locker by Elite Office Furniture
FU02 -	Chair by Colesse 'Joel'
FU03 -	Chair by Colesse 'Sidewalk'
FU04 -	2 Seater Lounge by Colesse 'Sidewalk'
FU05 -	Coffee table by Metro 'Toppo'
FU06 -	Coffee table by Temple and Webster
FU07 -	Office Chair by Colesse 'Sindu'
FU08 -	Reception Desk by Elite Office Furniture 'Casnan Premier Sorrento Reception Counter'
FU09 -	Office Desk by Modern Furniture 'Aftan Executive Desk'
EQ01 -	Drinking Fountain by Filtrine 'FCC-107-14-HL-VF'
EQ02 -	Treadmill by Nordic Track 'Sport 50'
EQ03 -	Exercise bike by Nordic Track 'S10 Studio Bike'
EQ04 -	Leg press by Aussie Fitness 'Gym King HS'
EQ05 -	Gym Bench by Aussie Fitness 'Gym King Flat bench'
EQ06 -	Squat Rack by Aussie Fitness 'Gym King Commercial Smith Machine'
EQ07 -	Power Rack by Aussie Fitness 'Gym King Commercial Power Rack'
EQ08 -	Dumbbell Rack by Commercial Fitness Equipment 'Titanium USA Monster Series'
EQ09 -	Weight Rack by Sumo Strengh 'barbarian Rack Package'
EQ10 -	Sauna Panel by Jacuzzi Clearlight Saunas 'Custom Kit'
SA01 -	Basin by Temple and Webster 'Tulip Wall Hung Basin'
SA02 -	Toilet by Temple and Webster 'White Minna Rimless BTW'
SA03 -	Shower Head by Temple and Webster '2 Piece Square Shower Head'
SA04 -	Drain by Temple and Webster '11x11 Square Shower Grate Floor Drain'
SA05 -	Disable toilet sign by Keeler Hardware 'AS1428 Compliant Toilet Sign SILVER Unisex Disabled'
SA10 -	Bathroom mirror / dryer / soap by Bradley Australia 'Trolley behind mirror foam soap and hand dryer'
SA11 -	Toilet Roll Holder by Estlio 'Chrome Bela Single roll Holder'
SA12 -	Shower Mixer by The Blue Space 'Phoenix Vivid Slimline Shower/Wall Mixer'
SA13 -	Toilet flush button by Icon Bathware 'Invisi Series II'
F104 -	Sled Track by Raw Fitness Equipment 'Custom Gym Sled'
LI01 -	Light up Mirror by ATS Tiles and Bathroom 'Reti Rectangular LED Mirror'
LI02 -	LED Logo by Big Banner
MA01 -	Polished Concrete
MA02 -	Gym Mat
MA03 -	Custom Sled turf by Raw Fitness Equipment 'Custom Gym Sled'
MA04 -	Brick Lane Tiles by National Tiles
MA05 -	Paint finish by Porters Paints 'Mountain Ash'
MA06 -	Paint finish by Porters Paints 'Custom Frontline Green'
MA07 -	Tiles by National Tiles 'Zellige White Matt Tile'
MA08 -	Paint finish by Porters Paints 'Aniseed'
MA09 -	Cedar Wood

REVISIONS

No Date
01 27.10.21

Description
PRESENTATION DRAWINGS
NOT FOR CONSTRUCTION

Ver. App'd
XX App'd

Do not scale drawings. Use figured dimensions only. Check and verify levels and dimensions on site prior to commencement of any work, the preparation of drawings or the fabrication of components.
This drawing is copyright and can not be reproduced without written consent.

Client
Moey Faour



Frontline Fitness
"LEADING FROM THE FRONT"

True North



Billy Blue College of Design
46-52 Mountain Street, Ultimo, NSW 2007, Australia
+61 (0)2 9999 9999



LAUREATE INTERNATIONAL UNIVERSITIES

Project

Frontline Fitness

630 Canterbury Road,
Belmore, NSW. 2192

Project number
01

Drawing Title

RCP

Drawing Status


PRESENTATION
DRAWINGS
NOT FOR
CONSTRUCTION

Scale 1 : 50 Drawing No D06 Issue 01

Date 27.10.21

Drawn by MB

6/12/2021 3:52:21 AM

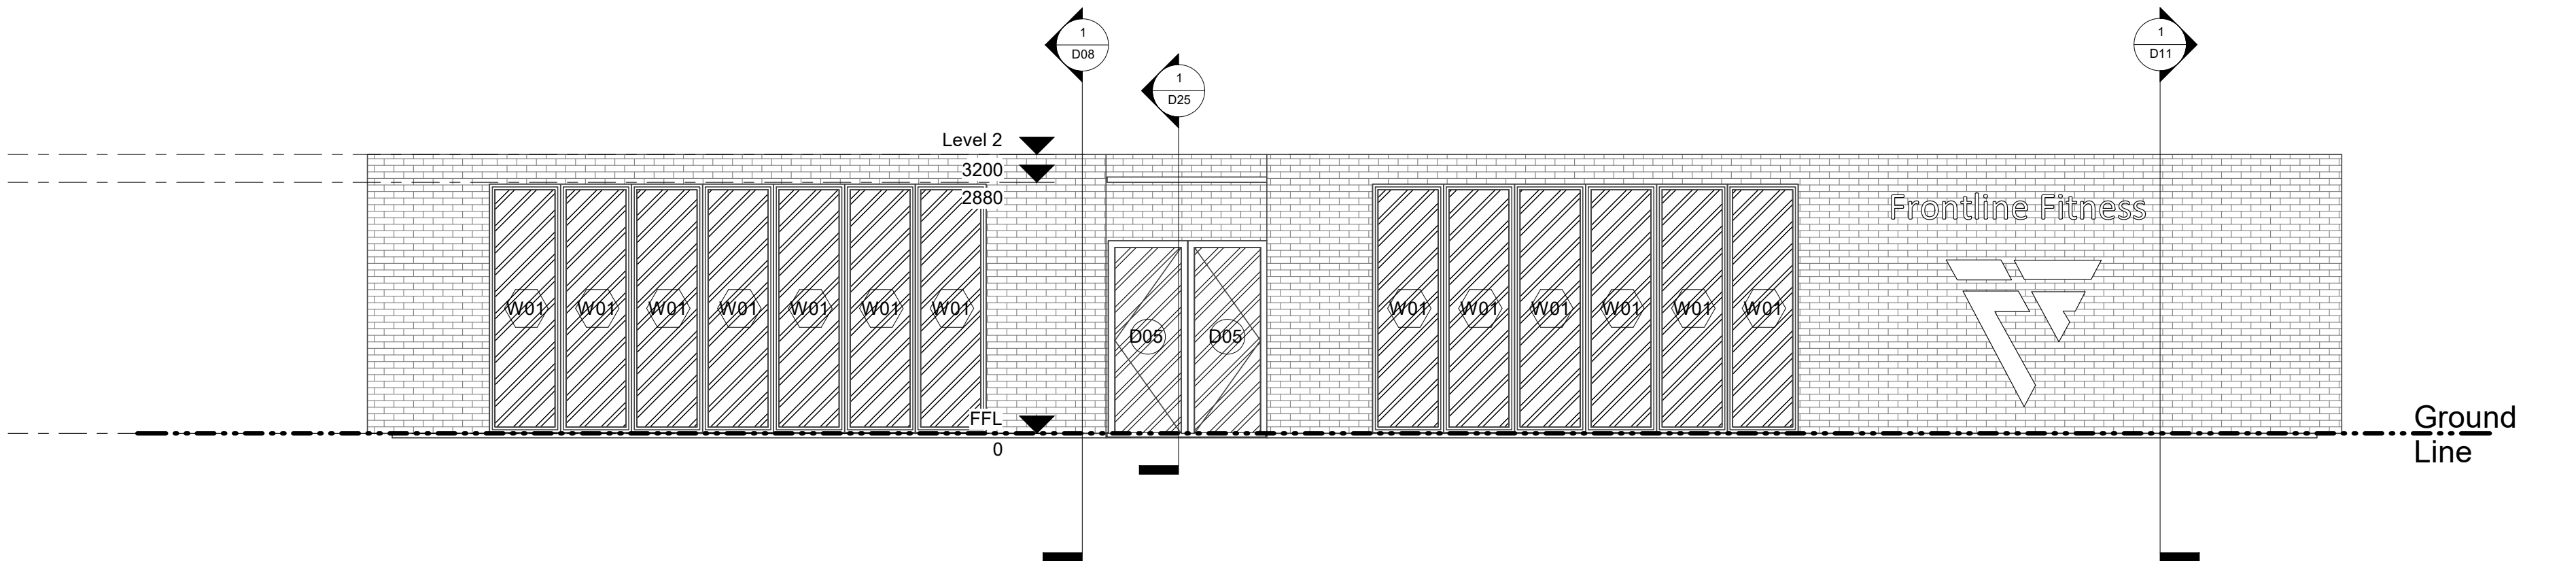

LEGEND

Cut Material

	Glass		Tiles
	Cedar		Plaster Board
	Concrete		Existing Structure
	Gym Mat		

Wall Types

	Timber stud wall 90mm x 45mm w/ 9mm Plaster board and 'Mountain Ash - Low sheen' Paint finish
	'Custom Frontline Green - Low sheen' Paint finish (1200mm H)
	Timber stud wall 90mm x 45mm w/ 12mm timber cedar top
	24mm Melamine (2400mm H)
	Timber stud wall 90mm x 45mm w/ 2mm glue + 6mm Bricklane tile
	Timber stud wall 90mm x 45mm w/ 2mm glue + 6mm square tile

Door Types

	915mm x 2134mm Flush w/ Blk Frame
	813mm x 2134mm Flush w/ Blk Frame
	762mm x 2000mm Toilet Cubicle Door
	915mm x 2134mm Glass w/ Blk Frame
	762mm x 2134mm Glass w/ Blk Frame

Window Types

	815mm x 2850mm Frosted Glass w/ Blk Frame
	815mm x 2210mm Glass w/ Blk Frame

Abbreviations

BLK	Black	SA	Sanitary
DO	Door	SS	Stainless Steel
EQ	Equipment	W0	Window
FI	Fixture	WT	Wall Type
FU	Furniture	WJ	Win

Tag Legend

FU01 - 2x Medium Locker by Elite Office Furniture
FU02 - Chair by Coalesse 'Joel'
FU03 - Chair by Coalesse 'Sidewalk'
FU04 - 2 Seater Lounge by by Coalesse 'Sidewalk'
FU05 - Coffee table by Metro 'Topi'
FU06 - Coffee table by Temple and Webster
FU07 - Office Chair by Coalesse 'Bridu'
FU08 - Reception Desk by Elite Office Furniture 'Casnan Premier Sorrento Reception Counter'
FU09 - Office Desk by Modern Furniture 'Aftan Executive Desk'
EQ01 - Drinking Fountain by Filtime 'FC2-107-14-HL-VF'
EQ02 - Treadmill by Nordic Track 'Sport 50'
EQ03 - Exercise bike by Nordic Track 'S10 Studio Bike'
EQ04 - Leg press by Aussie Fitness 'Gym King HS'
EQ05 - Gym Bench by Aussie Fitness 'Gym King Flat bench'
EQ06 - Squat Rack by Aussie Fitness 'Gym King Commercial Smith Machine'
EQ07 - Power Rack by Aussie Fitness 'Gym King Commercial Power Rack'
EQ08 - Dumbbell Rack by Commercial Fitness Equipment 'Titanium USA Monster Series'
EQ09 - Weight Rack by Sumo Strengh't 'barbarian Rack Package'
EQ10 - Sauna Panel by Jacuzzi Clearlight Saunas 'Custom Kit'
SA01 - Basin by Temple and Webster 'Tulip Wall Hung Basin'
SA02 - Toilet by Temple and Webster 'White Minna Rimless BTW'
SA03 - Shower Head by Temple and Webster '2 Piece Square Shower Head'
SA04 - Drain by Temple and Webster '11x11 Square Shower Grate Floor Drain'
SA08 - Disable toilet sign by Keeler Hardware 'AS1428 Compliant Toilet Sign SILVER Unisex Disabled'
SA10 - Bathroom mirror / dryer / soap by Bradley Australia 'Bradley behind mirror foam soap and hand dryer'
SA11 - Toilet Roll Holder by Estilo 'Chrome Beta Single roll Holder'
SA12 - Shower Mixer by The Blue Space 'Phoenix Vivid Slimline Shower/Wall Mixer'
SA13 - Toilet flush button by Icon Bathware 'Invisi Series II'
FI04 - Sled Track by Raw Fitness Equipment 'Custom Gym Sled'
LI01 - Light up Mirror by ATS Tiles and Bathroom 'Retti Rectangular LED Mirror'
LI02 - LED Logo by Big Banner
MA01 - Polished Concrete
MA02 - GYM MAT
MA03 - Custom Sled surf by Raw Fitness Equipment 'Custom Gym Sled'
MA04 - Brick Lane Tiles by National Tiles
MA05 - Paint finish by Porters Paints 'Mountain Ash'
MA06 - Paint finish by Porters Paints 'Custom Frontline Green'
MA07 - Tiles by National Tiles 'Zellige White Matt Tile'
MA08 - Paint finish by Porters Paints 'Anisseed'
MA09 - Cedar Wood

REVISIONS

No Date
01 27.10.21

Description
PRESENTATION DRAWINGS
NOT FOR CONSTRUCTION

Ver. App'd
XX App'd

Do not scale drawings. Use figured dimensions only. Check and verify levels and dimensions on site prior to commencement of any work, the preparation of drawings or the fabrication of components.
This drawing is copyright and can not be reproduced without written consent.

Client

Moey Faour



True North

Billy Blue College of Design
46-52 Mountain Street, Ultimo, NSW 2007, Australia
+61 (0)2 9999 9999



LAUREATE INTERNATIONAL UNIVERSITIES

Project

Frontline Fitness

630 Canterbury Road,
Belmore, NSW. 2192

Project number
01

Drawing Title

External Elevations

Drawing Status


PRESENTATION
DRAWINGS
NOT FOR
CONSTRUCTION

Scale Drawing No Issue
1 : 50 D07 01

Date 27.10.21

Drawn by MB

6/12/2021 3:52:27 AM

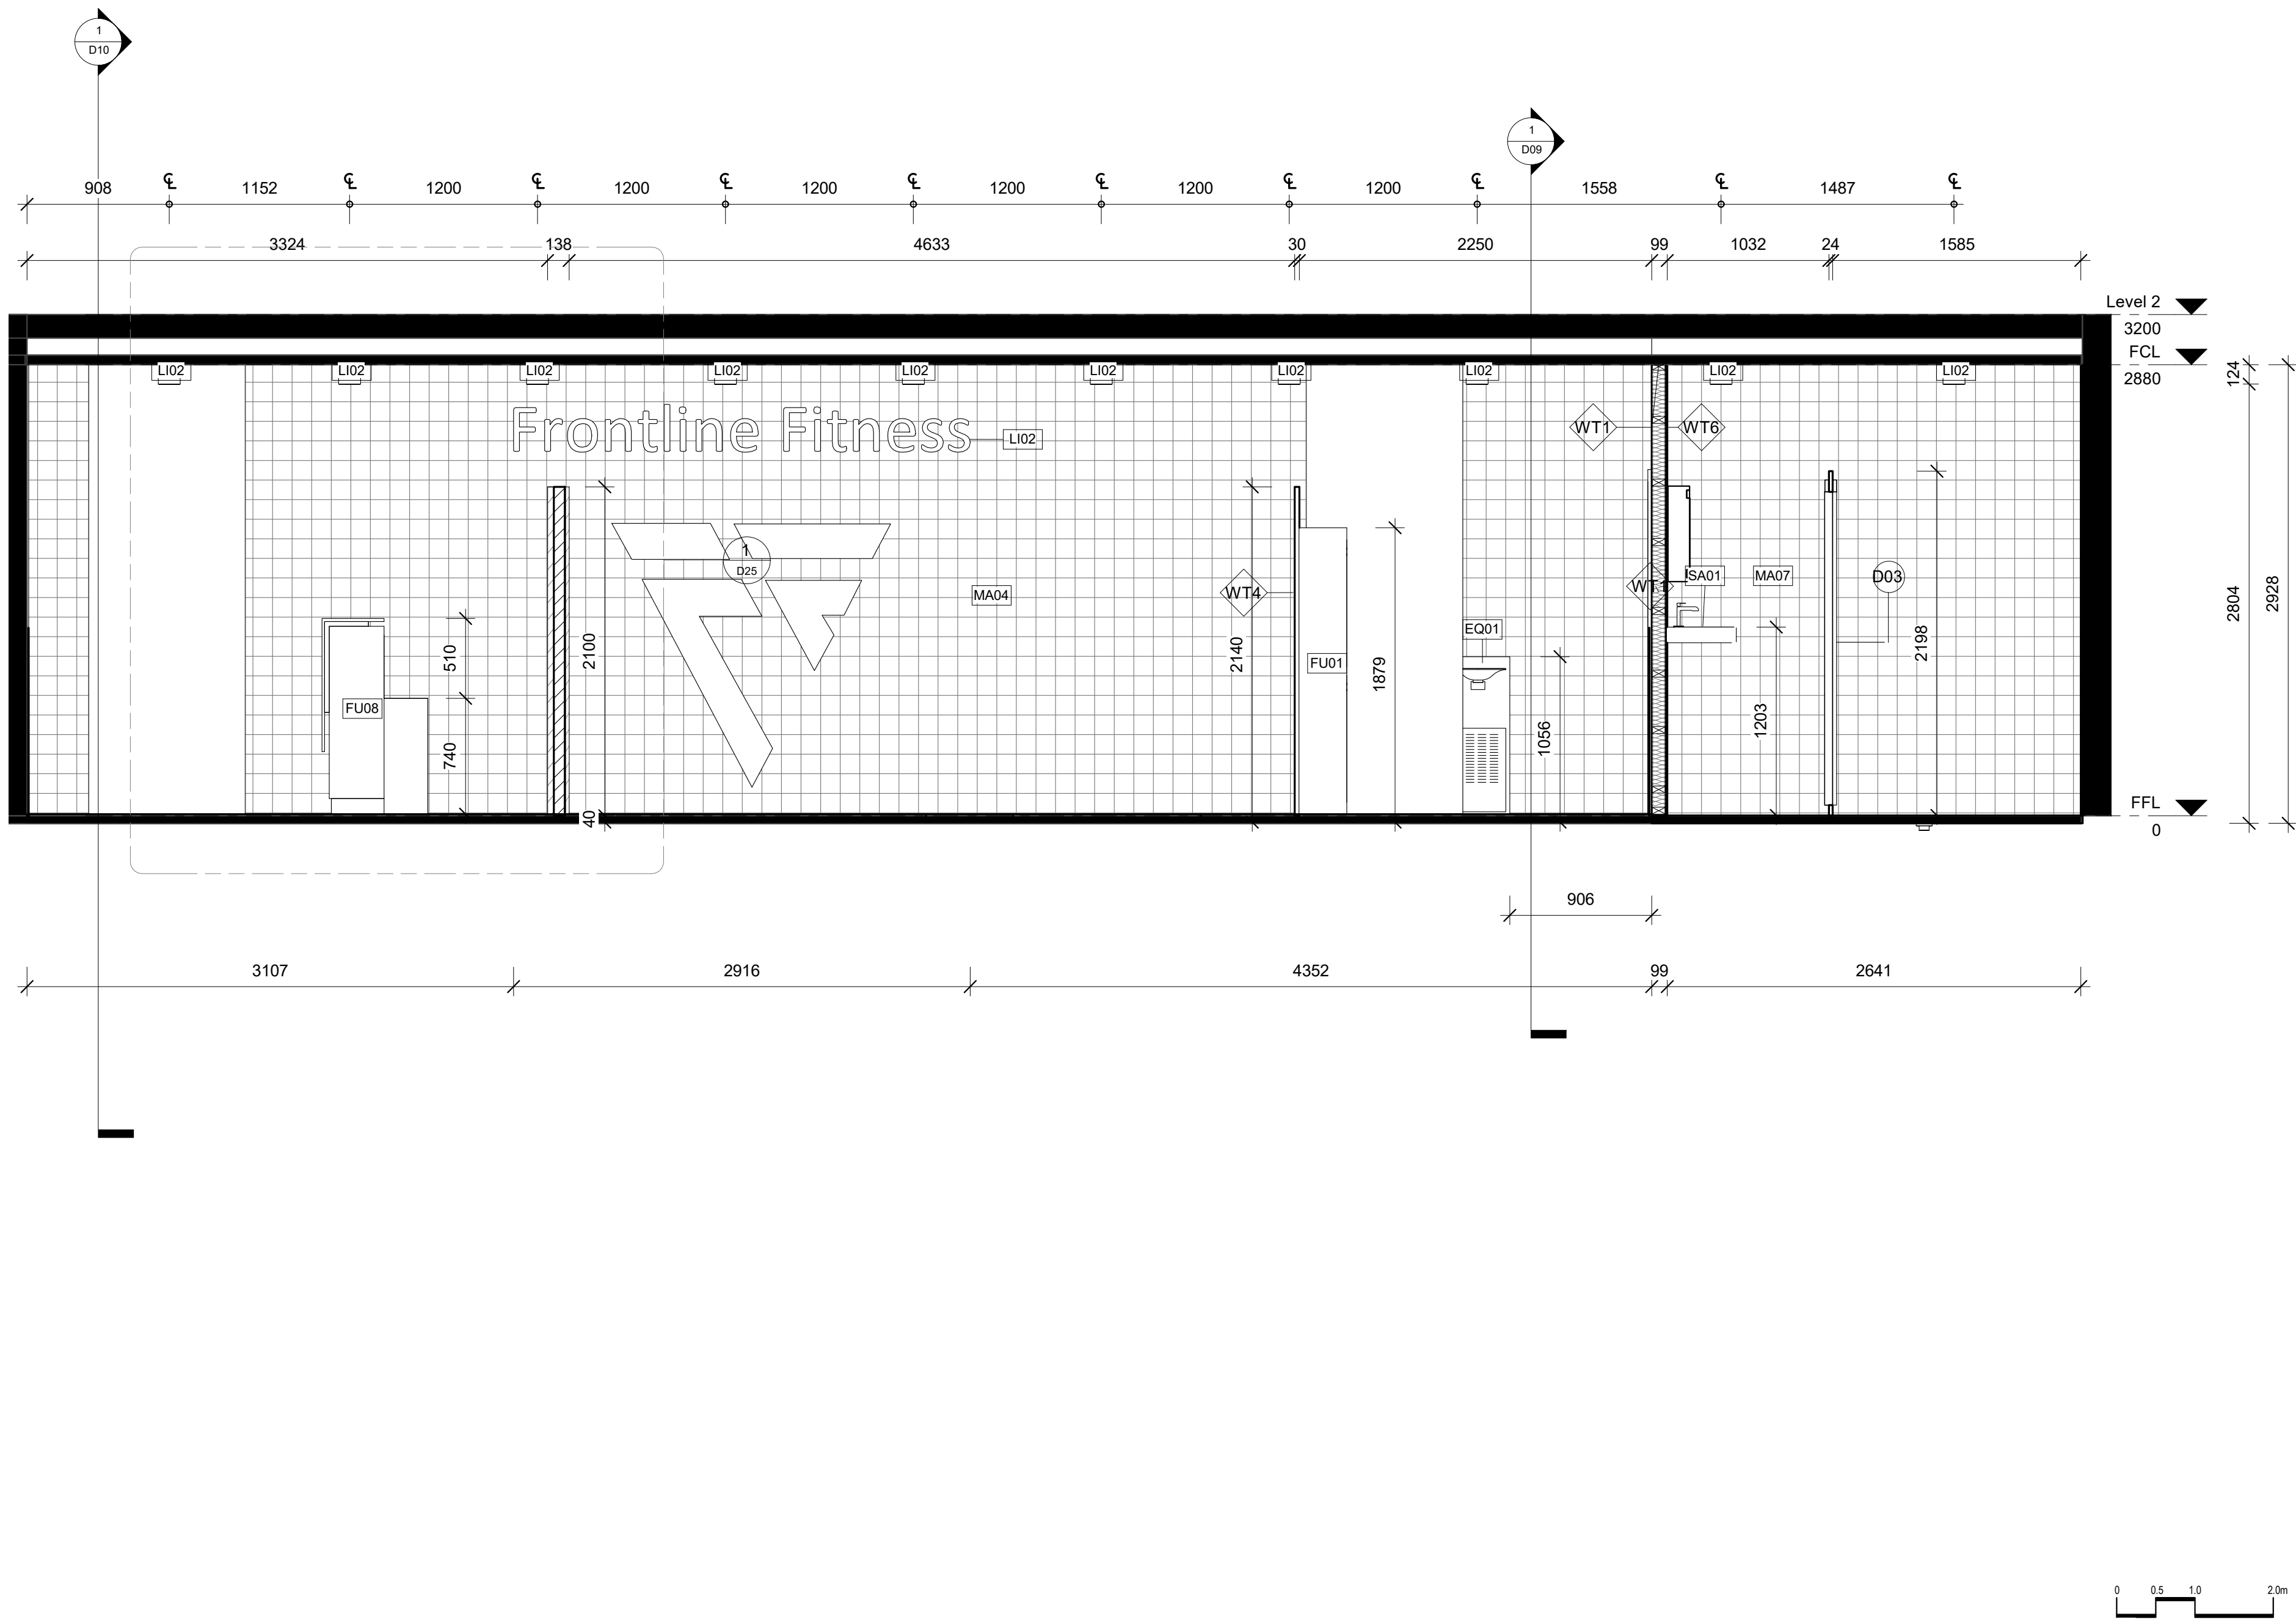

LEGEND

Cut Material

	Glass		Tiles
	Cedar		Plaster Board
	Concrete		Existing Structure
	Gym Mat		

Wall Types

	Timber stud wall 90mm x 45mm w/ 9mm Plaster board and Mountain Ash - Low sheen Paint finish
	'Custom Frontline Green - Low sheen' Paint finish (1200mm H)
	Timber stud wall 90mm x 45mm w/ 12mm timber cedar top
	24mm Melamine (2400mm H)
	Timber stud wall 90mm x 45mm w/ 2mm glue + 6mm Bricklane tile
	Timber stud wall 90mm x 45mm w/ 2mm glue + 6mm square tile

Door Types

	915mm x 2134mm Flush w/ Blk Frame
	813mm x 2134mm Flush w/ Blk Frame
	762mm x 2000mm Toilet Cubicle Door
	915mm x 2134mm Glass w/ Blk Frame
	762mm x 2134mm Glass w/ Blk Frame

Window Types

	815mm x 2850mm Frosted Glass w/ Blk Frame
	815mm x 2210mm Glass w/ Blk Frame

Abbreviations

BLK	Black	SA	Sanitary
D0	Door	SS	Stainless Steel
EQ	Equipment	W0	Window
F1	Fixture	WT	Wall Type
FU	Furniture	W/	With

Tag Legend

FU01 - 2x Medium Locker by Elite Office Furniture
FU02 - Chair by Colesseas 'Joel'
FU03 - Chair by Colesseas 'Sidewalk'
FU04 - 2 Seater Lounge by by Colesseas 'Sidewalk'
FU05 - Coffee table by Metro 'Topo'
FU06 - Coffee table by Temple and Webster
FU07 - Office Chair by Colesseas 'Bindu'
FU08 - Reception Desk by Elite Office Furniture 'Casnan Premier Sorrento Reception Counter'
FU09 - Office Desk by Modern Furniture 'Atlan Executive Desk'
EQ01 - Drinking Fountain by Filtrine 'FCC-107-14-HL-VP'
EQ02 - Treadmill by Nordic Track 'Sport 50'
EQ03 - Exercise bike by Nordic Track 'S10 Studio Bike'
EQ04 - Leg press by Aussie Fitness 'Gym King HS'
EQ05 - Gym Bench by Aussie Fitness 'Gym King Flat bench'
EQ06 - Squat Rack by Aussie Fitness 'Gym King Commercial Smith Machine'
EQ07 - Power Rack by Aussie Fitness 'Gym King Commercial Power Rack'
EQ08 - Dumbbell Rack by Commercial Fitness Equipment 'Titanium USA Monster Series'
EQ09 - Weight Rack by Sumo Strengh 'barbarian Rack Package'
EQ10 - Sauna Panel by Jacuzzi Clearlight Saunas 'Custom Kit'
SA01 - Basin by Temple and Webster 'Tulip Wall Hung Basin'
SA02 - Toilet by Temple and Webster 'White Minna Rimless BTW'
SA03 - Shower Head by Temple and Webster '2 Piece Square Shower Head'
SA04 - Drain by Temple and Webster '11x11 Square Shower Grate Floor Drain'
SA08 - Disable toilet sign by Keeler Hardware 'AS1428 Compliant Toilet Sign SILVER Unless Disabled'
SA10 - Bathroom mirror / dryer / soap by Bradley Australia 'Bradley behind mirror foam soap and hand dryer'
SA11 - Toilet Roll Holder by Esatto 'Chrome Beia Single roll Holder'
SA12 - Shower Mixer by The Blue Space 'Phoenix Vivid Slimline Shower/Wall Mixer'
SA13 - Toilet flush button by Icon Bathware 'Invisal Series II'
F104 - Sled Track by Raw Fitness Equipment 'Custom Gym Sled'
L01 - Light up Mirror by ATS Tiles and Bathroom 'Retti Rectangular LED Mirror'
L02 - LED Logo by Big Banner
MA01 - Polished Concrete
MA02 - GYM MAT
MA03 - Custom Sled turf by Raw Fitness Equipment 'Custom Gym Sled'
MA04 - Brick Lane Tiles by National Tiles
MA05 - Paint finish by Porters Paints 'Mountain Ash'
MA06 - Paint finish by Porters Paints 'Custom Frontline Green'
MA07 - Tiles by National Tiles 'Zellige White Matt Tile'
MA08 - Paint finish by Porters Paints 'Anisced'
MA09 - Cedar Wood

REVISIONS

No Date
01 27.10.21

Description
PRESENTATION DRAWINGS
NOT FOR CONSTRUCTION

Ver. App'd
XX App'd

Do not scale drawings. Use figured dimensions only. Check and verify levels and dimensions on site prior to commencement of any work, the preparation of drawings or the fabrication of components.
This drawing is copyright and can not be reproduced without written consent.

Client
Moey Faour



True North

Billy Blue College of Design
46-52 Mountain Street, Ultimo, NSW 2007, Australia
+61 (0)2 9999 9999



Project

Frontline Fitness

630 Canterbury Road,
Belmore, NSW. 2192

Project number
01

Drawing Title

Section 1

Drawing Status


PRESENTATION
DRAWINGS
NOT FOR
CONSTRUCTION

Scale Drawing No Issue
1 : 50 D08 01

Date 27.10.21


Drawn by MB

6/12/2021 3:52:38 AM

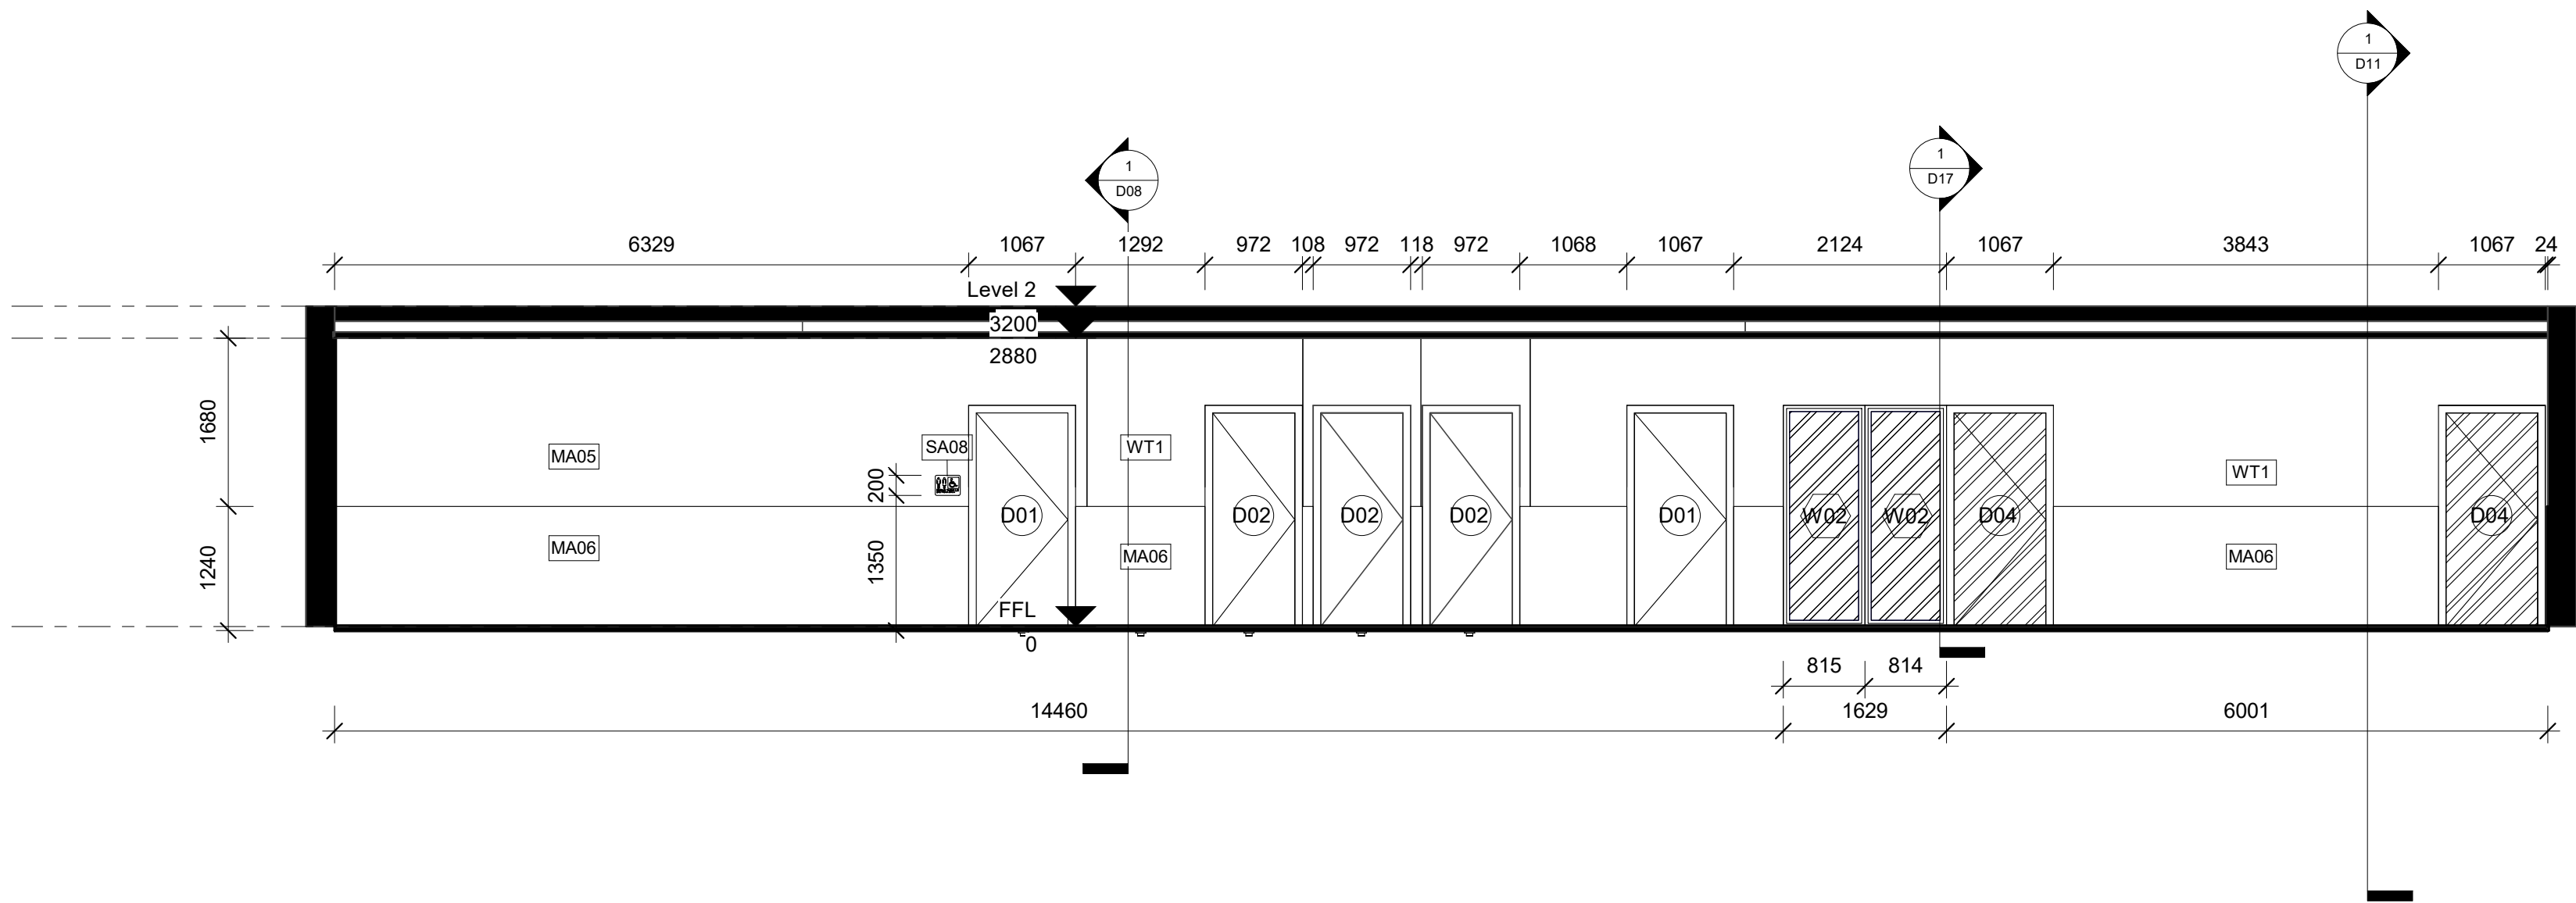

LEGEND

Cut Material

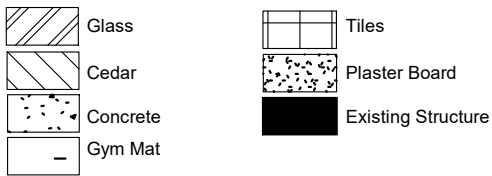

Wall Types

- WT1** Timber stud wall 90mm x 45mm w/ 9mm Plaster board and 'Mountain Ash - Low sheen' Paint finish
- WT2** 'Custom Frontline Green - Low sheen' Paint finish (1200mm H)
- WT3** Timber stud wall 90mm x 45mm w/ 12mm timber cedar top
- WT4** 24mm Melamine (2400mm H)
- WT5** Timber stud wall 90mm x 45mm w/ 2mm glue + 6mm Bricklane tile
- WT6** Timber stud wall 90mm x 45mm w/ 2mm glue + 6mm square tile

Door Types

- D01** 915mm x 2134mm Flush w/ Blk Frame
- D02** 813mm x 2134mm Flush w/ Blk Frame
- D03** 762mm x 2000mm Toilet Cubicle Door
- D04** 915mm x 2134mm Glass w/ Blk Frame
- D05** 762mm x 2134mm Glass w/ Blk Frame

Window Types

- W01** 815mm x 2850mm Frosted Glass w/ Blk Frame
- W02** 815mm x 2210mm Glass w/ Blk Frame

Abbreviations

- BLK Black
D0 Door
EQ Equipment
FI Fixture
FU Furniture
- SA Sanitary
SS Stainless Steel
W0 Window
WT Wall Type
W/ With

Tag Legend

- FU01 - 2x Medium Locker by Elite Office Furniture
FU02 - Chair by Coalesse 'Joel'
FU03 - Chair by Coalesse 'Sidewalk'
FU04 - 2 Seater Lounge by by Coalesse 'Sidewalk'
FU05 - Coffee table by Metro 'Togo'
FU06 - Coffee table by Temple and Webster
FU07 - Office Chair by Coalesse 'Binky'
FU08 - Reception Desk by Elite Office Furniture 'Casnan Premier Sorrento Reception Counter'
FU09 - Office Desk by Modern Furniture 'Aftan Executive Desk'
EQ01 - Drinking Fountain by Filtrine 'FCC-107-14HL-VP'
EQ02 - Treadmill by Nordic Track 'Sport 50'
EQ03 - Exercise bike by Nordic Track 'S10 Studio Bike'
EQ04 - Leg press by Aussie Fitness 'Gym King HS'
EQ05 - Gym Bench by Aussie Fitness 'Gym King Flat bench'
EQ06 - Squat Rack by Aussie Fitness 'Gym King Commercial Smith Machine'
EQ07 - Power Rack by Aussie Fitness 'Gym King Commercial Power Rack'
EQ08 - Dumbbell Rack by Commercial Fitness Equipment 'Titanium USA Monster Series'
EQ09 - Weight Rack by Sumo Strength 'barbarian Rack Package'
EQ10 - Sauna Panel by Jacuzzi Clearlight Saunas 'Custom Kit'
SA01 - Basin by Temple and Webster 'Tulip Wall Hung Basin'
SA02 - Toilet by Temple and Webster 'White Minna Rimless BTW'
SA03 - Shower Head by Temple and Webster '2 Piece Square Shower Head'
SA04 - Drain by Temple and Webster '11x11 Square Shower Grate Floor Drain'
SA08 - Disable toilet sign by Keeler Hardware 'AS1428 Compliant Toilet Sign SILVER Unisex Disabled'
SA10 - Bathroom mirror / dryer / soap by Bradley Australia 'treadley behind mirror foam soap and hand dryer'
SA11 - Toilet Roll Holder by Gallo 'Chrome Bella Single roll Holder'
SA12 - Shower Mixer by The Blue Space 'Phoenix Vivid Slimline Shower/Wall Mixer'
SA13 - Toilet flush button by Icon Bathware 'Invisi Series II'
F104 - Sled Track by Raw Fitness Equipment 'Custom Gym Sled'
LI01 - Light up Mirror by ATS Tiles and Bathroom 'Retti Rectangular LED Mirror'
LI02 - LED Logo by Big Banner
MA01 - Polished Concrete
MA02 - GYM MAT
MA03 - Custom Sled turf by Raw Fitness Equipment 'Custom Gym Sled'
MA04 - Brick Lane Tiles by National Tiles
MA05 - Paint finish by Porters Paints 'Mountain Ash'
MA06 - Paint finish by Porters Paints 'Custom Frontline Green'
MA07 - Tiles by National Tiles 'Zellige White Matt Tile'
MA08 - Paint finish by Porters Paints 'Anisced'
MA09 - Cedar Wood

REVISIONS

No Date
01 27.10.21

Description
PRESENTATION DRAWINGS
NOT FOR CONSTRUCTION

Ver. App'd
XX App'd

Do not scale drawings. Use figured dimensions only. Check and verify levels and dimensions on site prior to commencement of any work, the preparation of drawings or the fabrication of components.
This drawing is copyright and can not be reproduced without written consent.

Client
Moey Faour



True North

Billy Blue College of Design
46-52 Mountain Street, Ultimo, NSW 2007, Australia
+61 (0)2 9999 9999



LAUREATE INTERNATIONAL UNIVERSITIES

Project

Frontline Fitness

630 Canterbury Road,
Belmore, NSW. 2192

Project number
01

Drawing Title

Section 2

Drawing Status


PRESENTATION
DRAWINGS
NOT FOR
CONSTRUCTION

Scale Drawing No Issue
1 : 50 D09 01

Date 27.10.21


Drawn by MB

6/12/2021 3:52:43 AM

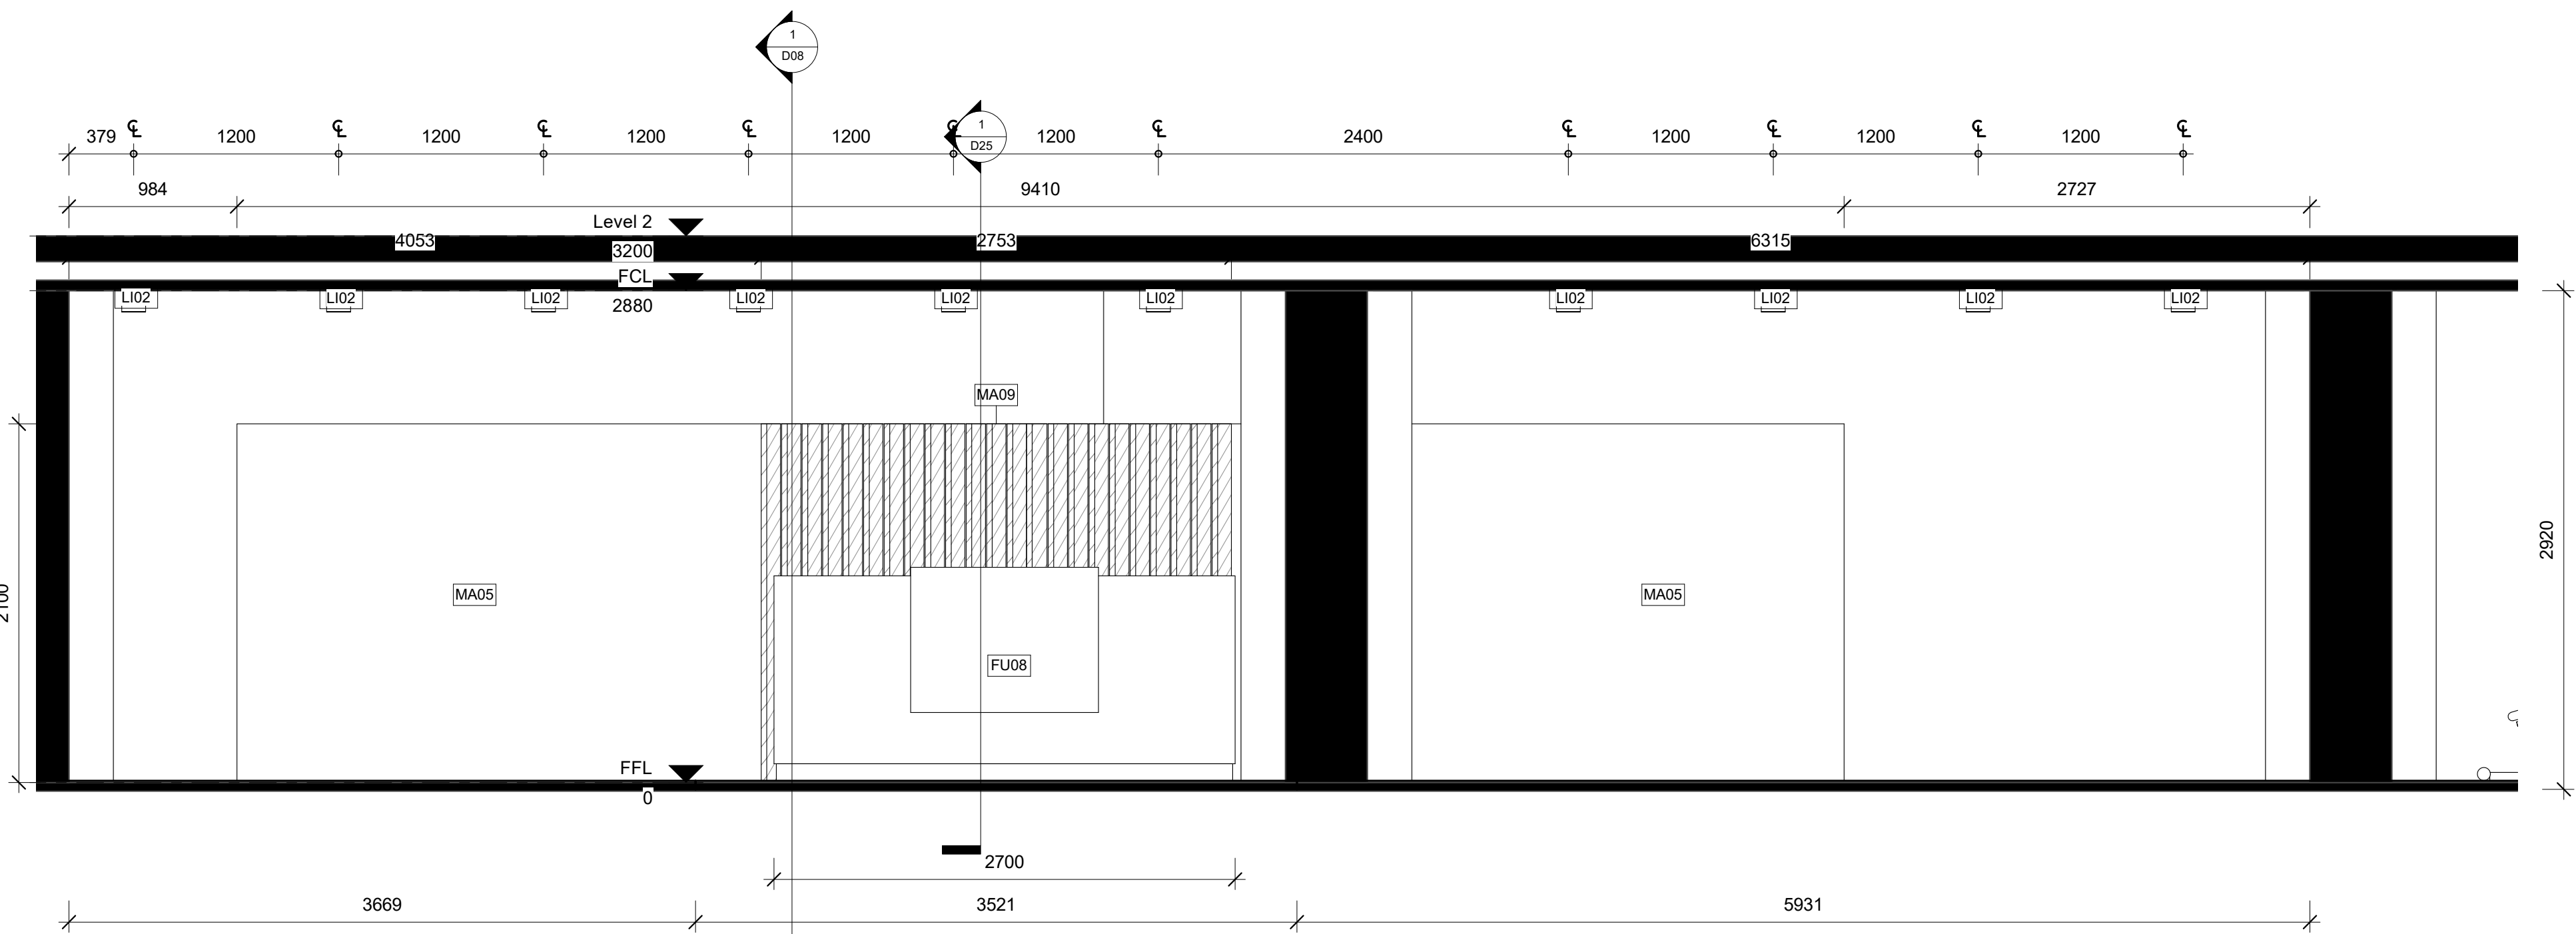

LEGEND

Cut Material

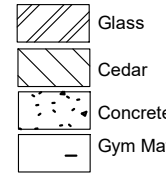

Wall Types

- WT1 - Timber stud wall 90mm x 45mm w/ 9mm Plaster board and 'Mountain Ash - Low sheen' Paint finish
- WT2 - 'Custom Frontline Green - Low sheen' Paint finish (1200mm H)
- WT3 - Timber stud wall 90mm x 45mm w/ 12mm timber cedar top
- WT4 - 24mm Melamine (2400mm H)
- WT5 - Timber stud wall 90mm x 45mm w/ 2mm glue + 6mm Bricklane tile
- WT6 - Timber stud wall 90mm x 45mm w/ 2mm glue + 6mm square tile

Door Types

- DO1 - 915mm x 2134mm Flush w/ Blk Frame
- DO2 - 813mm x 2134mm Flush w/ Blk Frame
- DO3 - 762mm x 2000mm Toilet Cubicle Door
- DO4 - 915mm x 2134mm Glass w/ Blk Frame
- DO5 - 762mm x 2134mm Glass w/ Blk Frame

Window Types

- W01 - 815mm x 2850mm Frosted Glass w/ Blk Frame
- W02 - 815mm x 2210mm Glass w/ Blk Frame

Abbreviations

- BLK - Black
- D0 - Door
- EQ - Equipment
- FI - Fixture
- FU - Furniture
- SA - Sanitary
- SS - Stainless Steel
- W0 - Window
- WT - Wall Type
- Wl - With

Tag Legend

- FU01 - 2x Medium Locker by Elite Office Furniture
- FU02 - Chair by Coalesse 'Joel'
- FU03 - Chair by Coalesse 'Sidewalk'
- FU04 - 2 Seater Lounge by Coalesse 'Sidewalk'
- FU05 - Coffee table by Metro 'Topo'
- FU06 - Coffee table by Temple and Webster
- FU07 - Office Chair by Coalesse 'Bindu'
- FU08 - Reception Desk by Elite Office Furniture 'Casnan Premier Sorrento Reception Counter'
- FU09 - Office Desk by Modern Furniture 'Aftan Executive Desk'
- EQ01 - Drinking Fountain by Filtrine 'FCO-107-14-HL-VP'
- EQ02 - Treadmill by Nordic Track 'Sport 50'
- EQ03 - Exercise bike by Nordic Track 'S10 Studio Bike'
- EQ04 - Leg press by Aussie Fitness 'Gym King H2'
- EQ05 - Gym Bench by Aussie Fitness 'Gym King Flat bench'
- EQ06 - Squat Rack by Aussie Fitness 'Gym King Commercial Smith Machine'
- EQ07 - Power Rack by Aussie Fitness 'Gym King Commercial Power Rack'
- EQ08 - Dumbbell Rack by Commercial Fitness Equipment 'Titanium USA Monster Series'
- EQ09 - Weight Rack by Sumo Strenight 'barbarian Rack Package'
- EQ10 - Sauna Panel by Jacuzzi Clearlight Saunas 'Custom Kit'
- SA01 - Basin by Temple and Webster 'Tulip Wall Hung Basin'
- SA02 - Toilet by Temple and Webster 'White Minna Rimless BTW'
- SA03 - Shower Head by Temple and Webster '2 Piece Square Shower Head'
- SA04 - Drain by Temple and Webster '11x11 Square Shower Grate Floor Drain'
- SA05 - Disable toilet sign by Keeler Hardware 'AS1428 Compliant Toilet Sign SILVER Unisex Disabled'
- SA10 - Bathroom mirror / dryer / soap by Bradley Australia 'Bradley behind mirror foam soap and hand dryer'
- SA11 - Toilet Roll Holder by Estilo 'Chrome Bela Single roll Holder'
- SA12 - Shower Mixer by The Blue Space 'Phoenix Vivid Slimline Shower/Wall Mixer'
- SA13 - Toilet flush button by Icon Bathware 'Invisi Series II'
- F104 - Sled Track by Raw Fitness Equipment 'Custom Gym Sled'
- LI01 - Light up Mirror by ATS Tiles and Bathroom 'Retti Rectangular LED Mirror'
- LI02 - LED Logo by Big Banner
- MA01 - Polished Concrete
- MA02 - GYM MAT
- MA03 - Custom Sled turf by Raw Fitness Equipment 'Custom Gym Sled'
- MA04 - Brick Lane Tiles by National Tiles
- MA05 - Paint finish by Porters Paints 'Mountain Ash'
- MA06 - Paint finish by Porters Paints 'Custom Frontline Green'
- MA07 - Tiles by National Tiles 'Zellige White Matt Tile'
- MA08 - Paint finish by Porters Paints 'Aniseed'
- MA09 - Cedar Wood

REVISIONS

No Date
01 27.10.21

Description
PRESENTATION DRAWINGS
NOT FOR CONSTRUCTION

Ver. App'd
XX App'd

Do not scale drawings. Use figured dimensions only. Check and verify levels and dimensions on site prior to commencement of any work, the preparation of drawings or the fabrication of components.
This drawing is copyright and can not be reproduced without written consent.

Client
Moey Faour



True North

Billy Blue College of Design
46-52 Mountain Street, Ultimo, NSW 2007, Australia
+61 (0)2 9999 9999



LAUREATE INTERNATIONAL UNIVERSITIES

Project

Frontline Fitness

630 Canterbury Road,
Belmore, NSW. 2192

Project number
01

Drawing Title

Section 3

Drawing Status


PRESENTATION
DRAWINGS
NOT FOR
CONSTRUCTION

Scale Drawing No Issue
1 : 25 D10 01

Date 27.10.21

Drawn by MB

6/12/2021 3:52:50 AM

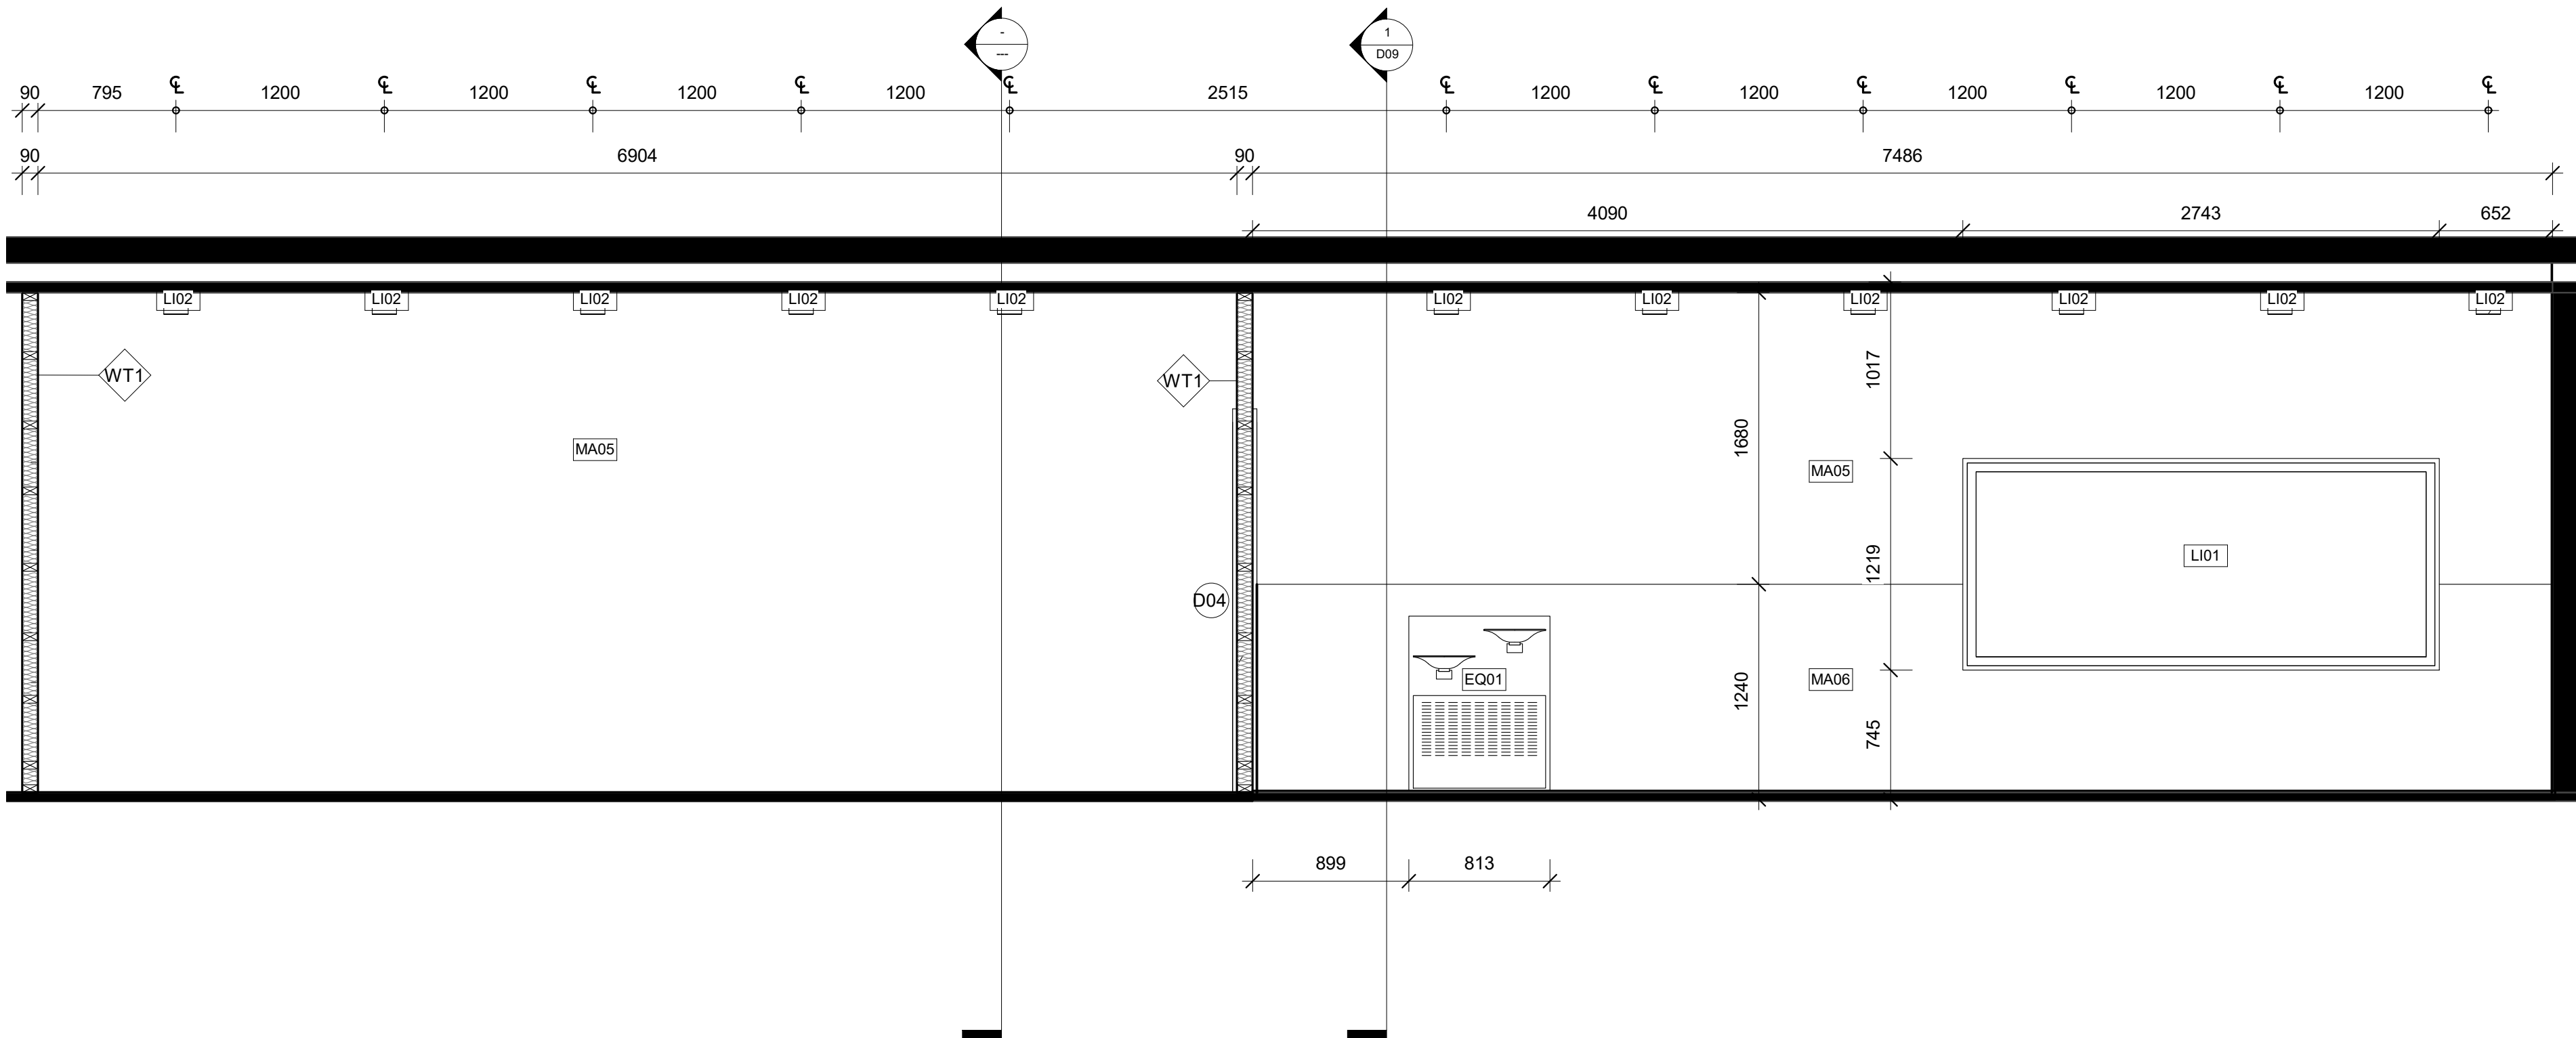

LEGEND

Cut Material

	Glass		Tiles
	Cedar		Plaster Board
	Concrete		Existing Structure
	Gym Mat		

Wall Types

	Timber stud wall 90mm x 45mm w/ 9mm Plaster board and Mountain Ash - Low sheen' Paint finish
	'Custom Frontline Green - Low sheen' Paint finish (1200mm H)
	Timber stud wall 90mm x 45mm w/ 12mm timber cedar top
	24mm Melamine (2400mm H)
	Timber stud wall 90mm x 45mm w/ 2mm glue + 6mm Bricklane tile
	Timber stud wall 90mm x 45mm w/ 2mm glue + 6mm square tile

Door Types

	915mm x 2134mm Flush w/ Blk Frame
	813mm x 2134mm Flush w/ Blk Frame
	762mm x 2000mm Toilet Cubicle Door
	915mm x 2134mm Glass w/ Blk Frame
	762mm x 2134mm Glass w/ Blk Frame

Window Types

	815mm x 2850mm Frosted Glass w/ Blk Frame
	815mm x 2210mm Glass w/ Blk Frame

Abbreviations

BLK	Black	SA	Sanitary
D0	Door	SS	Stainless Steel
EQ	Equipment	W0	Window
FI	Fixture	WT	Wall Type
FU	Furniture	W	With

Tag Legend

FU01 - 2x Medium Locker by Elite Office Furniture
FU02 - Chair by Colesse 'Joel'
FU03 - Chair by Colesse 'Sidewalk'
FU04 - 2 Seater Lounge by by Colesse 'Sidewalk'
FU05 - Coffee table by Metro 'Topo'
FU06 - Coffee table by Temple and Webster
FU07 - Office Chair by Colesse 'Bindu'
FU08 - Reception Desk by Elite Office Furniture 'Casnan Premier Sorento Reception Counter'
FU09 - Office Desk by Modern Furniture 'Aftan Executive Desk'
EQ01 - Drinking Fountain by Ffitne 'FOC-107-14-HL-VIP'
EQ02 - Treadmill by Nordic Track 'Sport 50'
EQ03 - Exercise bike by Nordic Track 'S10 Studio Bike'
EQ04 - Leg press by Aussie Fitness 'Gym King HS'
EQ05 - Gym Bench by Aussie Fitness 'Gym King Flat bench'
EQ06 - Squat Rack by Aussie Fitness 'Gym King Commercial Smith Machine'
EQ07 - Power Rack by Aussie Fitness 'Gym King Commercial Power Rack'
EQ08 - Dumbbell Rack by Commercial Fitness Equipment 'Titanium USA Monster Series'
EQ09 - Weight Rack by Sumo Strengh' barbarian Rack Package'
EQ10 - Sauna Panel by Jacuzzi Clearlight Saunas 'Custom Kit'
SA01 - Basin by Temple and Webster 'Tulip Wall Hung Basin'
SA02 - Toilet by Temple and Webster 'White Minna Rimless BTW'
SA03 - Shower Head by Temple and Webster '2 Piece Square Shower Head'
SA04 - Drain by Temple and Webster '11x11 Square Shower Grate Floor Drain'
SA05 - Disable toilet sign by Keeler Hardware 'AS1428 Compliant Toilet Sign SILVER Unisex Disabled'
SA10 - Bathroom mirror / dryer / soap by Bradley Australia 'Bradley behind mirror foam soap and hand dryer'
SA11 - Toilet Roll Holder by Estlio 'Chrome Bela Single roll Holder'
SA12 - Shower Mixer by The Blue Space 'Phoenix Vivid Slimline Shower/Wall Mixer'
SA13 - Toilet flush button by Icon Bathware 'Invisi Series II'
FI04 - Sled Track by Raw Fitness Equipment 'Custom Gym Sled'
LI01 - Light up Mirror by ATS Tiles and Bathroom 'Reti Rectangular LED Mirror'
LI02 - LED Logo by Big Banner
MA01 - Polished Concrete
MA02 - GYM MAT
MA03 - Custome Sled turf by Raw Fitness Equipment 'Custom Gym Sled'
MA04 - Brick Lane Tiles by National Tiles
MA05 - Paint finish by Porters Paints 'Mountain Ash'
MA06 - Paint finish by Porters Paints 'Custom Frontline Green'
MA07 - Tiles by National Tiles 'Zellige White Matt Tile'
MA08 - Paint finish by Porters Paints 'Aniseed'
MA09 - Cedar Wood

REVISIONS

No Date
01 27.10.21

Description
PRESENTATION DRAWINGS
NOT FOR CONSTRUCTION

Ver. App'd
XX App'd

Do not scale drawings. Use figured dimensions only. Check and verify levels and dimensions on site prior to commencement of any work, the preparation of drawings or the fabrication of components.
This drawing is copyright and can not be reproduced without written consent.

Client
Moey Faour



True North

Billy Blue College of Design
46-52 Mountain Street, Ultimo, NSW 2007, Australia
+61 (0)2 9999 9999



LAUREATE INTERNATIONAL UNIVERSITIES

Project

Frontline Fitness

630 Canterbury Road,
Belmore, NSW. 2192

Project number
01

Drawing Title

Section 4

Drawing Status


PRESENTATION
DRAWINGS
NOT FOR
CONSTRUCTION

Scale Drawing No Issue
1 : 25 D11 01

Date 27.10.21


Drawn by MB

6/12/2021 3:53:01 AM

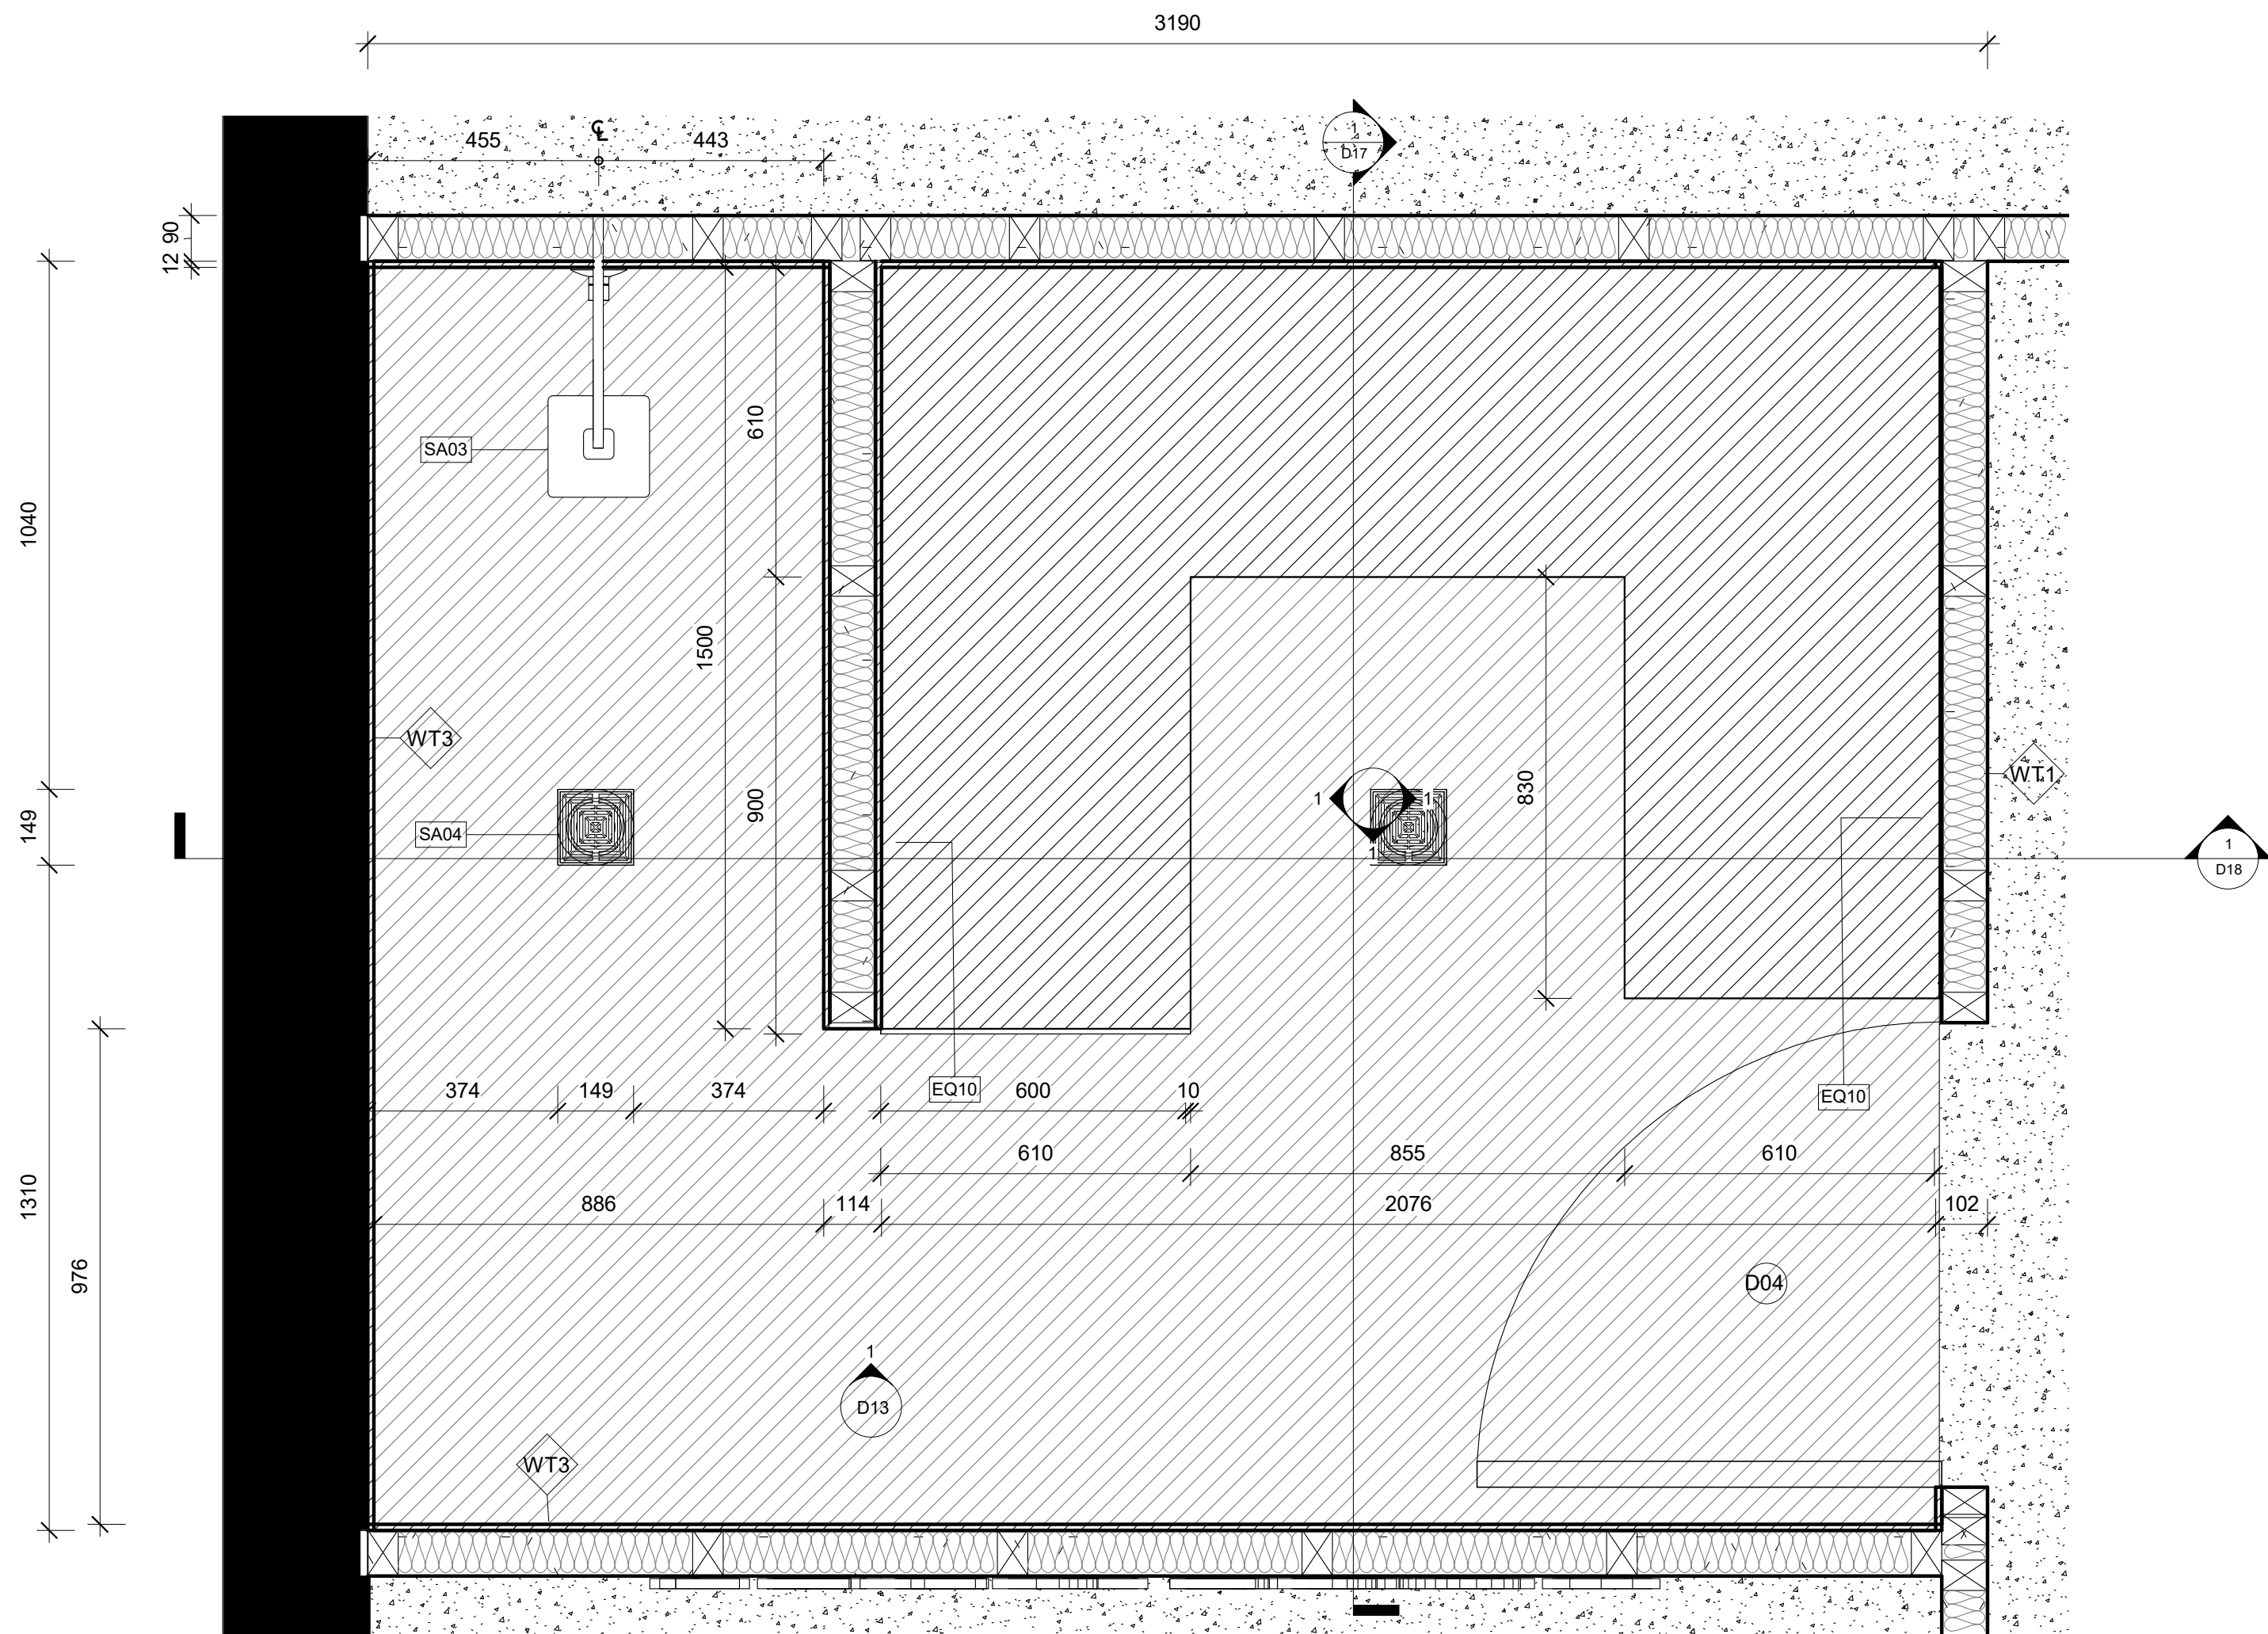

LEGEND	REVISIONS
Cut Material Glass Cedar Concrete Gym Mat Tiles Plaster Board Existing Structure Wall Types WT1 Timber stud wall 90mm x 45mm w/ 9mm Plaster board and 'Mountain Ash - Low sheen' Paint finish WT2 'Custom Frontline Green - Low sheen' Paint finish (1200mm H) WT3 Timber stud wall 90mm x 45mm w/ 12mm timber cedar top WT4 24mm Melamine (2400mm H) WT5 Timber stud wall 90mm x 45mm w/ 2mm glue + 6mm Bricklane tile WT6 Timber stud wall 90mm x 45mm w/ 2mm glue + 6mm square tile Door Types D01 915mm x 2134mm Flush w/ Blk Frame D02 813mm x 2134mm Flush w/ Blk Frame D03 762mm x 2000mm Toilet Cubicle Door D04 915mm x 2134mm Glass w/ Blk Frame D05 762mm x 2134mm Glass w/ Blk Frame Window Types W01 815mm x 2850mm Frosted Glass w/ Blk Frame W02 815mm x 2210mm Glass w/ Blk Frame Abbreviations BLK Black DO Door EQ Equipment FI Fixture FU Furniture SA SS WO Window WT Wall Type WI With Tag Legend FU01 - 2x Medium Locker by Elite Office Furniture FU02 - Chair by Colesse 'Joel' FU03 - Chair by Colesse 'Sidewalk' FU04 - 2 Seater Lounge by by Colesse 'Sidewalk' FU05 - Coffee table by Metro 'Topo' FU06 - Coffee table by Temple and Webster FU07 - Office Chair by Colesse 'Bindu' FU08 - Reception Desk by Elite Office Furniture 'Casnan Premier Sorrento Reception Counter' FU09 - Office Desk by Modern Furniture 'Aftan Executive Desk' EQ01 - Drinking Fountain by Fitline 'PCC-107-14-RL-VIP' EQ02 - Treadmill by Nordic Track 'Sport 50' EQ03 - Exercise bike by Nordic Track 'S10 Studio Bike' EQ04 - Leg press by Aussie Fitness 'Gym King HS' EQ05 - Gym Bench by Aussie Fitness 'Gym King Flat bench' EQ06 - Squat Rack by Aussie Fitness 'Gym King Commercial Smith Machine' EQ07 - Power Rack by Aussie Fitness 'Gym King Commercial Power Rack' EQ08 - Dumbell Rack by Commercial Fitness Equipment 'Titanium USA Monster Series' EQ09 - Weight Rack by Sumo Strength 'barbarian Rack Package' EQ10 - Sauna Panel by Jacuzzi Clearlight Saunas 'Custom Kit' SA01 - Basin by Temple and Webster 'Tulip Wall Hung Basin' SA02 - Toilet by Temple and Webster 'White Minna Rimless BTW' SA03 - Shower Head by Temple and Webster '2 Piece Square Shower Head' SA04 - Drain by Temple and Webster '11x11 Square Shower Grate Floor Drain' SA05 - Disable toilet sign by Keeler Hardware 'AS1428 Compliant Toilet Sign SILVER Unisex Disabled' SA10 - Bathroom mirror / dryer / soap by Bradley Australia 'caddy behind mirror foam soap and hand dryer' SA11 - Toilet Roll Holder by Estlio 'Chrome Bela Single roll Holder' SA12 - Shower Mixer by The Blue Space 'Phoenix Vivid Slimline Shower/Wall Mixer' SA13 - Toilet flush button by Icon Bathware 'Invisi Series IP' F104 - Sled Track by Raw Fitness Equipment 'Custom Gym Sled' LI01 - Light up Mirror by ATS Tiles and Bathroom 'Retti Rectangular LED Mirror' LI02 - LED Logo by Big Banner MA01 - Polished Concrete MA02 - GYM MAT MA03 - Custom Sled turf by Raw Fitness Equipment 'Custom Gym Sled' MA04 - Brick Lane Tiles by National Tiles MA05 - Paint finish by Porters Paints 'Mountain Ash' MA06 - Paint finish by Porters Paints 'Custom Frontline Green' MA07 - Tiles by National Tiles 'Zellige White Matt Tile' MA08 - Paint finish by Porters Paints 'Aniseed' MA09 - Cedar Wood No Date 01 27.10.21 Description PRESENTATION DRAWINGS NOT FOR CONSTRUCTION Ver. App'd XX App'd Do not scale drawings. Use figured dimensions only. Check and verify levels and dimensions on site prior to commencement of any work, the preparation of drawings or the fabrication of components. This drawing is copyright and can not be reproduced without written consent. Client Moey Faour Frontline Fitness LEADING FROM THE FRONT True North Billy Blue College of Design 46-52 Mountain Street, Ultimo, NSW 2007, Australia +61 (0)2 9999 9999 BILLY BLUE COLLEGE OF DESIGN™ TORRENS UNIVERSITY AUSTRALIA LAUREATE INTERNATIONAL UNIVERSITIES Project Frontline Fitness 630 Canterbury Road, Belmore, NSW. 2192 Project number 01 Drawing Title Infrared Sauna Plan Drawing Status PRESENTATION DRAWINGS NOT FOR CONSTRUCTION Scale 1 : 10 Drawing No D12 Issue 01 Date 27.10.21 Drawn by MB	

6/12/2021 3:53:07 AM

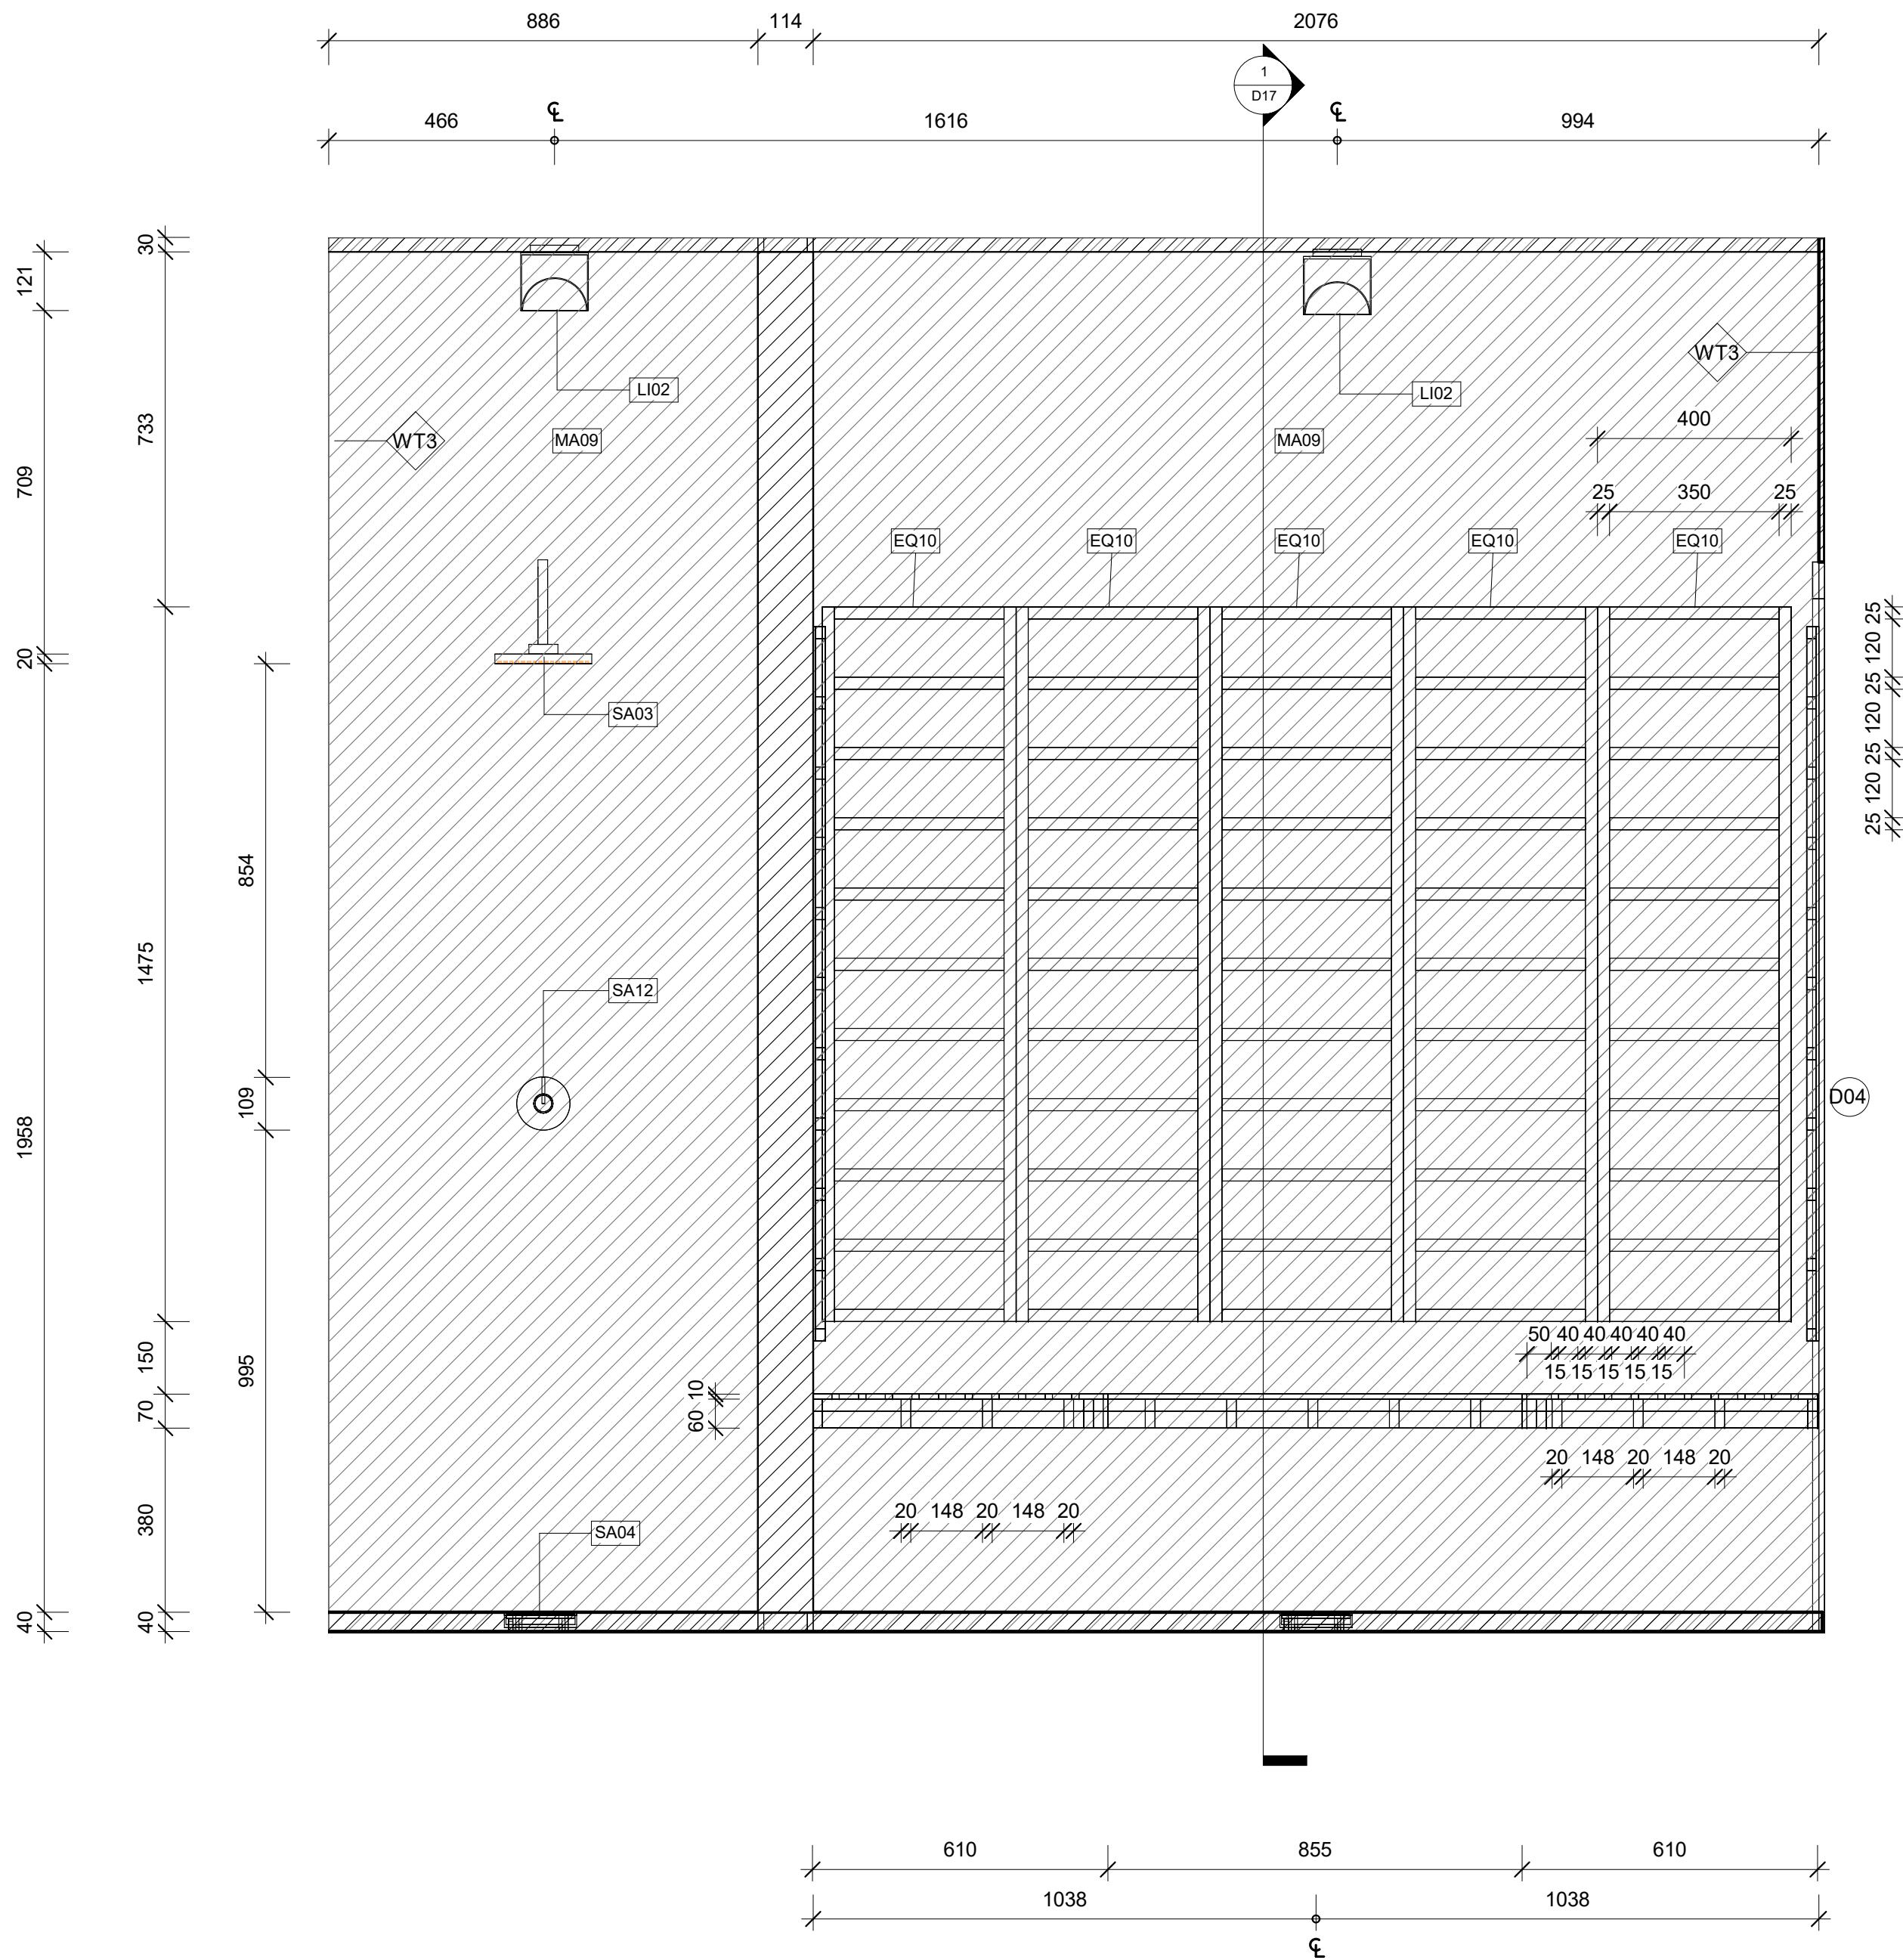

LEGEND

Cut Material

	Glass		Tiles
	Cedar		Plaster Board
	Concrete		Existing Structure
	Gym Mat		

Wall Types

	WT1	Timber stud wall 90mm x 45mm w/ 9mm Plaster board and 'Mountain Ash - Low sheen' Paint finish
	WT2	'Custom Frontline Green - Low sheen' Paint finish (1200mm H)
	WT3	Timber stud wall 90mm x 45mm w/ 12mm timber cedar top
	WT4	24mm Melamine (2400mm H)
	WT5	Timber stud wall 90mm x 45mm w/ 2mm glue + 6mm Bricklane tile
	WT6	Timber stud wall 90mm x 45mm w/ 2mm glue + 6mm square tile

Door Types

	D01	915mm x 2134mm Flush w/ Blk Frame
	D02	813mm x 2134mm Flush w/ Blk Frame
	D03	762mm x 2000mm Toilet Cubicle Door
	D04	915mm x 2134mm Glass w/ Blk Frame
	D05	762mm x 2134mm Glass w/ Blk Frame

Window Types

	W01	815mm x 2850mm Frosted Glass w/ Blk Frame
	W02	815mm x 2210mm Glass w/ Blk Frame

Abbreviations

BLK	Black	SA	Sanitary
D0	Door	SS	Stainless Steel
EQ	Equipment	WD	Window
FI	Fixture	WT	Wall Type
FU	Furniture	W	With

Tag Legend

FU01 -	2x Medium Locker by Elite Office Furniture
FU02 -	Chair by Coalesse 'Joel'
FU03 -	Chair by Coalesse 'Sidewalk'
FU04 -	2 Seater Lounge by Coalesse 'Sidewalk'
FU05 -	Coffee table by Metro 'Topo'
FU06 -	Coffee table by Temple and Webster
FU07 -	Office Chair by Coalesse 'Bindu'
FU08 -	Reception Desk by Elite Office Furniture 'Casnan Premier Sorrento Reception Counter'
FU09 -	Office Desk by Modern Furniture 'Atlan Executive Desk'
EQ01 -	Drinking Fountain by Filtrine FCC-107-14-HL-VP
EQ02 -	Treadmill by Nordic Track 'Sport 50'
EQ03 -	Exercise bike by Nordic Track 'S10 Studio Bike'
EQ04 -	Leg press by Aussie Fitness 'Gym King HS'
EQ05 -	Gym Bench by Aussie Fitness 'Gym King Flat bench'
EQ06 -	Squat Rack by Aussie Fitness 'Gym King Commercial Smith Machine'
EQ07 -	Power Rack by Aussie Fitness 'Gym King Commercial Power Rack'
EQ08 -	Dumbbell Rack by Commercial Fitness Equipment Titanium USA Monster Series
EQ09 -	Weight Rack by Sumo Strength 'barbarian Rack Package'
EQ10 -	Sauna Panel by Jacuzzi Clearlight Saunas 'Custom Kit'
SA01 -	Basin by Temple and Webster 'Tulip Wall Hung Basin'
SA02 -	Toilet by Temple and Webster 'White Minna Rimless BTW'
SA03 -	Shower Head by Temple and Webster '2 Piece Square Shower Head'
SA04 -	Drain by Temple and Webster '11x11 Square Shower Grate Floor Drain'
SA05 -	Disable toilet sign by Keeler Hardware 'AS1428 Compliant Toilet Sign SILVER Unisex Disabled'
SA10 -	Bathroom mirror / dryer / soap by Bradley Australia 'tradelight behind mirror foam soap and hand dryer'
SA11 -	Toilet Roll Holder by Estlio 'Chrome Bela Single roll Holder'
SA12 -	Shower Mixer by The Blue Space 'Phoenix Vivid Slimline Shower/Wall Mixer'
SA13 -	Toilet flush button by Icon Bathware 'Invisi Series II'
F104 -	Sled Track by Raw Fitness Equipment 'Custom Gym Sled'
LI01 -	Light up Mirror by ATS Tiles and Bathroom 'Retti Rectangular LED Mirror'
LI02 -	LED Logo by Big Banner
MA01 -	Polished Concrete
MA02 -	Gym Mat
MA03 -	Custom Sled turf by Raw Fitness Equipment 'Custom Gym Sled'
MA04 -	Brick Lane Tiles by National Tiles
MA05 -	Paint finish by Porters Paints 'Mountain Ash'
MA06 -	Paint finish by Porters Paints 'Custom Frontline Green'
MA07 -	Tiles by National Tiles 'Zellige White Matt Tile'
MA08 -	Paint finish by Porters Paints 'Anisced'
MA09 -	Cedar Wood

REVISIONS

No Date
01 27.10.21

Description
PRESENTATION DRAWINGS
NOT FOR CONSTRUCTION

Ver. App'd
XX App'd

Do not scale drawings. Use figured dimensions only. Check and verify levels and dimensions on site prior to commencement of any work, the preparation of drawings or the fabrication of components.
This drawing is copyright and can not be reproduced without written consent.

Client

Moey Faour



Frontline Fitness

True North

Billy Blue College of Design
46-52 Mountain Street, Ultimo, NSW 2007, Australia
+61 (0)2 9999 9999



LAUREATE INTERNATIONAL UNIVERSITIES

Project

Frontline Fitness

630 Canterbury Road,
Belmore, NSW. 2192

Project number

01

Drawing Title

Infrared Sauna Elevation 1


Drawing Status

PRESENTATION
DRAWINGS
NOT FOR
CONSTRUCTION

Scale Drawing No Issue
1 : 10 D13 01


Date 27.10.21

Drawn by MB

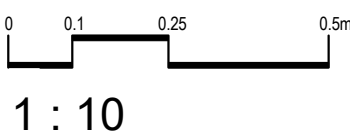

1 : 10

6/12/2021 3:53:12 AM

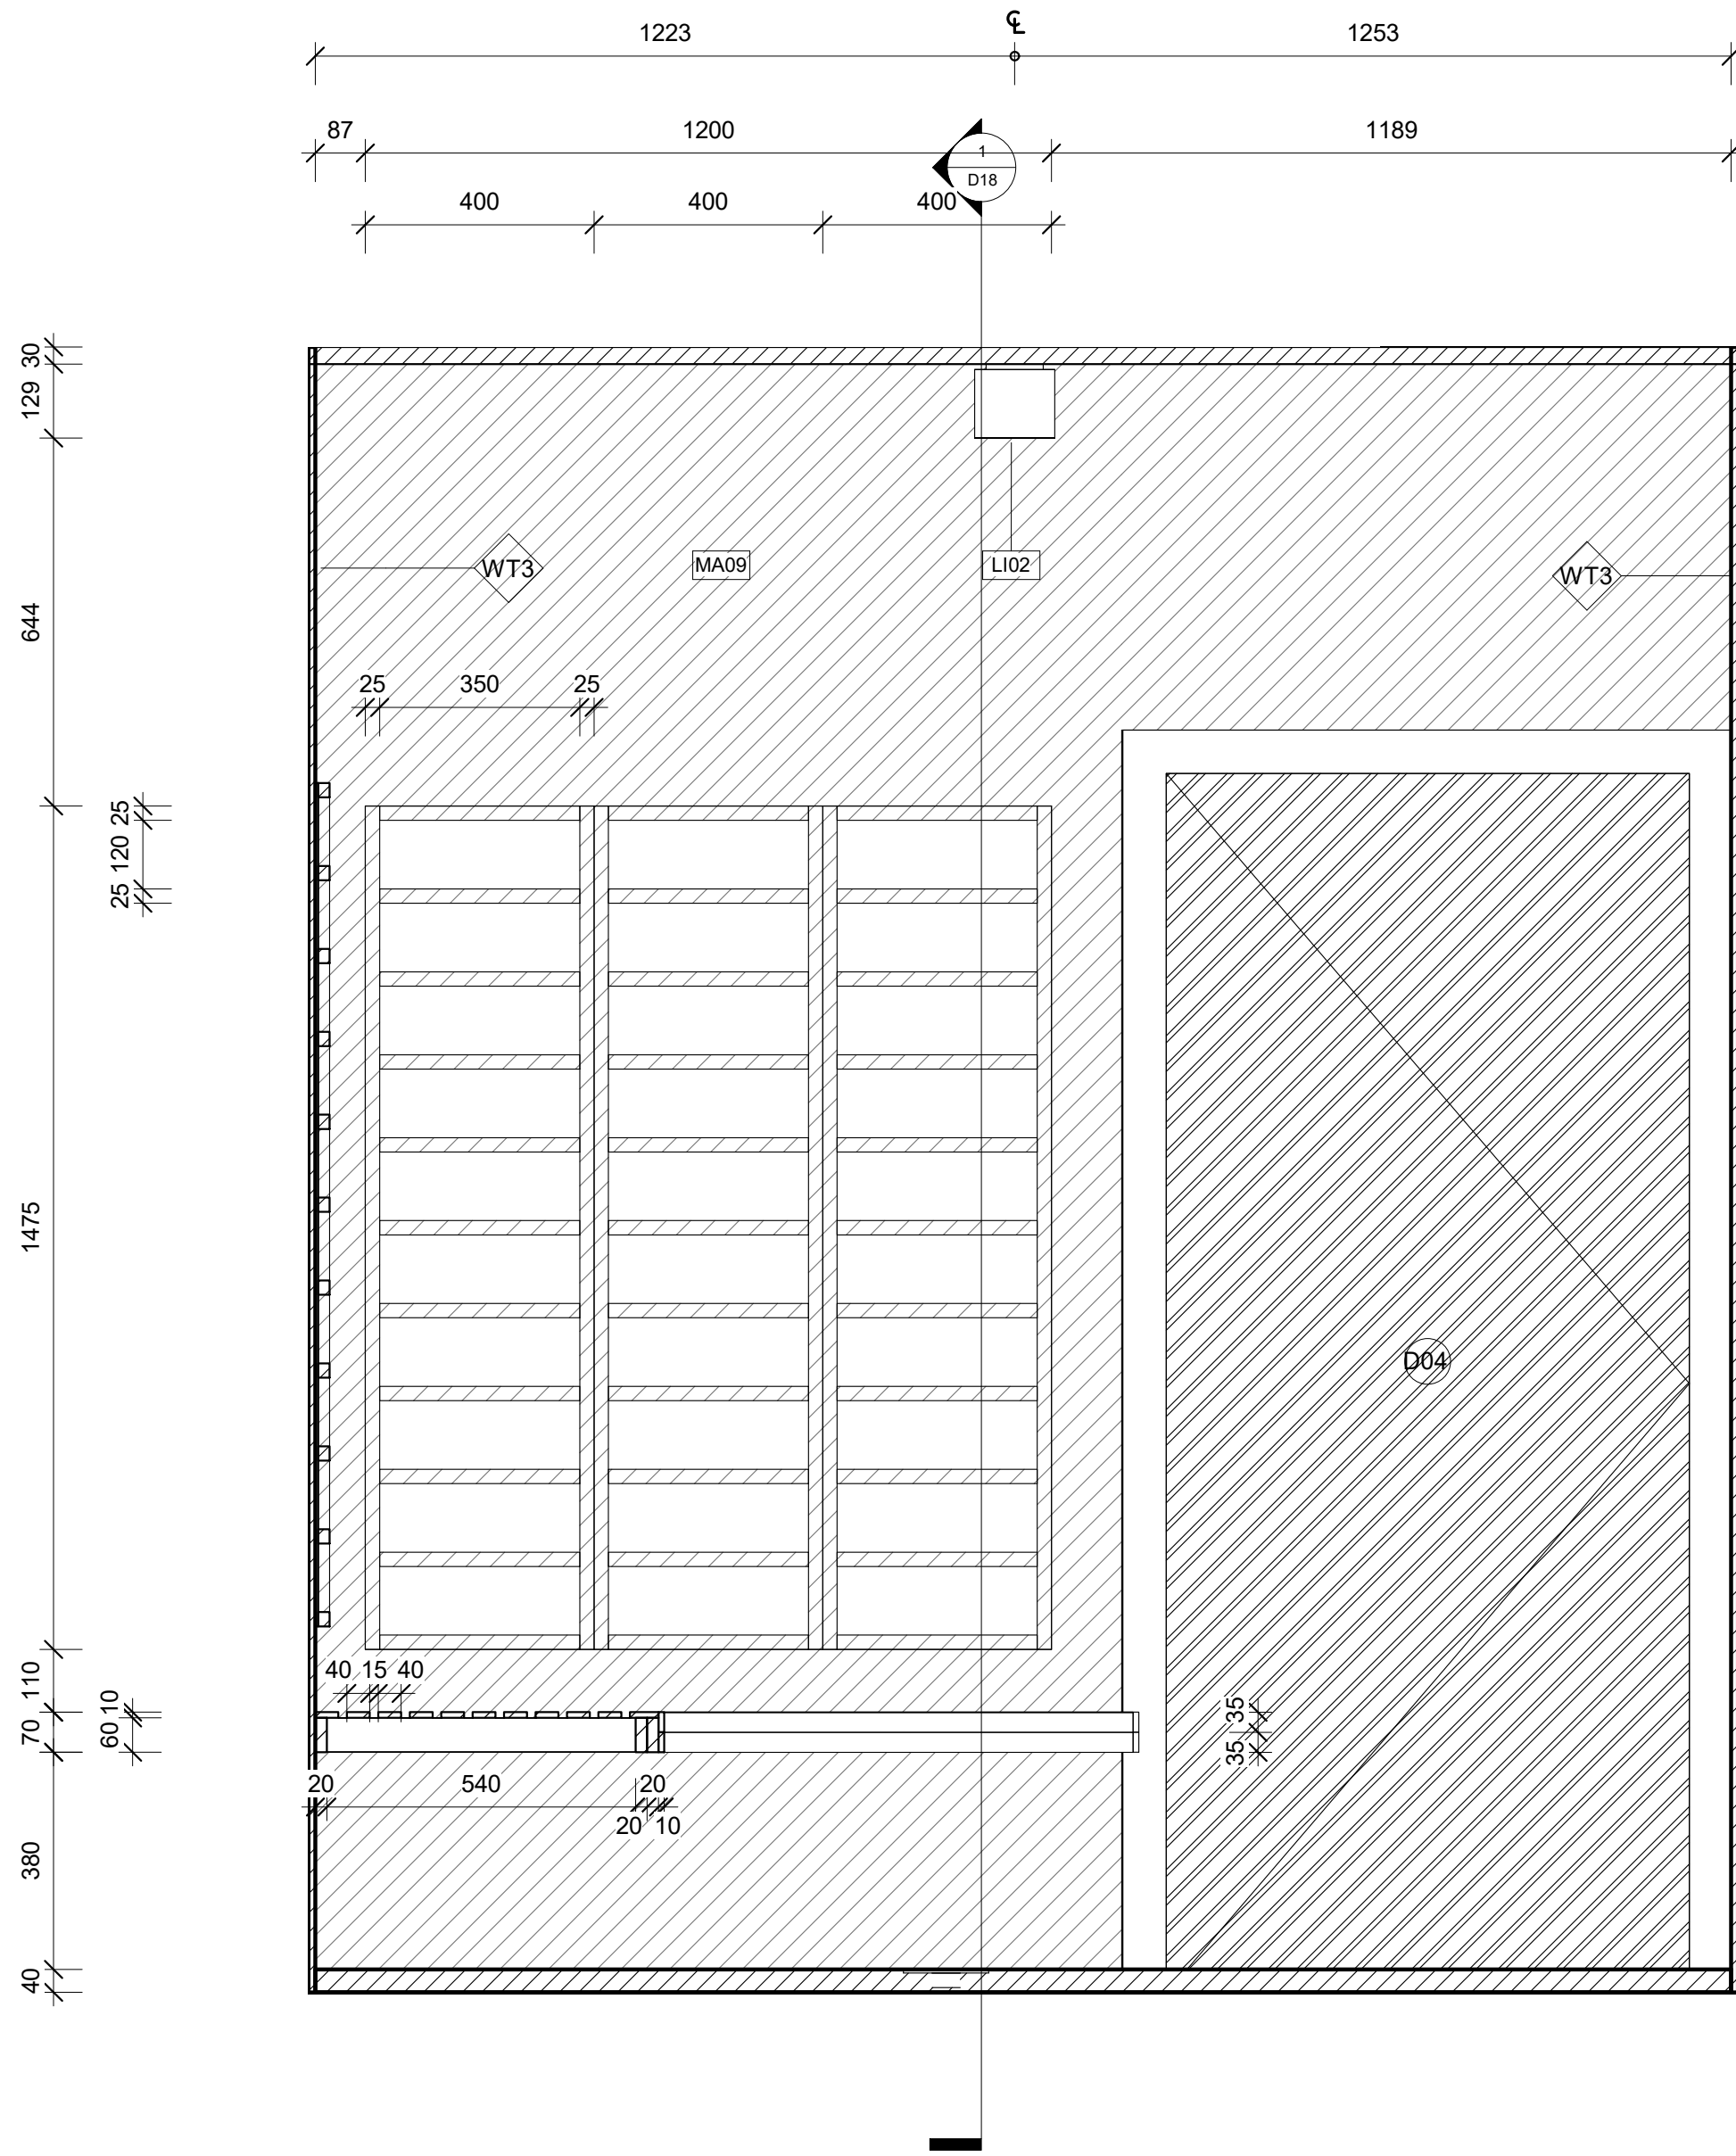

LEGEND

Cut Material

	Glass		Tiles
	Cedar		Plaster Board
	Concrete		Existing Structure
	Gym Mat		

Wall Types

	Timber stud wall 90mm x 45mm w/ 9mm Plaster board and 'Mountain Ash - Low sheer' Paint finish
	'Custom Frontline Green - Low sheer' Paint finish (1200mm H)
	Timber stud wall 90mm x 45mm w/ 12mm timber cedar top
	24mm Melamine (2400mm H)
	Timber stud wall 90mm x 45mm w/ 2mm glue + 6mm Bricklane tile
	Timber stud wall 90mm x 45mm w/ 2mm glue + 6mm square tile

Door Types

	915mm x 2134mm Flush w/ Blk Frame
	813mm x 2134mm Flush w/ Blk Frame
	762mm x 2000mm Toilet Cubicle Door
	915mm x 2134mm Glass w/ Blk Frame
	762mm x 2134mm Glass w/ Blk Frame

Window Types

	815mm x 2850mm Frosted Glass w/ Blk Frame
	815mm x 2210mm Glass w/ Blk Frame

Abbreviations

BLK	Black	SA	Sanitary
D0	Door	SS	Stainless Steel
EQ	Equipment	W0	Window
FI	Fixture	WT	Wall Type
FU	Furniture	W/	With

Tag Legend

FU01 - 2x Medium Locker by Elite Office Furniture
FU02 - Chair by Colesse 'Jedi'
FU03 - Chair by Colesse 'Sidewalk'
FU04 - 2 Seater Lounge by by Colesse 'Sidewalk'
FU05 - Coffee table by Metro 'Topo'
FU06 - Coffee table by Temple and Webster
FU07 - Office Chair by Colesse 'Bundu'
FU08 - Reception Desk by Elite Office Furniture 'Casnan Premier Sorento Reception Counter'
FU09 - Office Desk by Modern Furniture 'Aftan Executive Desk'
EQ01 - Drinking Fountain by Filtrine 'FCG-107-14-HLVP'
EQ02 - Treadmill by Nordic Track 'Sport 50'
EQ03 - Exercise bike by Nordic Track 'S10i Studio Bike'
EQ04 - Leg press by Aussie Fitness 'Gym King HS'
EQ05 - Gym Bench by Aussie Fitness 'Gym King Flat bench'
EQ06 - Squat Rack by Aussie Fitness 'Gym King Commercial Smith Machine'
EQ07 - Power Rack by Aussie Fitness 'Gym King Commercial Power Rack'
EQ08 - Dumbbell Rack by Commercial Fitness Equipment 'Titanium USA Monster Series'
EQ09 - Weight Rack by Sumo Strenght 'barbarian Rack Package'
EQ10 - Sauna Panel by Jacuzzi Clearlight Saunas 'Custom Kit'
SA01 - Basin by Temple and Webster 'Tulip Wall Hung Basin'
SA02 - Toilet by Temple and Webster 'White Minna Rimless BTW'
SA03 - Shower Head by Temple and Webster '2 Piece Square Shower Head'
SA04 - Drain by Temple and Webster '11x11 Square Shower Grate Floor Drain'
SA05 - Disable toilet sign by Keeler Hardware 'AS1428 Compliant Toilet Sign SILVER Unisex Disabled'
SA10 - Bathroom mirror / dryer / soap by Bradley Australia 'Bradley behind mirror foam soap and hand dryer'
SA11 - Toilet Roll Holder by Estilo 'Chrome Bela Single roll Holder'
SA12 - Shower Mixer by The Blue Space 'Phoenix Vivid Slimline Shower/Wall Mixer'
SA13 - Toilet flush button by Ikon Bathware 'Invisi Series II'
F104 - Sled Track by Raw Fitness Equipment 'Custom Gym Sled'
LI01 - Light up Mirror by ATS Tiles and Bathroom 'Retti Rectangular LED Mirror'
LI02 - LED Logo by Big Banner
MA01 - Polished Concrete
MA02 - GYM MAT
MA03 - Custom Sled turf by Raw Fitness Equipment 'Custom Gym Sled'
MA04 - Brick Lane Tiles by National Tiles
MA05 - Paint finish by Porters Paints 'Mountain Ash'
MA06 - Paint finish by Porters Paints 'Custom Frontline Green'
MA07 - Tiles by National Tiles 'Zellige White Matt Tile'
MA08 - Paint finish by Porters Paints 'Antised'
MA09 - Cedar Wood

REVISIONS

No Date
01 27.10.21

Description
PRESENTATION DRAWINGS
NOT FOR CONSTRUCTION

Ver. App'd
XX App'd

Do not scale drawings. Use figured dimensions only. Check and verify levels and dimensions on site prior to commencement of any work, the preparation of drawings or the fabrication of components.
This drawing is copyright and can not be reproduced without written consent.

Client

Moey Faour



True North

True North

Billy Blue College of Design
46-52 Mountain Street, Ultimo, NSW 2007, Australia
+61 (0)2 9999 9999



Project

Frontline Fitness

630 Canterbury Road,
Belmore, NSW. 2192

Project number

01

Drawing Title

Infrared Sauna Elevation 2


Drawing Status

PRESENTATION
DRAWINGS
NOT FOR
CONSTRUCTION


Scale Drawing No Issue
1 : 10 D14 01

Date 27.10.21

Drawn by MB

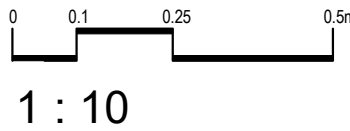

6/12/2021 3:53:17 AM

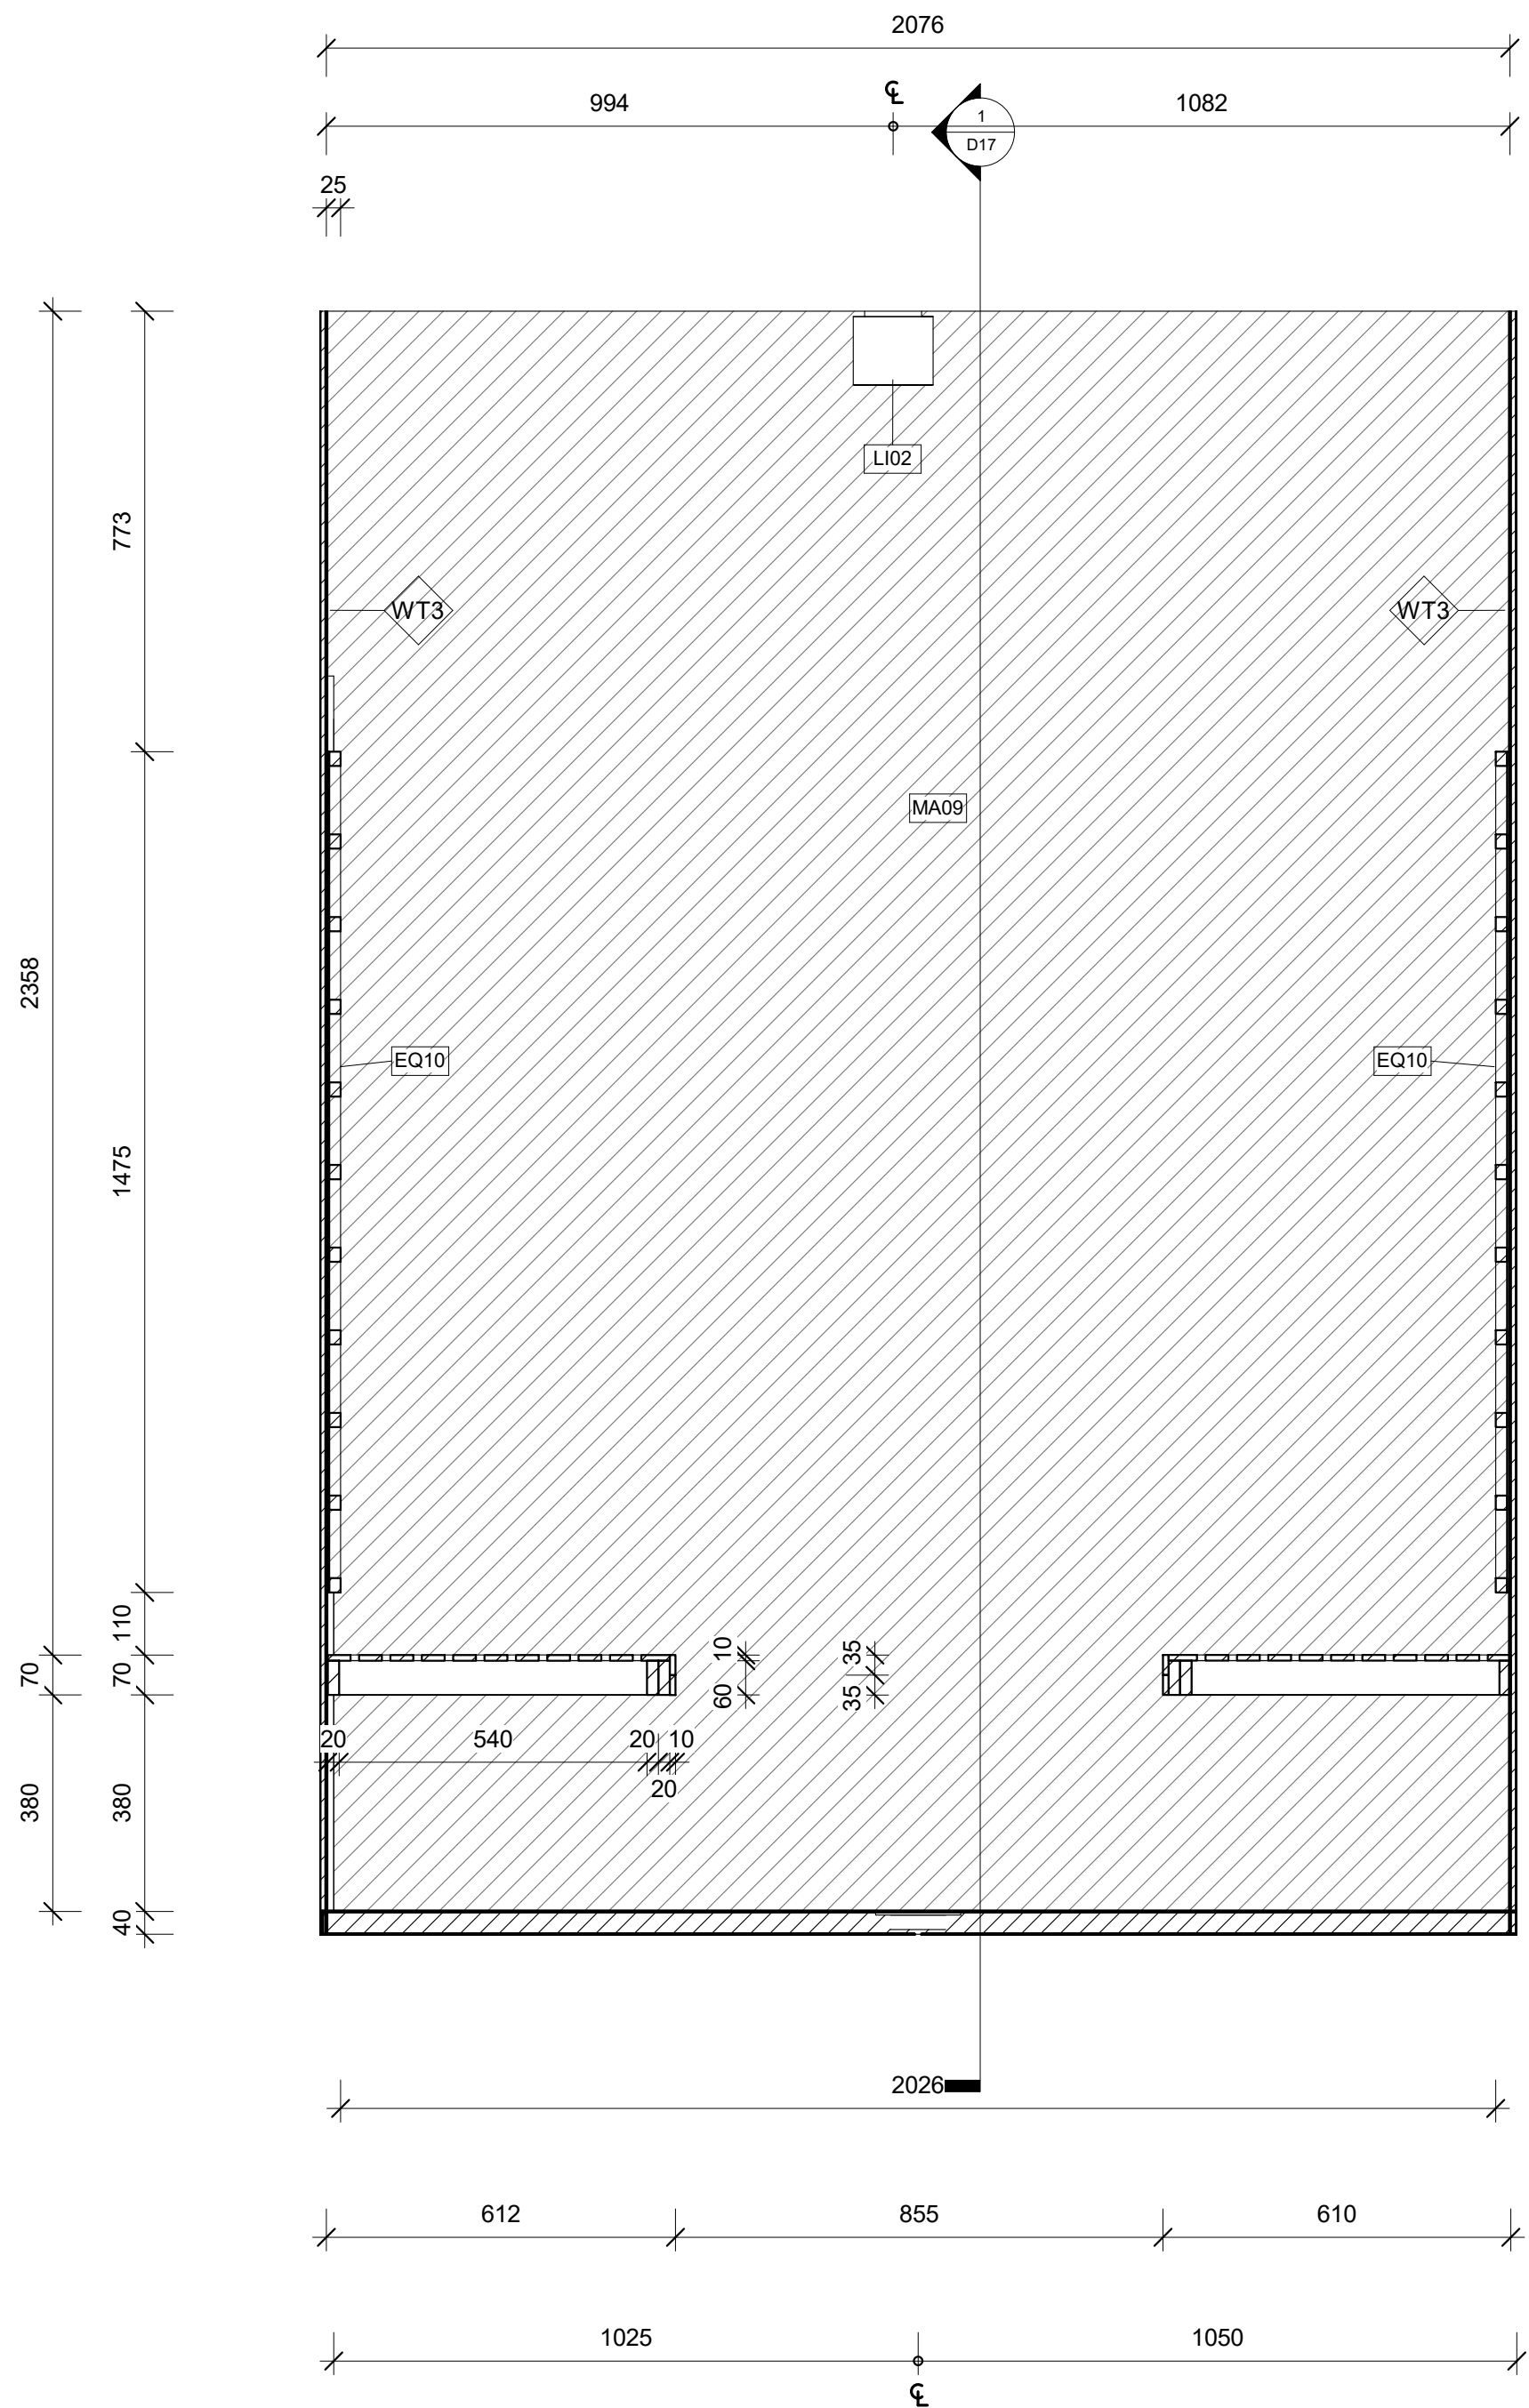

LEGEND

Cut Material

	Glass		Tiles
	Cedar		Plaster Board
	Concrete		Existing Structure
	Gym Mat		

Wall Types

	Timber stud wall 90mm x 45mm w/ 9mm Plaster board and 'Mountain Ash - Low sheen' Paint finish
	'Custom Frontline Green - Low sheen' Paint finish (1200mm H)
	Timber stud wall 90mm x 45mm w/ 12mm timber cedar top
	24mm Melamine (2400mm H)
	Timber stud wall 90mm x 45mm w/ 2mm glue + 6mm Bricklane tile
	Timber stud wall 90mm x 45mm w/ 2mm glue + 6mm square tile

Door Types

	915mm x 2134mm Flush w/ Blk Frame
	813mm x 2134mm Flush w/ Blk Frame
	762mm x 2000mm Toilet Cubicle Door
	915mm x 2134mm Glass w/ Blk Frame
	762mm x 2134mm Glass w/ Blk Frame

Window Types

	815mm x 2850mm Frosted Glass w/ Blk Frame
	815mm x 2210mm Glass w/ Blk Frame

Abbreviations

BLK	Black	SA	Sanitary
D0	Door	SS	Stainless Steel
EQ	Equipment	W0	Window
FI	Fixture	WT	Wall Type
FU	Furniture	W/	With

Tag Legend

FU01 - 2x Medium Locker by Elite Office Furniture
FU02 - Chair by Coalesse 'Joel'
FU03 - Chair by Coalesse 'Sidewalk'
FU04 - 2 Seater Lounge by by Coalesse 'Sidewalk'
FU05 - Coffee table by Metro 'Topo'
FU06 - Coffee table by Temple and Webster
FU07 - Office Chair by Coalesse 'Bindu'
FU08 - Reception Desk by Elite Office Furniture 'Casnan Premier Sorento Reception Counter'
FU09 - Office Desk by Modern Furniture 'Atlan Executive Desk'
EQ01 - Drinking Fountain by Filtrine 'FCC-107-14-HL-VP'
EQ02 - Treadmill by Nordic Track 'Sport 50'
EQ03 - Exercise bike by Nordic Track 'S10 Studio Bike'
EQ04 - Leg press by Aussie Fitness 'Gym King HS'
EQ05 - Gym Bench by Aussie Fitness 'Gym King Flat bench'
EQ06 - Squat Rack by Aussie Fitness 'Gym King Commercial Smith Machine'
EQ07 - Power Rack by Aussie Fitness 'Gym King Commercial Power Rack'
EQ08 - Dumbbell Rack by Commercial Fitness Equipment 'Titanium USA Monster Series'
EQ09 - Weight Rack by Sumo Strenghtr 'barbarian Rack Package'
EQ10 - Sauna Panel by Jacuzzi Clearlight Saunas 'Custom Kit'
SA01 - Basin by Temple and Webster 'Tulip Wall Hung Basin'
SA02 - Toilet by Temple and Webster 'White Mina Fitness BTW'
SA03 - Shower Head by Temple and Webster '2 Piece Square Shower Head'
SA04 - Drain by Temple and Webster '11x11 Square Shower Grate Floor Drain'
SA08 - Disable toilet sign by Keeler Hardware 'AS1428 Compliant Toilet Sign SILVER Unisex Disabled'
SA10 - Bathroom mirror / dryer / soap by Bradley Australia 'Bradley behind mirror foam soap and hand dryer'
SA11 - Toilet Roll Holder by Ealiso 'Chrome Bella Single roll Holder'
SA12 - Shower Mixer by The Blue Space 'Phoenix Vivid Slimline Shower/Wall Mixer'
SA13 - Toilet flush button by Icon Bathware 'Invisi Series II'
FI04 - Sled Track by Raw Fitness Equipment 'Custom Gym Sled'
LI01 - Light up Mirror by ATS Tiles and Bathroom 'Retti Rectangular LED Mirror'
LI02 - LED Logo by Big Banner
MA01 - Polished Concrete
MA02 - GYM MAT
MA03 - Custom Sled turf by Raw Fitness Equipment 'Custom Gym Sled'
MA04 - Brick Lane Tiles by National Tiles
MA05 - Paint finish by Porters Paints 'Mountain Ash'
MA06 - Paint finish by Porters Paints 'Custom Frontline Green'
MA07 - Tiles by National Tiles 'Zellige White Matt Tile'
MA08 - Paint finish by Porters Paints 'Aristeod'
MA09 - Cedar Wood

REVISIONS

No Date
01 27.10.21

Description
PRESENTATION DRAWINGS
NOT FOR CONSTRUCTION

Ver. App'd
XX App'd

Do not scale drawings. Use figured dimensions only. Check and verify levels and dimensions on site prior to commencement of any work, the preparation of drawings or the fabrication of components.
This drawing is copyright and can not be reproduced without written consent.

Client

Moey Faour



True North

Billy Blue College of Design
46-52 Mountain Street, Ultimo, NSW 2007, Australia
+61 (0)2 9999 9999



LAUREATE INTERNATIONAL UNIVERSITIES

Project

Frontline Fitness

630 Canterbury Road,
Belmore, NSW. 2192

Project number

01

Drawing Title

Infrared Sauna Elevation 3

Drawing Status

PRESENTATION
DRAWINGS
NOT FOR
CONSTRUCTION


Scale Drawing No Issue
1 : 10 D15 01

Date 27.10.21

Drawn by MB

0 0.1 0.25 0.5m
1 : 10

6/12/2021 3:53:25 AM

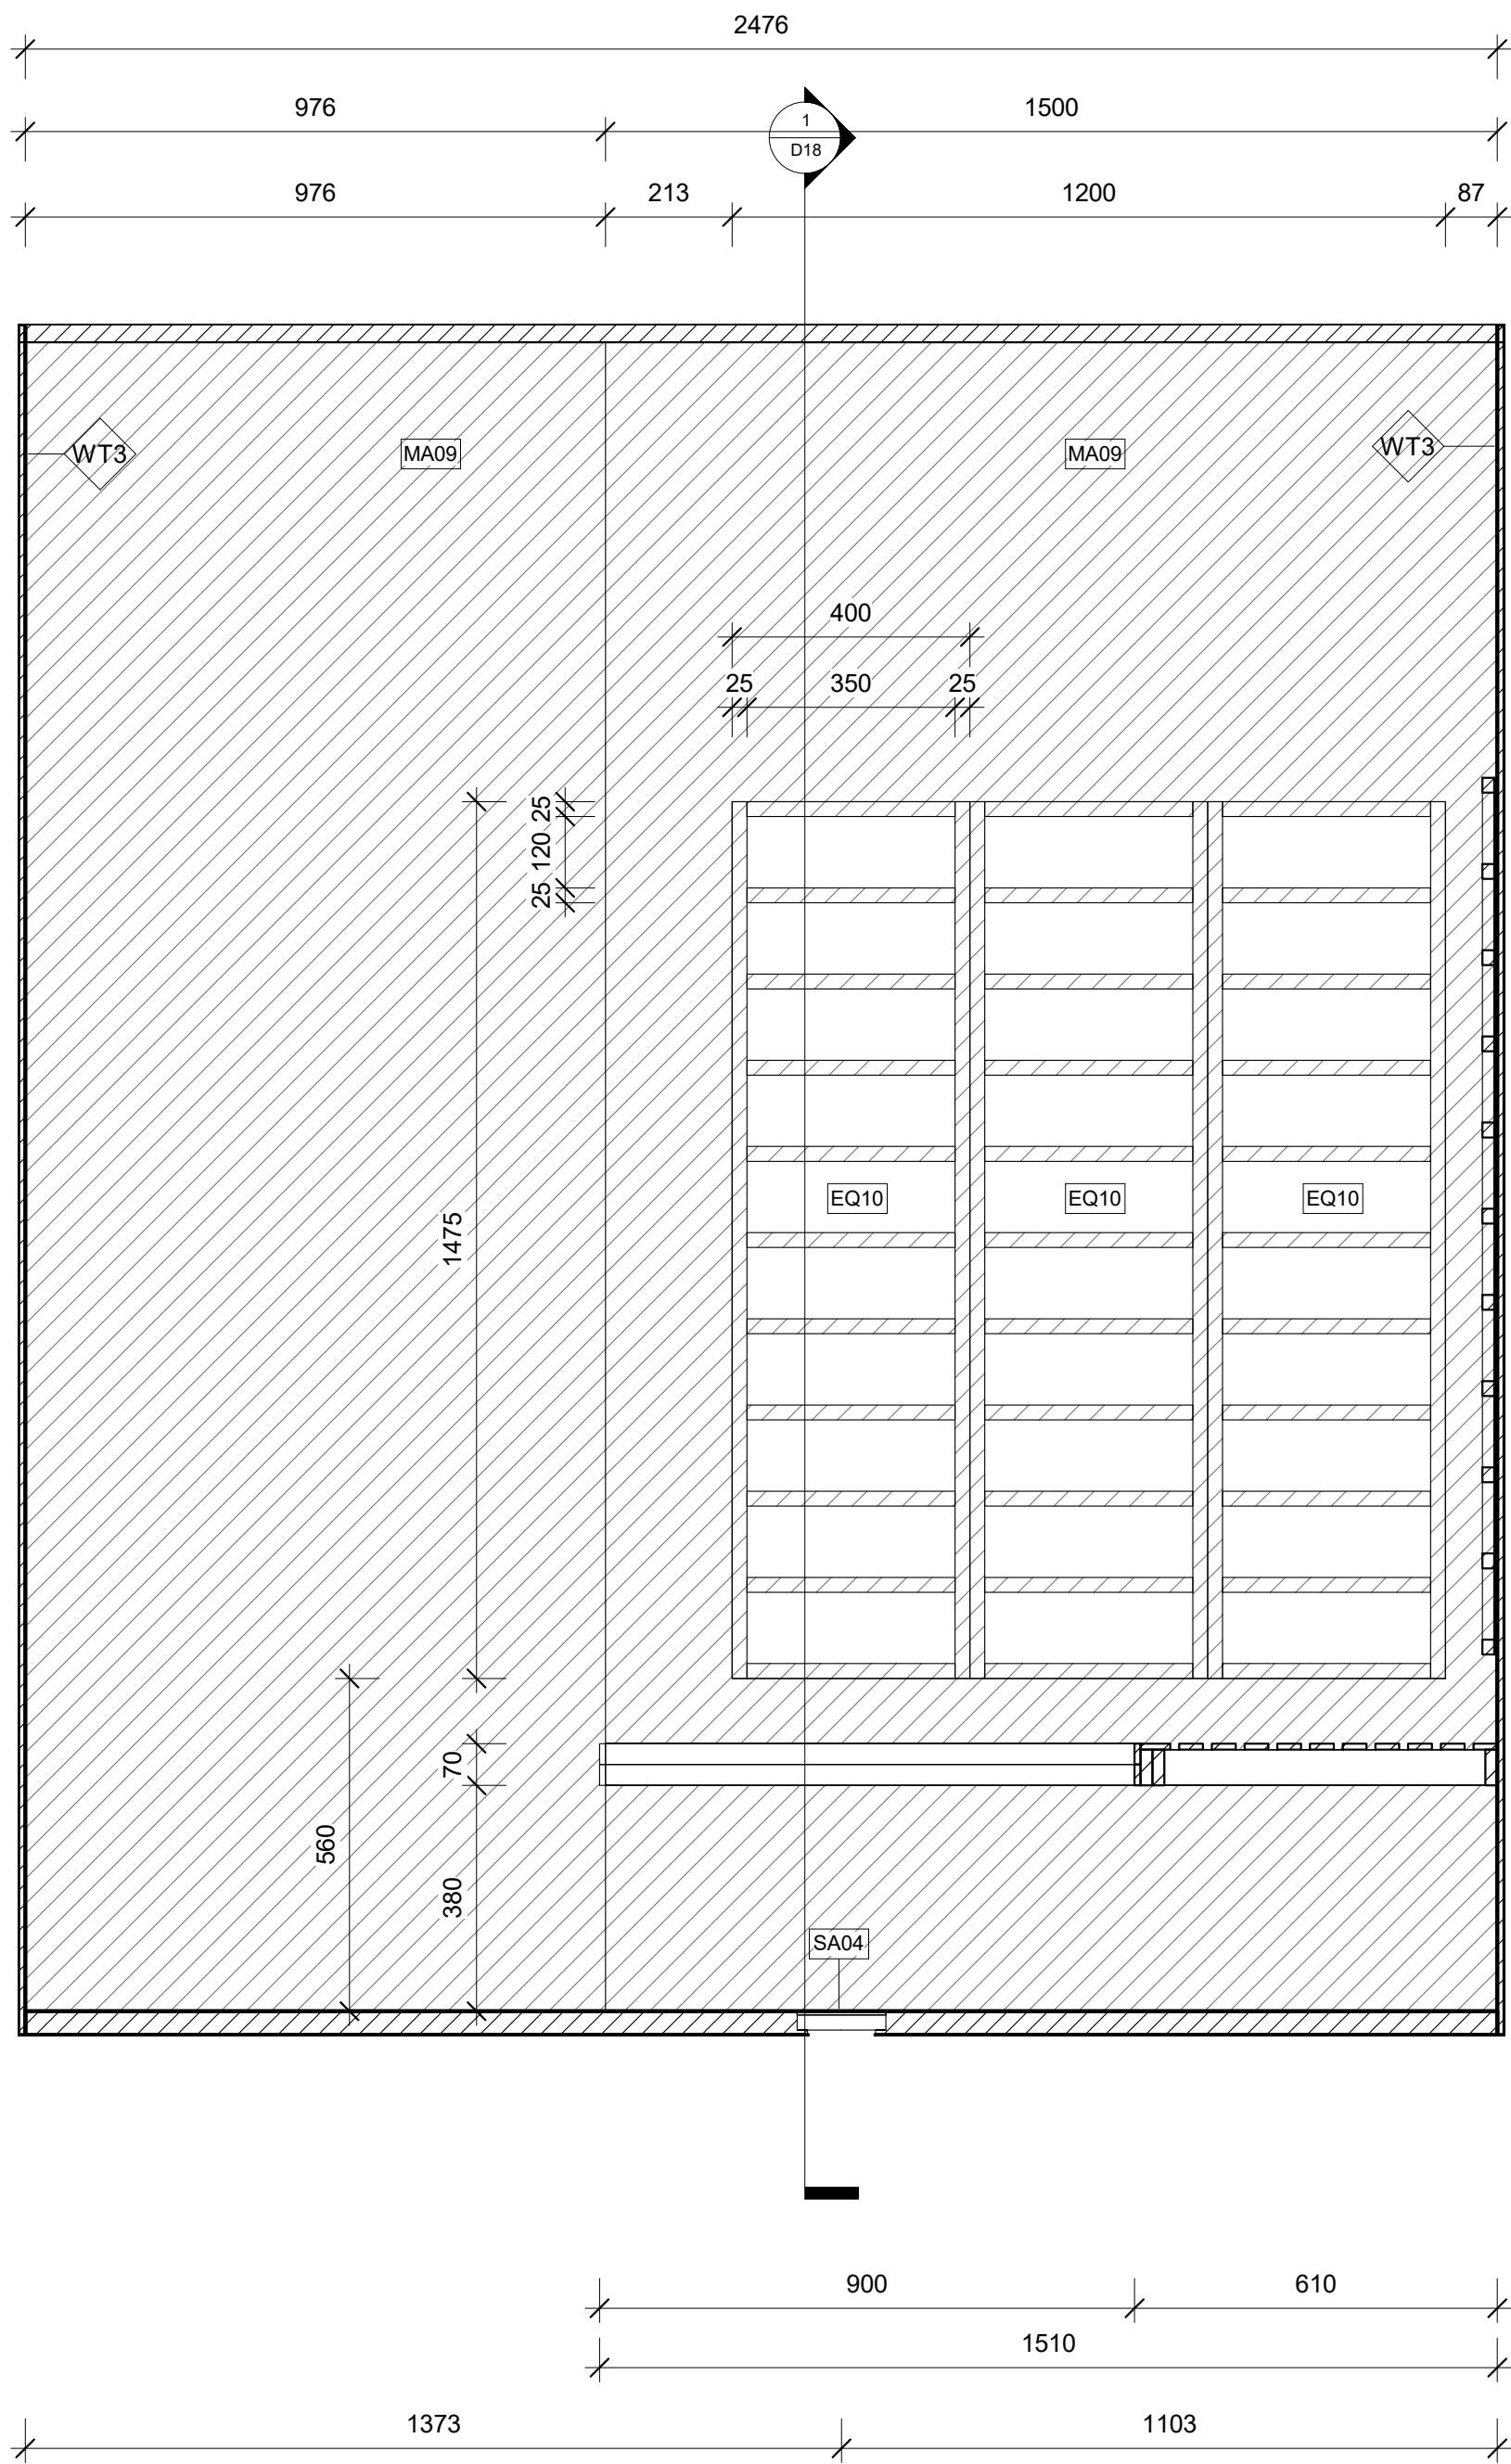

LEGEND

Cut Material

	Glass		Tiles
	Cedar		Plaster Board
	Concrete		Existing Structure
	Gym Mat		

Wall Types

	WT1	Timber stud wall 90mm x 45mm w/ 9mm Plaster board and 'Mountain Ash - Low sheen' Paint finish
	WT2	'Custom Frontline Green - Low sheen' Paint finish (1200mm H)
	WT3	Timber stud wall 90mm x 45mm w/ 12mm timber cedar top
	WT4	24mm Melamine (2400mm H)
	WT5	Timber stud wall 90mm x 45mm w/ 2mm glue + 6mm Bricklane tile
	WT6	Timber stud wall 90mm x 45mm w/ 2mm glue + 6mm square tile

Door Types

	DO1	915mm x 2134mm Flush w/ Blk Frame
	DO2	813mm x 2134mm Flush w/ Blk Frame
	DO3	762mm x 2000mm Toilet Cubicle Door
	DO4	915mm x 2134mm Glass w/ Blk Frame
	DO5	762mm x 2134mm Glass w/ Blk Frame

Window Types

	W01	815mm x 2850mm Frosted Glass w/ Blk Frame
	W02	815mm x 2210mm Glass w/ Blk Frame

Abbreviations

BLK	Black	SA	Sanitary
DO	Door	SS	Stainless Steel
EQ	Equipment	WO	Window
FI	Fixture	WT	Wall Type
FU	Furniture	WI	With

Tag Legend

FU01 - 2x Medium Locker by Elite Office Furniture
FU02 - Chair by Coalesse 'Joel'
FU03 - Chair by Coalesse 'Sidewalk'
FU04 - 2 Seater Lounge by by Coalesse 'Sidewalk'
FU05 - Coffee table by Metro 'Topo'
FU06 - Coffee table by Temple and Webster
FU07 - Office Chair by Coalesse 'Bindu'
FU08 - Reception Desk by Elite Office Furniture 'Casnan Premier Sorrento Reception Counter'
FU09 - Office Desk by Modern Furniture 'Aftan Executive Desk'
EQ01 - Drinking Fountain by Ffitnes 'FCC-107-14-HL-VP'
EQ02 - Treadmill by Nordic Track 'Sport 50'
EQ03 - Exercise bike by Nordic Track 'S10 Studio Bike'
EQ04 - Leg press by Aussie Fitness 'Gym King HS'
EQ05 - Gym Bench by Aussie Fitness 'Gym King Flat bench'
EQ06 - Squat Rack by Aussie Fitness 'Gym King Commercial Smith Machine'
EQ07 - Power Rack by Aussie Fitness 'Gym King Commercial Power Rack'
EQ08 - Dumbel Rack by Commercial Fitness Equipment 'Titanium USA Monster Series'
EQ09 - Weight Rack by Sumo Strenght 'barbarian Rack Package'
EQ10 - Sauna Panel by Jacuzzi Clearlight Saunas 'Custom Kit'
SA01 - Basin by Temple and Webster 'Tulip Wall Hung Basin'
SA02 - Toilet by Temple and Webster 'White Minna Rimless BTW'
SA03 - Shower Head by Temple and Webster '2 Piece Square Shower Head'
SA04 - Drain by Temple and Webster '11x11 Square Shower Grate Floor Drain'
SA08 - Disable toilet sign by Keeler Hardware 'AS1428 Compliant Toilet Sign SILVER Unisex Disabled'
SA10 - Bathroom mirror / dryer / soap by Bradley Australia 'Bradley behind mirror foam soap and hand dryer'
SA11 - Toilet Roll Holder by Estlio 'Chrome Beta Single roll Holder'
SA12 - Shower Mixer by The Blue Space 'Phoenix Vivid Slimline Shower/Wall Mixer'
SA13 - Toilet flush button by Icon Bathware 'Invisi Series II'
FI04 - Sled Track by Raw Fitness Equipment 'Custom Gym Sled'
LI01 - Light up Mirror by ATS Tiles and Bathroom 'Retti Rectangular LED Mirror'
LI02 - LED Logo by Big Banner
MA01 - Polished Concrete
MA02 - GYM MAT
MA03 - Custome Sled turf by Raw Fitness Equipment 'Custom Gym Sled'
MA04 - Brick Lane Tiles by National Tiles
MA05 - Paint finish by Porters Paints 'Mountain Ash'
MA06 - Paint finish by Porters Paints 'Custom Frontline Green'
MA07 - Tiles by National Tiles 'Zellige White Matt Tile'
MA08 - Paint finish by Porters Paints 'Aniseed'
MA09 - Cedar Wood

REVISIONS

No	Date	
01	27.10.21	

Description
**PRESENTATION DRAWINGS
NOT FOR CONSTRUCTION**

Ver. App'd
XX App'd

Do not scale drawings. Use figured dimensions only. Check and verify levels and dimensions on site prior to commencement of any work, the preparation of drawings or the fabrication of components.
This drawing is copyright and can not be reproduced without written consent.

Client
Moey Faour

"LEADING FROM THE FRONT"

True North

Billy Blue College of Design
46-52 Mountain Street, Ultimo, NSW 2007, Australia
+61 (0)2 9999 9999

LAUREATE INTERNATIONAL UNIVERSITIES

Project
Frontline Fitness

630 Canterbury Road,
Belmore, NSW. 2192

Project number
01


Drawing Title
Infrared Sauna Elevation 4

Drawing Status
**PRESENTATION
DRAWINGS
NOT FOR
CONSTRUCTION**


Scale	Drawing No	Issue
1 : 10	D16	01

Date 27.10.21


Drawn by MB

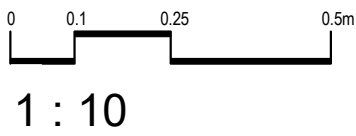

6/12/2021 3:53:30 AM

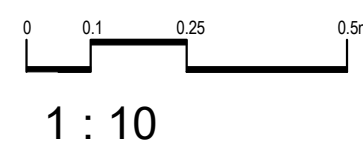


H2 treated bottom plate

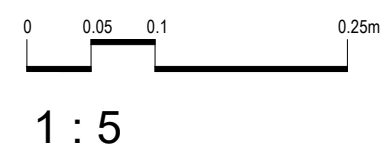


Shower pan w/ tile, sloped to floor drain

6/12/2021 3:53:39 AM

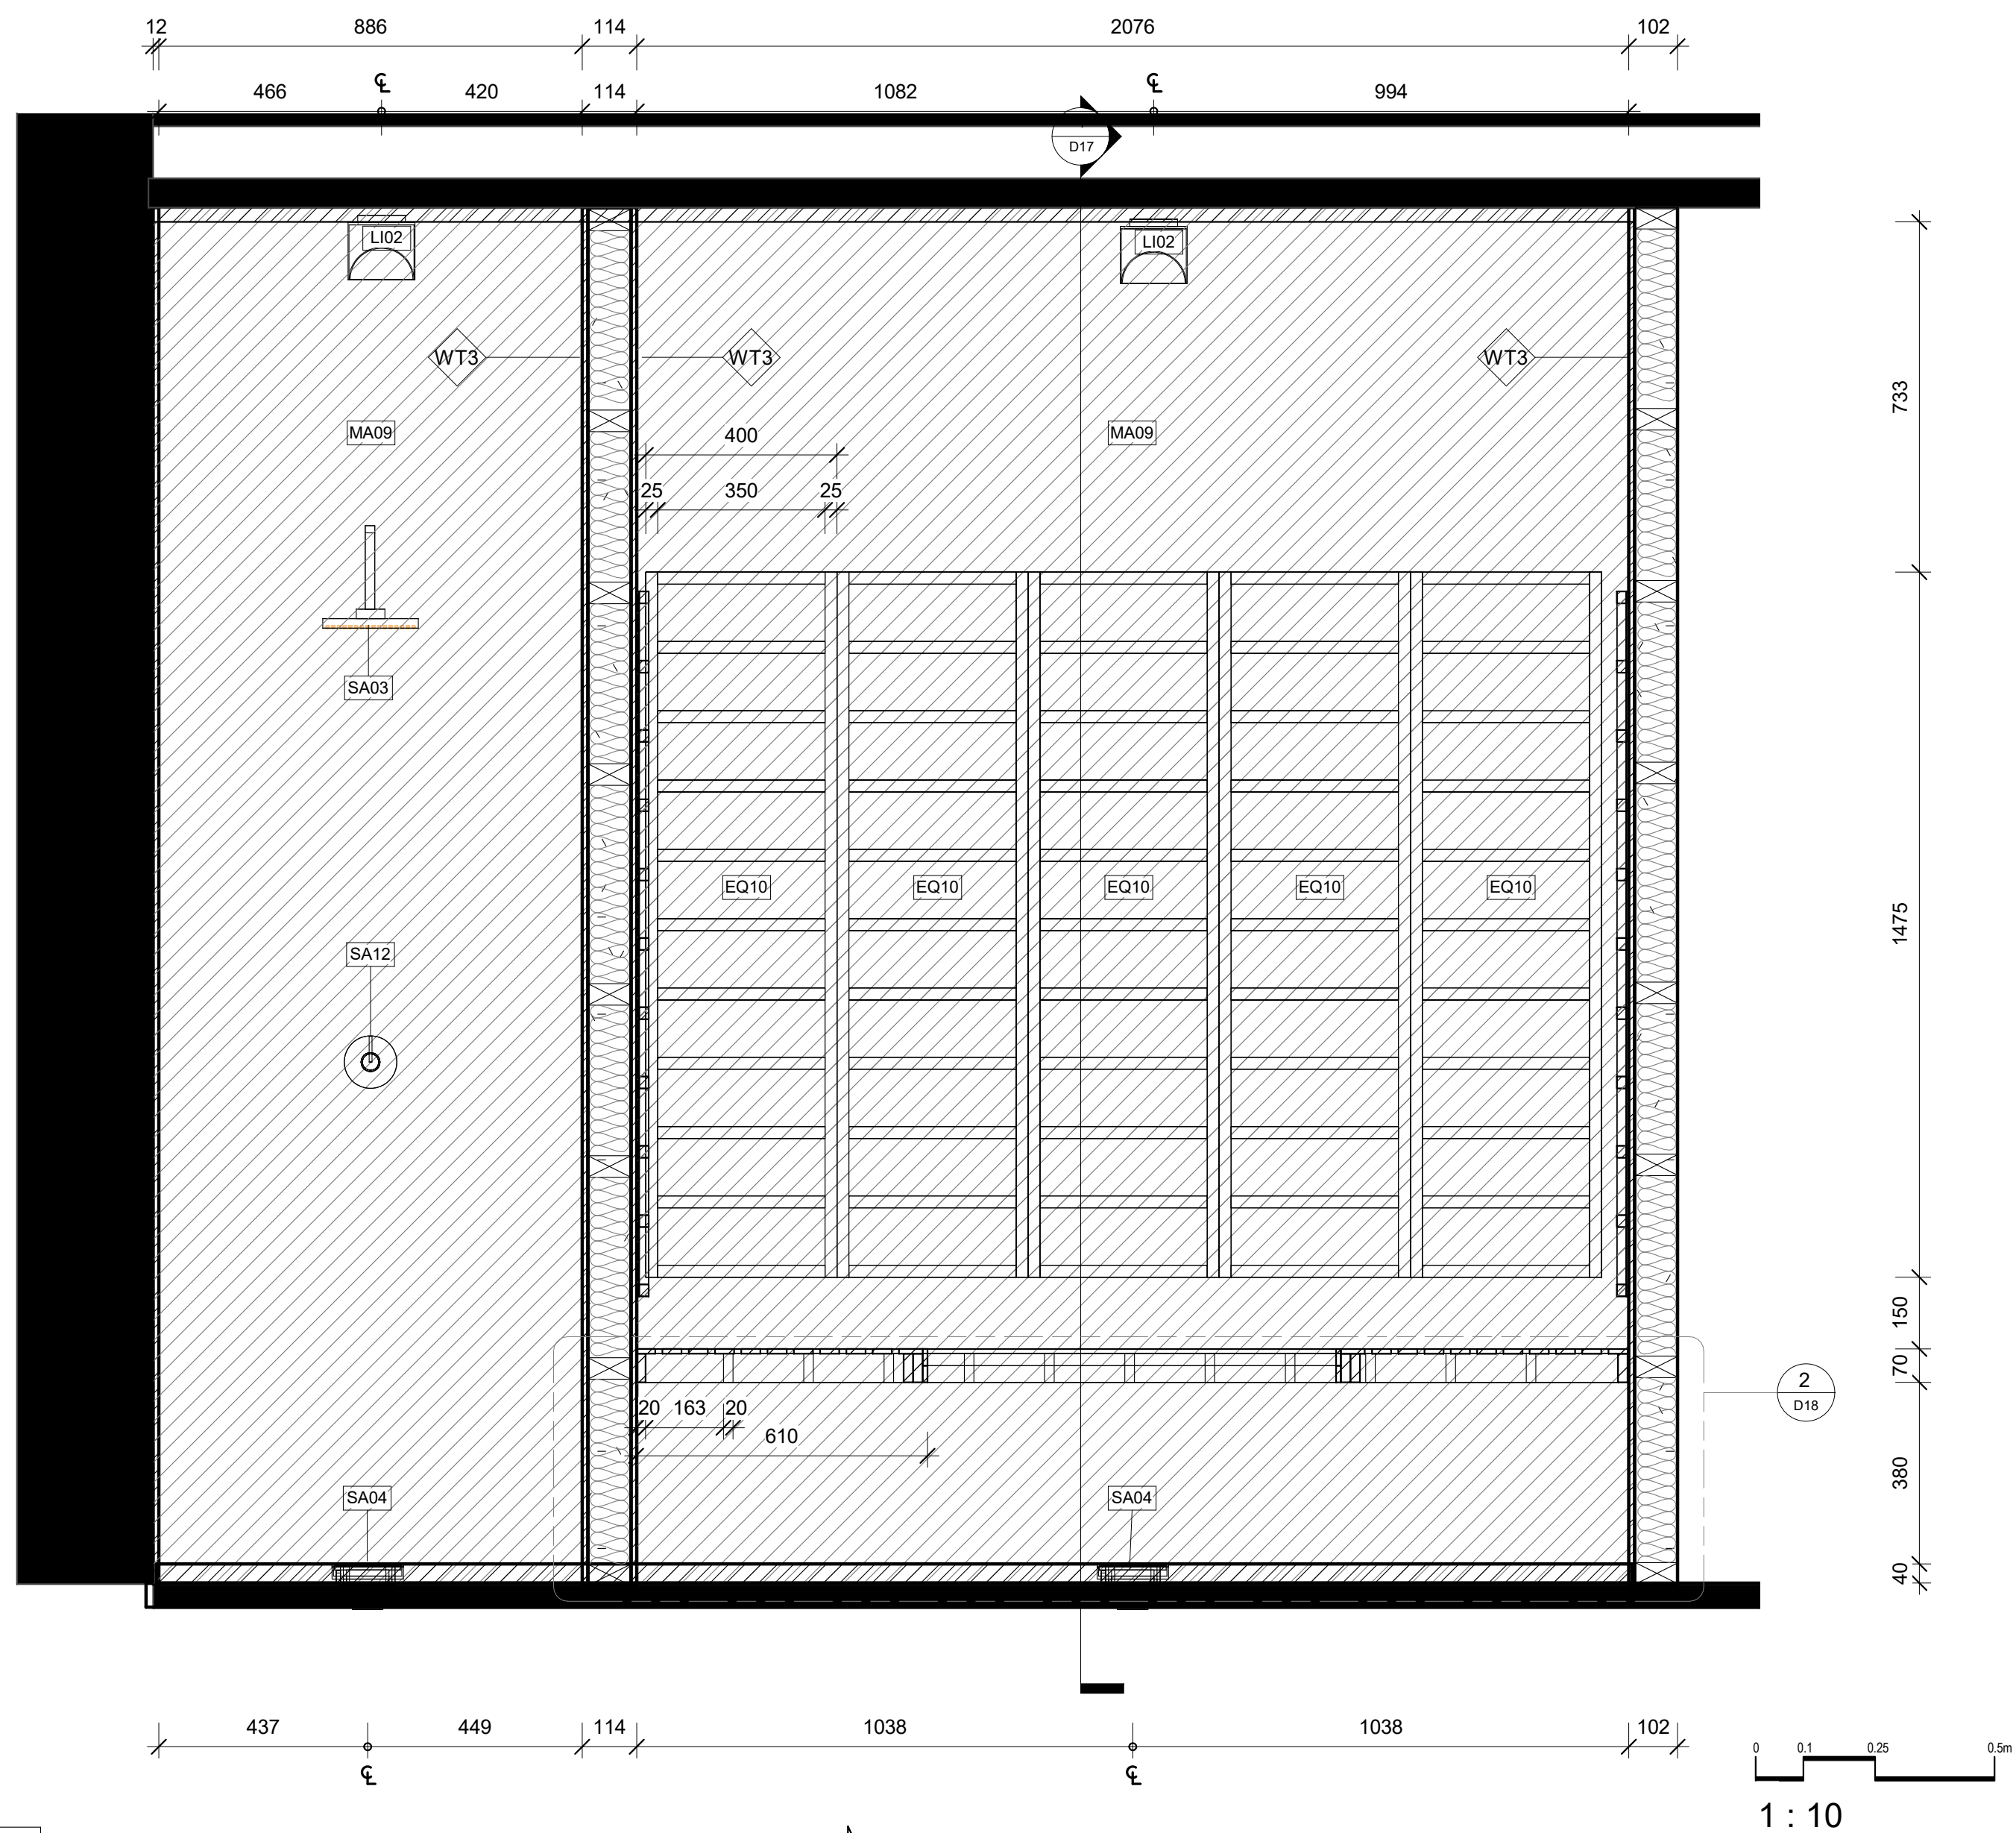

60mm(W) x 12mm(T)
Aluminum bracket
attached to studs to create
support

3 x 6mm(W) screws to
both the bottom half and
top half of the bracket to
each stud along the wall

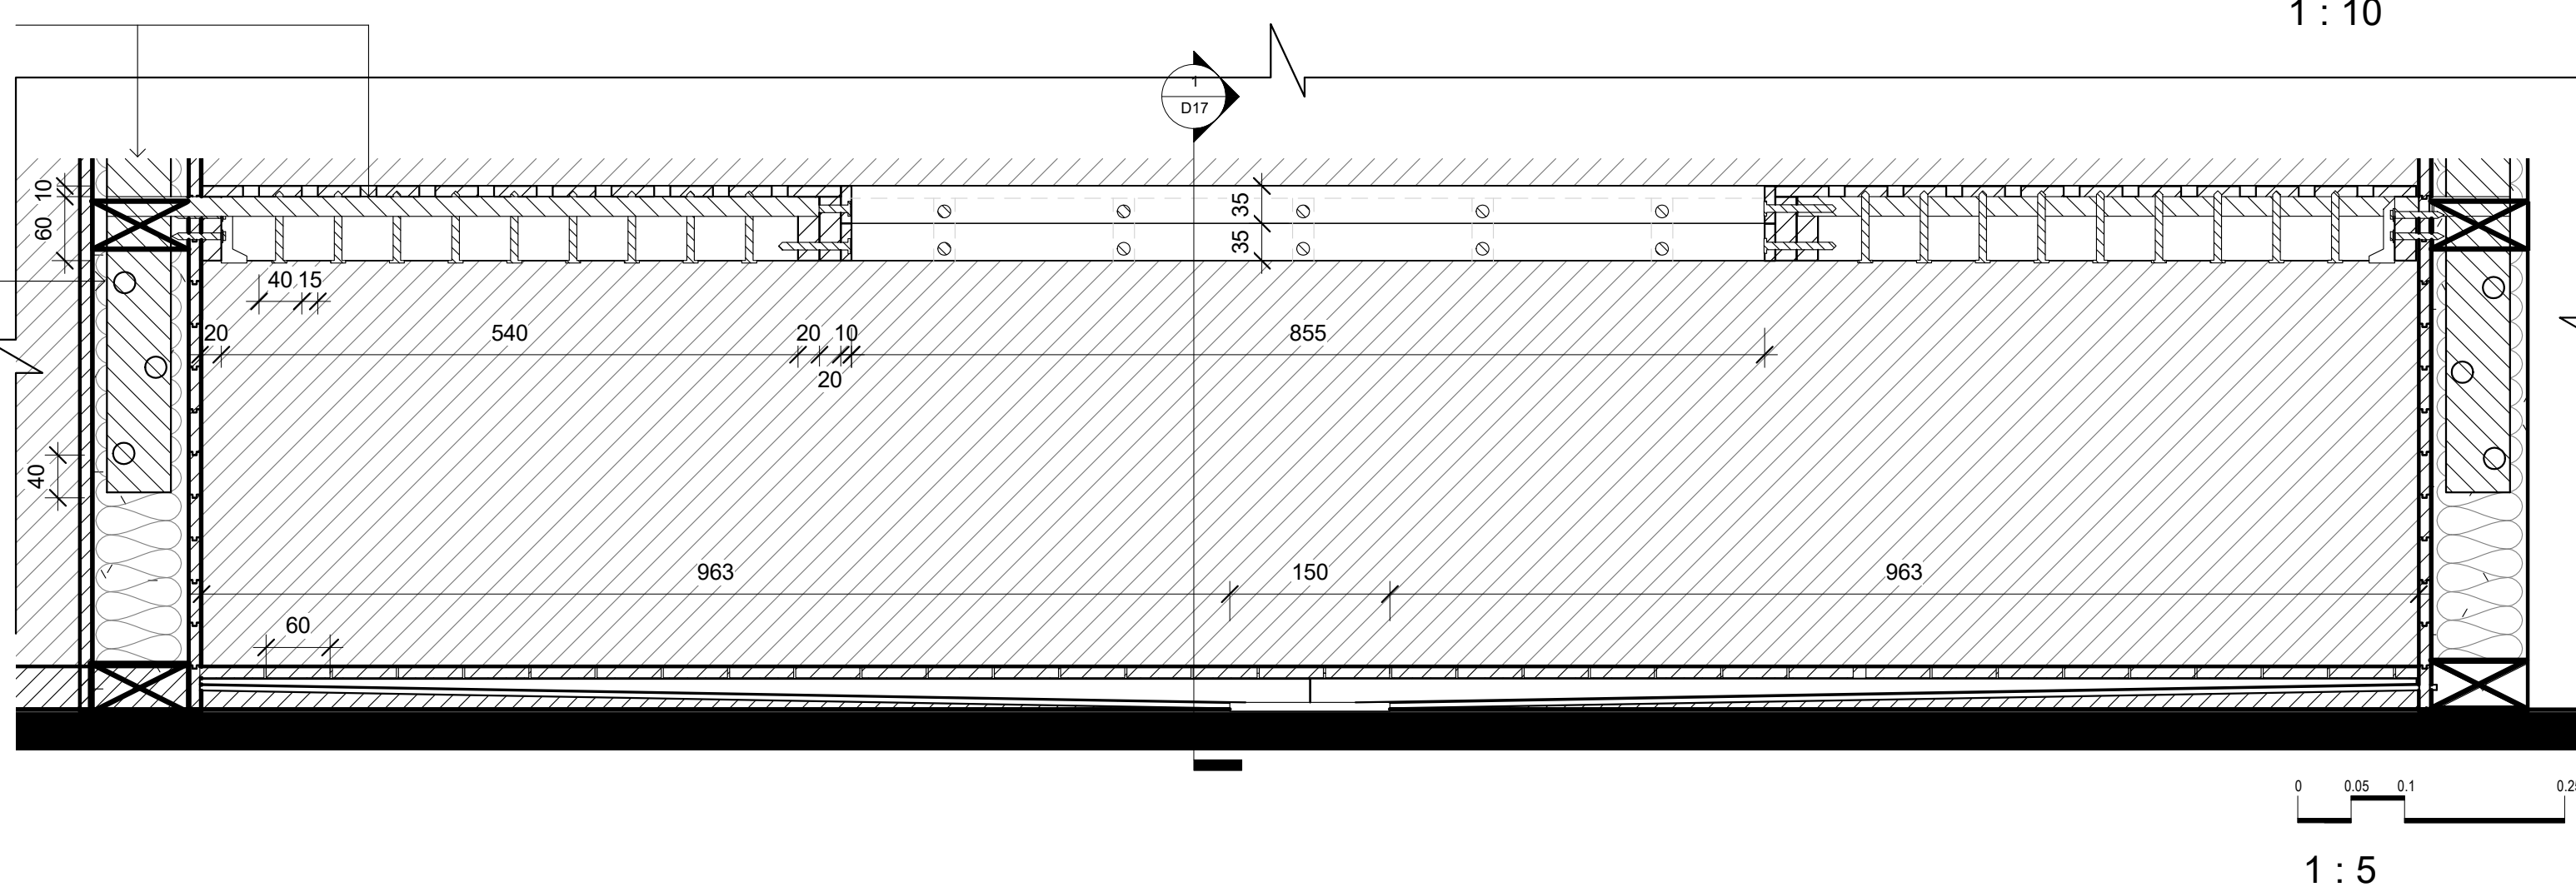


LEGEND	REVISIONS
Cut Material Glass Cedar Concrete Gym Mat Tiles Plaster Board Existing Structure Wall Types WT1 Timber stud wall 90mm x 45mm w/ 9mm Plaster board and Mountain Ash - Low sheen Paint finish WT2 Custom Frontline Green - Low sheen Paint finish (1200mm H) WT3 Timber stud wall 90mm x 45mm w/ 12mm timber cedar top WT4 24mm Melamine (2400mm H) WT5 Timber stud wall 90mm x 45mm w/ 2mm glue + 6mm Bricklane tile WT6 Timber stud wall 90mm x 45mm w/ 2mm glue + 6mm square tile Door Types DO1 915mm x 2134mm Flush w/ Blk Frame DO2 813mm x 2134mm Flush w/ Blk Frame DO3 762mm x 2000mm Toilet Cubicle Door DO4 915mm x 2134mm Glass w/ Blk Frame DO5 762mm x 2134mm Glass w/ Blk Frame Window Types W01 815mm x 2850mm Frosted Glass w/ Blk Frame W02 815mm x 2210mm Glass w/ Blk Frame Abbreviations BLK Black D0 Door EQ Equipment FI Furniture FU Furniture SA Sanitary SS Stainless Steel WO Window WT Wall Type WI With Tag Legend FU01 - 2x Medium Locker by Elite Office Furniture FU02 - Chair by Colesse 'Joel' FU03 - Chair by Colesse 'Sidewalk' FU04 - 2 Seater Lounge by by Colesse 'Sidewalk' FU05 - Coffee table by Metro 'Tapa' FU06 - Coffee table by Temple and Webster FU07 - Office Chair by Colesse 'Bindu' FU08 - Reception Desk by Elite Office Furniture 'Casnan Premier Sorento Reception Counter' FU09 - Office Desk by Modern Furniture 'Atan Executive Desk' EQ01 - Drinking Fountain by Filtrine 'FCC-107-14-HL-VP' EQ02 - Treadmill by Nordic Track 'Sport 50' EQ03 - Exercise bike by Nordic Track 'S10 Studio Bike' EQ04 - Leg press by Aussie Fitness 'Gym King HS' EQ05 - Gym Bench by Aussie Fitness 'Gym King Flat bench' EQ06 - Squat Rack by Aussie Fitness 'Gym King Commercial Smith Machine' EQ07 - Power Rack by Aussie Fitness 'Gym King Commercial Power Rack' EQ08 - Dumbbell Rack by Commercial Fitness Equipment 'Titanium USA Monster Series' EQ09 - Weight Rack by Sumo Strength 'barbarian Rack Package' EQ10 - Sauna Panel by Jacuzzi Clearlight Saunas 'Custom Kit' SA01 - Basin by Temple and Webster 'Tulp Wall Hung Basin' SA02 - Toilet by Temple and Webster 'White Minna Rimless BTW' SA03 - Shower Head by Temple and Webster '2 Piece Square Shower Head' SA04 - Drain by Temple and Webster '11x11 Square Shower Grate Floor Drain' SA08 - Disable toilet sign by Keeler Hardware 'AS1428 Compliant Toilet Sign SILVER Unisex Disabled' SA10 - Bathroom mirror / dryer / soap by Bradley Australia 'bradley behind mirror foam soap and hand dryer' SA11 - Toilet Roll Holder by Estile 'Chrome Beta Single roll Holder' SA12 - Shower Mixer by The Blue Space 'Phoenix Vivid Slimline Shower/Wall Mixer' SA13 - Toilet flush button by Icon Bathware 'Invisi Series II' F104 - Sled Rack by Raw Fitness Equipment 'Custom Gym Sled' LI01 - Light up Mirror by ATS Tiles and Bathroom 'Retti Rectangular LED Mirror' LI02 - LED Logo by Big Banner MA01 - Polished Concrete MA02 - GYM MAT MA03 - Custome Sled turf by Raw Fitness Equipment 'Custom Gym Sled' MA04 - Brick Lane Tiles by National Tiles MA05 - Paint finish by Porters Paints 'Mountain Ash' MA06 - Paint finish by Porters Paints 'Custome Frontline Green' MA07 - Tiles by National Tiles 'Zellige White Matt Tile' MA08 - Paint finish by Porters Paints 'Anisest' MA09 - Cedar Wood No Date 01 27.10.21 Description PRESENTATION DRAWINGS NOT FOR CONSTRUCTION Ver. App'd XX App'd Do not scale drawings. Use figured dimensions only. Check and verify levels and dimensions on site prior to commencement of any work, the preparation of drawings or the fabrication of components. This drawing is copyright and can not be reproduced without written consent. Client Moey Faour Frontline Fitness "LEADING FROM THE FRONT" True North Billy Blue College of Design 46-52 Mountain Street, Ultimo, NSW 2007, Australia +61 (0)2 9999 9999 BILLY BLUE COLLEGE OF DESIGN TORRENS UNIVERSITY AUSTRALIA LAUREATE INTERNATIONAL UNIVERSITIES Project Frontline Fitness 630 Canterbury Road, Belmore, NSW. 2192 Project number 01 Drawing Title Infrared Sauna Section Detail 2 Drawing Status PRESENTATION DRAWINGS NOT FOR CONSTRUCTION Scale As Indicated Drawing No D18 Issue 01 Date 27.10.21 Drawn by MB	

6/12/2021 3:53:45 AM



LEGEND

Cut Material

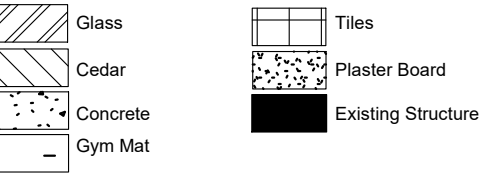

Wall Types

- WT1 - Timber stud wall 90mm x 45mm w/ 9mm Plaster board and 'Mountain Ash - Low sheen' Paint finish
- WT2 - 'Custom Frontline Green - Low sheen' Paint finish (1200mm H)
- WT3 - Timber stud wall 90mm x 45mm w/ 12mm timber cedar top
- WT4 - 24mm Melamine (2400mm H)
- WT5 - Timber stud wall 90mm x 45mm w/ 2mm glue + 6mm Bricklane tile
- WT6 - Timber stud wall 90mm x 45mm w/ 2mm glue + 6mm square tile

Door Types

- DO1 - 915mm x 2134mm Flush w/ Blk Frame
- DO2 - 813mm x 2134mm Flush w/ Blk Frame
- DO3 - 762mm x 2000mm Toilet Cubicle Door
- DO4 - 915mm x 2134mm Glass w/ Blk Frame
- DO5 - 762mm x 2134mm Glass w/ Blk Frame

Window Types

- W01 - 815mm x 2850mm Frosted Glass w/ Blk Frame
- W02 - 815mm x 2210mm Glass w/ Blk Frame

Abbreviations

- | | | | |
|-----|-----------|----|-----------------|
| BLK | Black | SA | Sanitary |
| D0 | Door | SS | Stainless Steel |
| EQ | Equipment | W0 | Window |
| FI | Fixture | WT | Wall Type |
| FU | Furniture | W/ | With |

Tag Legend

- FU01 - 2x Medium Locker by Elite Office Furniture
FU02 - Chair by Coalesse 'Joel'
FU03 - Chair by Coalesse 'Sidewalk'
FU04 - 2 Seater Lounge by by Coalesse 'Sidewalk'
FU05 - Coffee table by Metro 'topo'
FU06 - Coffee table by Temple and Webster
FU07 - Office Chair by Coalesse 'Bridi'
FU08 - Reception Desk by Elite Office Furniture 'Casnan Premier Sorrento Reception Counter'
FU09 - Office Desk by Modern Furniture 'Atlan Executive Desk'
EQ01 - Drinking Fountain by Filtrine 'FCC-107-14-HL-VP'
EQ02 - Treadmill by Nordic Track 'Sport 50'
EQ03 - Exercise bike by Nordic Track 'S10 Studio Bike'
EQ04 - Leg press by Aussie Fitness 'Gym King HS'
EQ05 - Gym Bench by Aussie Fitness 'Gym King Flat bench'
EQ06 - Squat Rack by Aussie Fitness 'Gym King Commercial Smith Machine'
EQ07 - Power Rack by Aussie Fitness 'Gym King Commercial Power Rack'
EQ08 - Dumbbell Rack by Commercial Fitness Equipment 'Titanium USA Monster Series'
EQ09 - Weight Rack by Suno Strenght 'barbarian Rack Package'
EQ10 - Sauna Panel by Jacuzzi Clearlight Saunas 'Custom Kit'
SA01 - Basin by Temple and Webster 'Tulip Wall Hung Basin'
SA02 - Toilet by Temple and Webster 'White Minna Rimless BTW'
SA03 - Shower Head by Temple and Webster '2 Piece Square Shower Head'
SA04 - Drain by Temple and Webster '11x11 Square Shower Grate Floor Drain'
SA08 - Disable toilet sign by Keeleer Hardware 'AS1428 Compliant Toilet Sign SILVER Unisex Disabled'
SA10 - Bathroom mirror / dryer / soap by Bradley Australia 'Bradley behind mirror foam soap and hand dryer'
SA11 - Toilet Roll Holder by Estilo 'Chrome Bela Single roll Holder'
SA12 - Shower Mixer by The Blue Space 'Phoenix Vivid Slimline Shower/Wall Mixer'
SA13 - Toilet flush button by Icon Bathware 'Invisi Series II'
FI04 - Sled Track by Raw Fitness Equipment 'Custom Gym Sled'
LU01 - Light up Mirror by ATS Tiles and Bathroom 'Retli Rectangular LED Mirror'
LU02 - LED Logo by Big Banner
MA01 - Polished Concrete
MA02 - GYM MAT
MA03 - Custome Sled turf by Raw Fitness Equipment 'Custom Gym Sled'
MA04 - Brick Lane Tiles by National Tiles
MA05 - Paint finish by Porters Paints 'Mountain Ash'
MA06 - Paint finish by Porters Paints 'Custom Frontline Green'
MA07 - Tiles by National Tiles 'Zellige White Matt Tile'
MA08 - Paint finish by Porters Paints 'Aristeed'
MA09 - Cedar Wood

REVISIONS

No Date
01 27.10.21

Description
PRESENTATION DRAWINGS
NOT FOR CONSTRUCTION

Ver. App'd
XX App'd

Do not scale drawings. Use figured dimensions only. Check and verify levels and dimensions on site prior to commencement of any work, the preparation of drawings or the fabrication of components.
This drawing is copyright and can not be reproduced without written consent.

Client

Moey Faour



True North

True North

Billy Blue College of Design
46-52 Mountain Street, Ultimo, NSW 2007, Australia
+61 (0)2 9999 9999



Project

Frontline Fitness

630 Canterbury Road,
Belmore, NSW. 2192

Project number

01

Drawing Title

Infrared Sauna Isometric
View Detail

Drawing Status


PRESENTATION
DRAWINGS
NOT FOR
CONSTRUCTION


Scale Drawing No Issue
N/A D19 01

Date 27.10.21

Drawn by MB


6/12/2021 3:54:05 AM

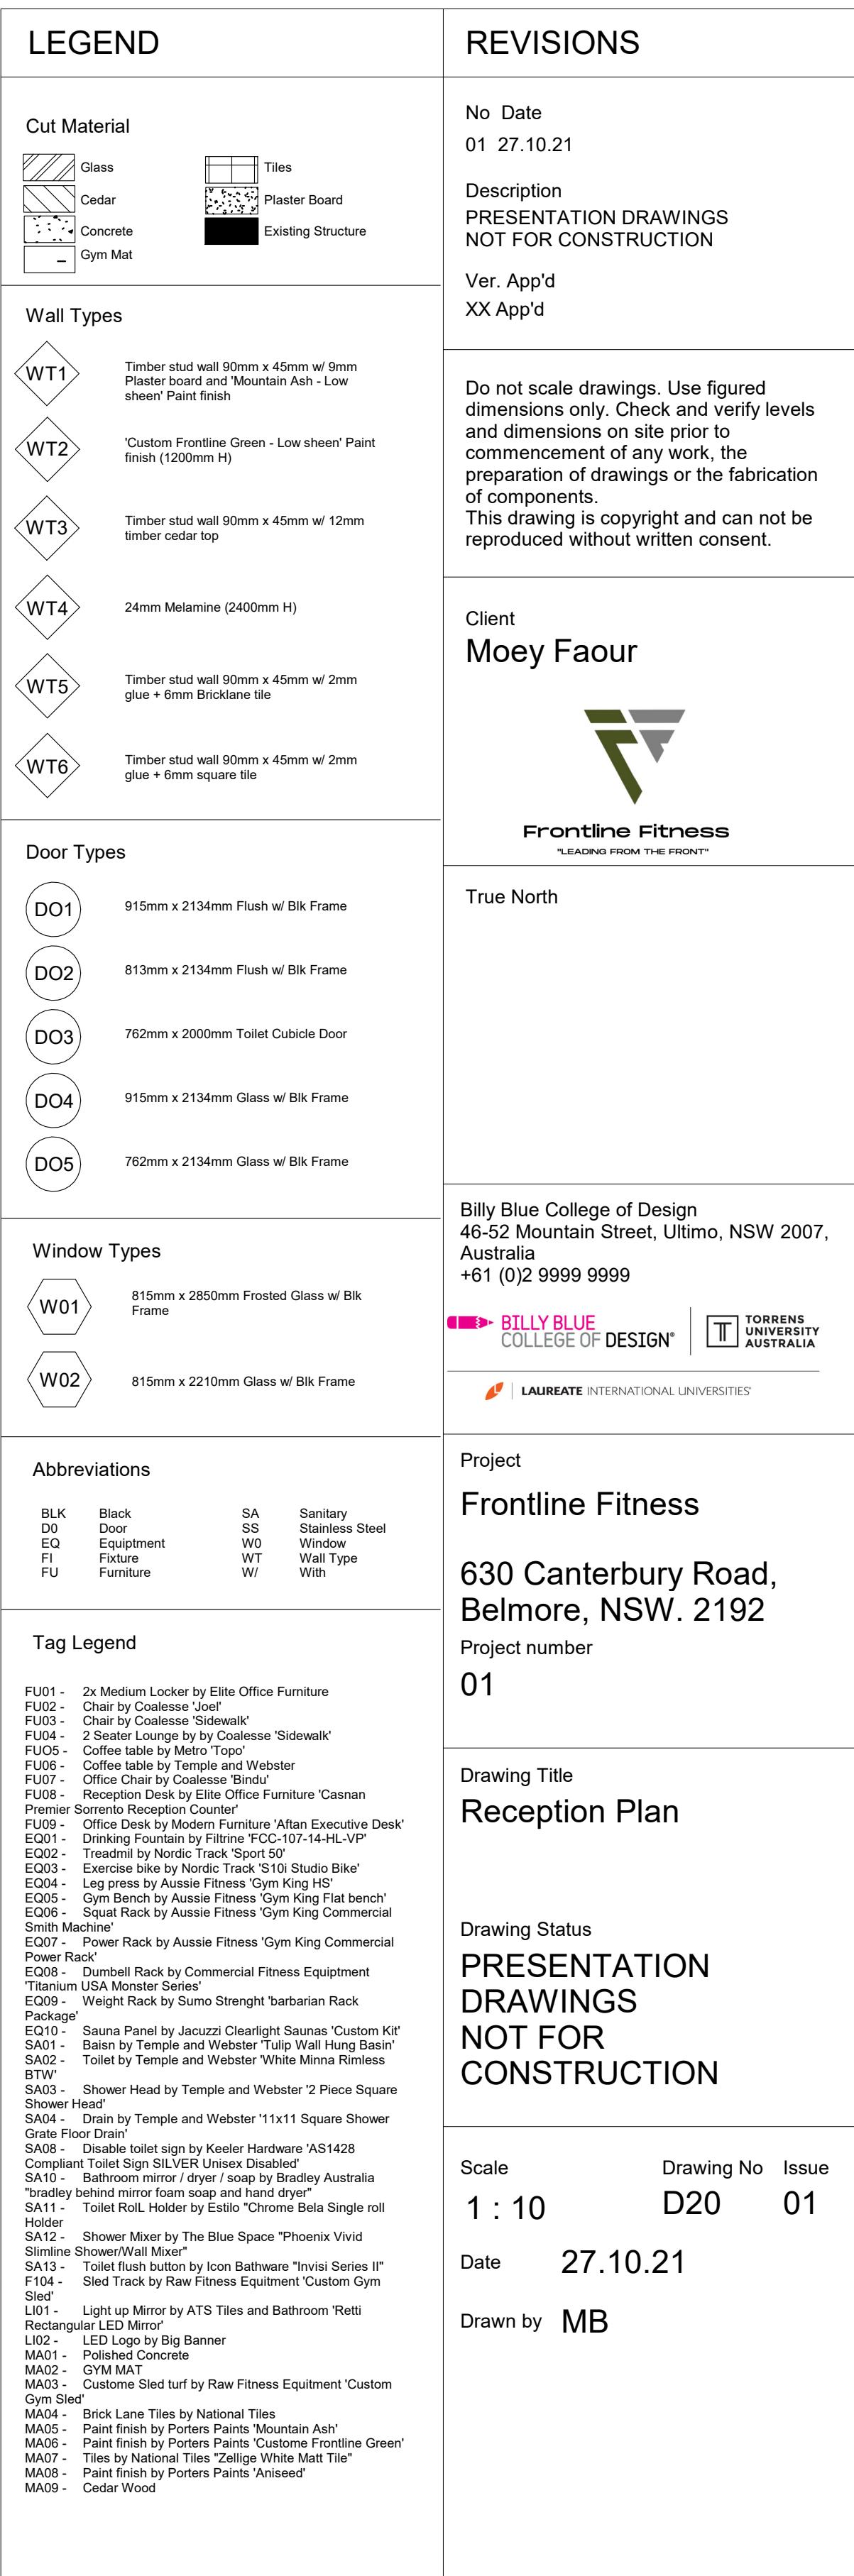

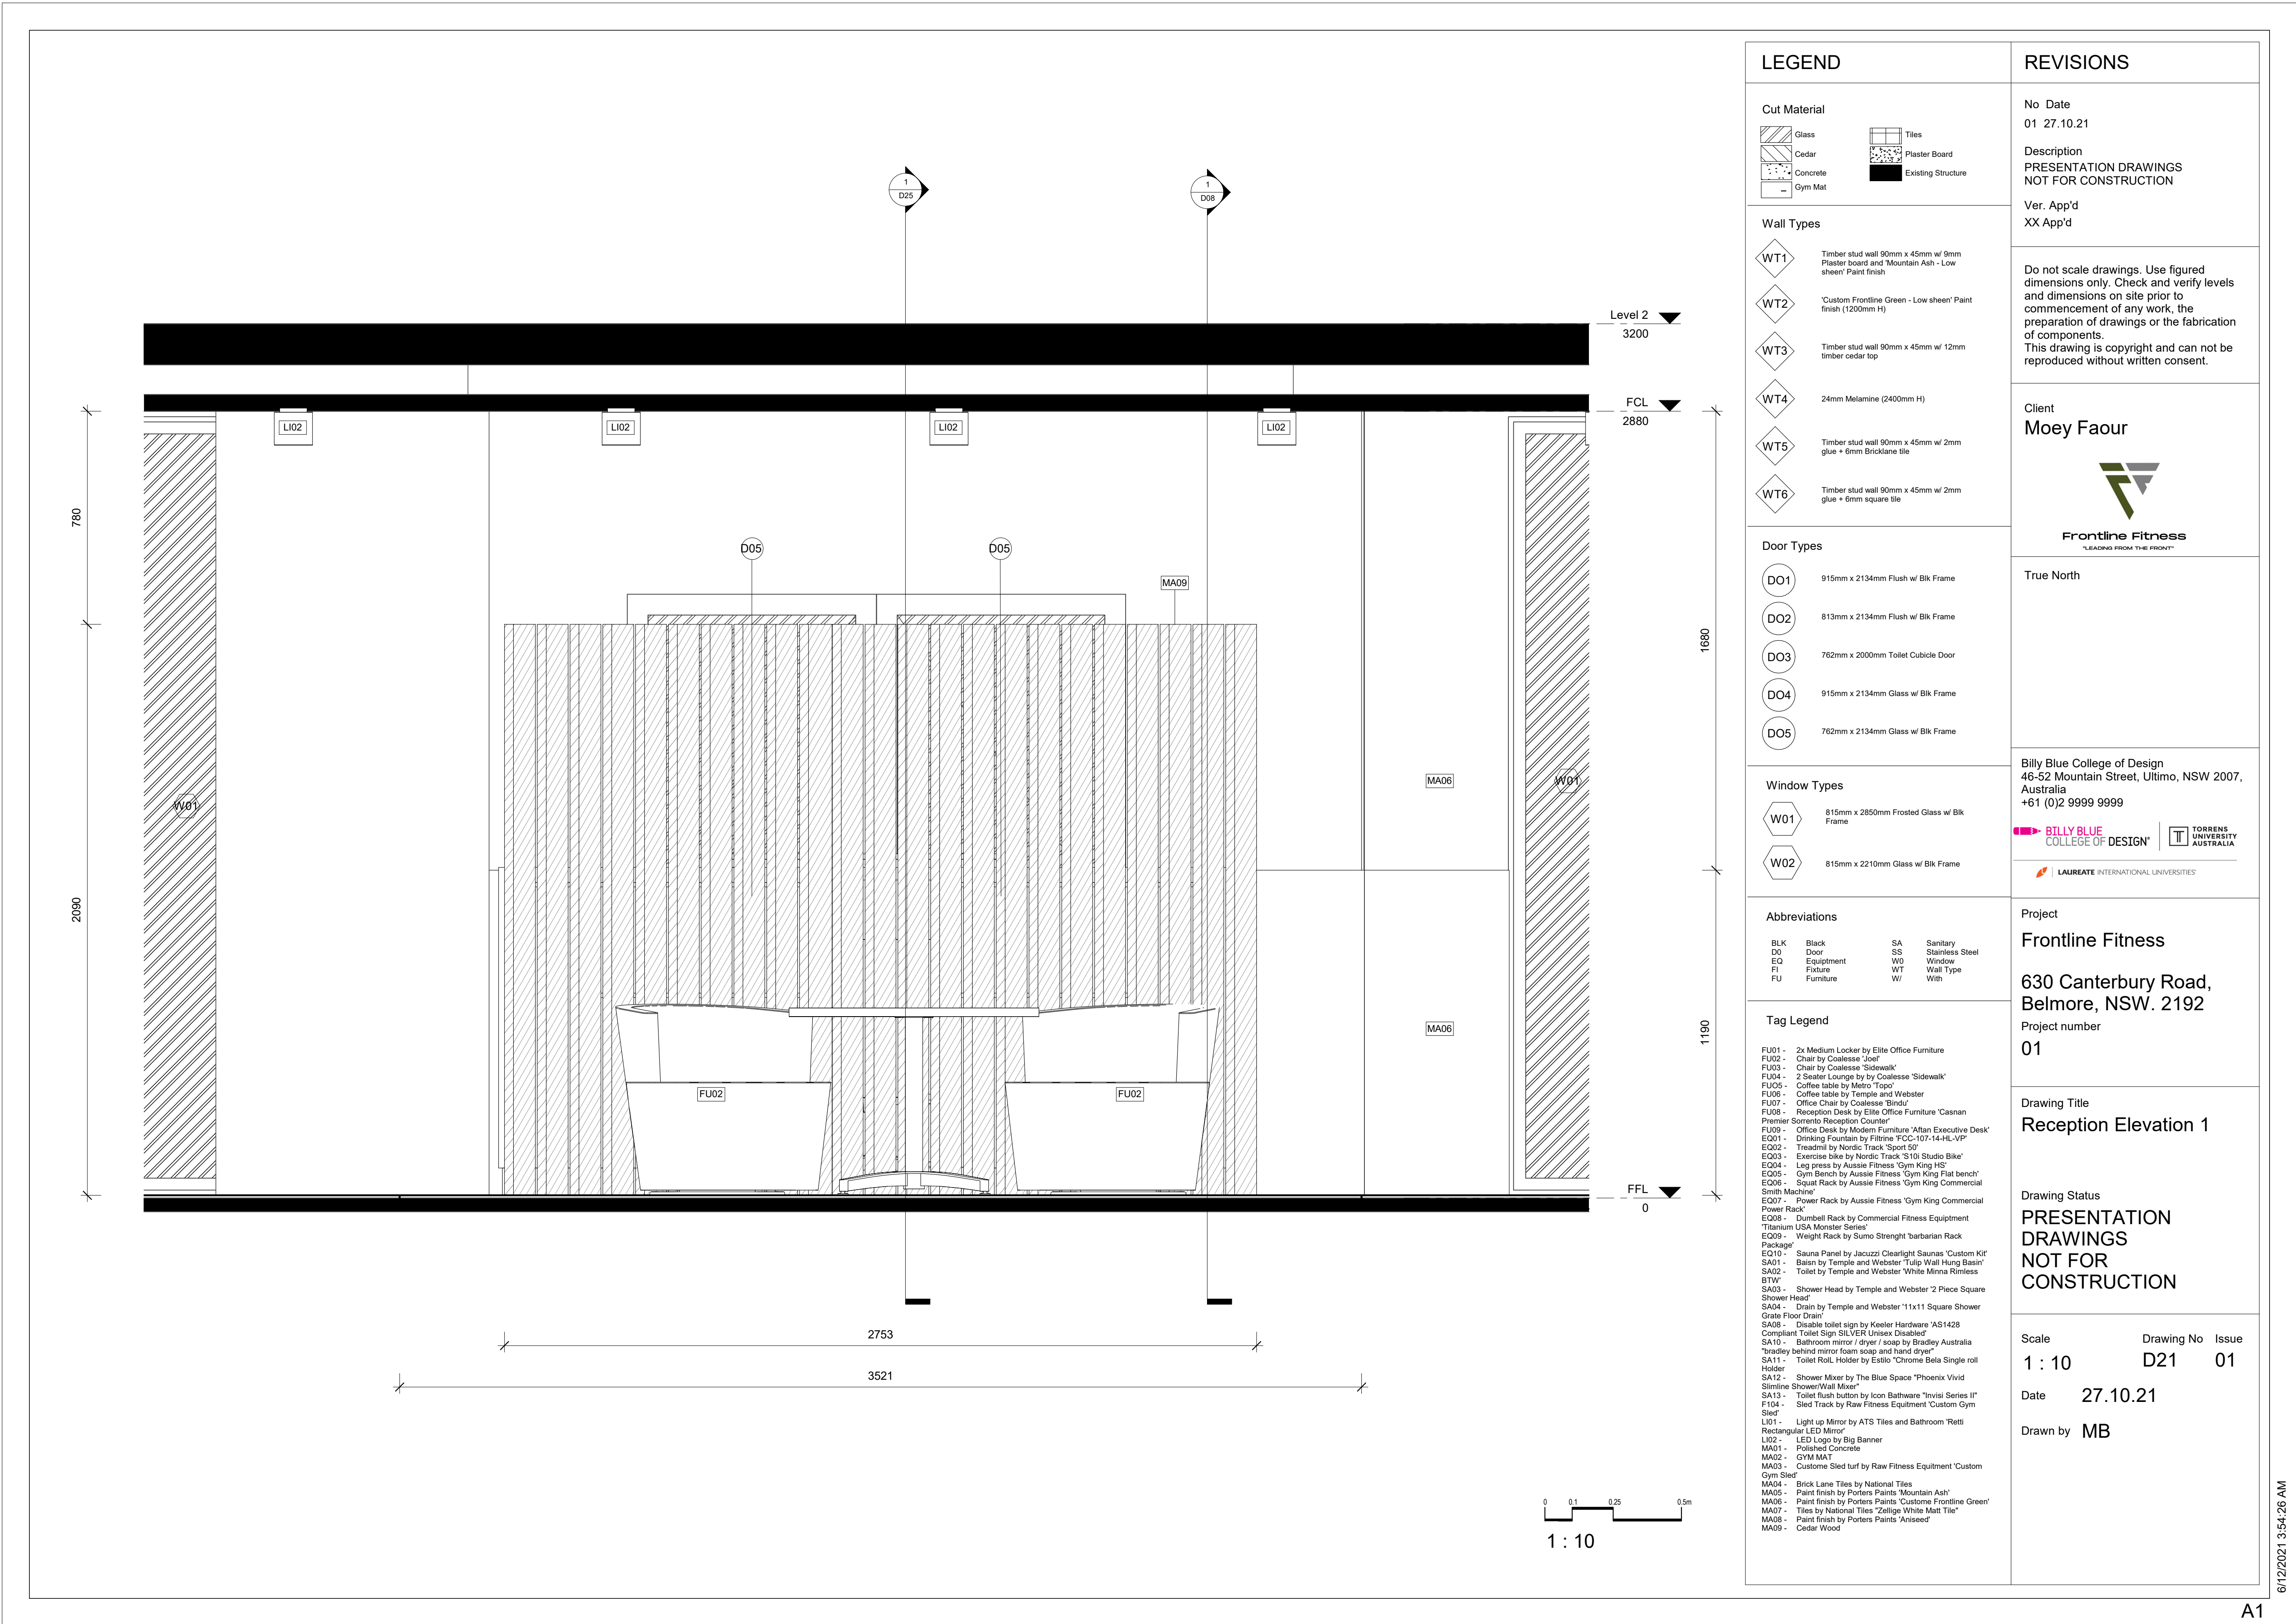


LEGEND Cut Material Glass Cedar Concrete Gym Mat Tiles Plaster Board Existing Structure Wall Types WT1 Timber stud wall 90mm x 45mm w/ 9mm Plaster board and 'Mountain Ash - Low sheen' Paint finish WT2 'Custom Frontline Green - Low sheen' Paint finish (1200mm H) WT3 Timber stud wall 90mm x 45mm w/ 12mm timber cedar top WT4 24mm Melamine (2400mm H) WT5 Timber stud wall 90mm x 45mm w/ 2mm glue + 6mm Bricklane tile WT6 Timber stud wall 90mm x 45mm w/ 2mm glue + 6mm square tile Door Types D01 915mm x 2134mm Flush w/ Blk Frame D02 813mm x 2134mm Flush w/ Blk Frame D03 762mm x 2000mm Toilet Cubicle Door D04 915mm x 2134mm Glass w/ Blk Frame D05 762mm x 2134mm Glass w/ Blk Frame Window Types W01 815mm x 2850mm Frosted Glass w/ Blk Frame W02 815mm x 2210mm Glass w/ Blk Frame Abbreviations BLK Black D0 Door EQ Equipment FI Fixture FU Furniture SA SS WD Window WT Wall Type WI With Tag Legend FU01 - 2x Medium Locker by Elite Office Furniture FU02 - Chair by Coalesse 'Joel' FU03 - Chair by Coalesse 'Sidewalk' FU04 - 2 Seater Lounge by by Coalesse 'Sidewalk' FU05 - Coffee table by Metro 'Togo' FU06 - Coffee table by Temple and Webster FU07 - Office Chair by Coalesse 'Sindy' FU08 - Reception Desk by Elite Office Furniture 'Casnan Premier Sorrento Reception Counter' FU09 - Office Desk by Modern Furniture 'Aftan Executive Desk' EQ01 - Drinking Fountain by Filtrine 'FCC-107-14-HL-VIP' EQ02 - Treadmill by Nordic Track 'Sport 50' EQ03 - Exercise bike by Nordic Track 'S10i Studio Bike' EQ04 - Leg press by Aussie Fitness 'Gym King HS' EQ05 - Gym Bench by Aussie Fitness 'Gym King Flat bench' EQ06 - Squat Rack by Aussie Fitness 'Gym King Commercial Smith Machine' EQ07 - Power Rack by Aussie Fitness 'Gym King Commercial Power Rack' EQ08 - Dumbbell Rack by Commercial Fitness Equipment 'Titanium USA Monster Series' EQ09 - Weight Rack by Sumo Strength 'barbarian Rack Package' EQ10 - Sauna Panel by Jacuzzi Clearlight Saunas 'Custom Kit' SA01 - Basin by Temple and Webster 'Tulip Wall Hung Basin' SA02 - Toilet by Temple and Webster 'White Minna Rimless BTW' SA03 - Shower Head by Temple and Webster '2 Piece Square Shower Head' SA04 - Drain by Temple and Webster '11x11 Square Shower Grate Floor Drain' SA05 - Disable toilet sign by Keeler Hardware 'AS1428 Complaint Toilet Sign SILVER Unisex Disabled' SA10 - Bathroom mirror / dryer / soap by Bradley Australia 'brushy behind mirror foam soap and hand dryer' SA11 - Toilet Roll Holder by Estlio 'Chrome Bela Single roll Holder' SA12 - Shower Mixer by The Blue Space 'Phoenix Vivid Slimline Shower/Wall Mixer' SA13 - Toilet flush button by Icon Bathware 'Invisi Series IP' FI04 - Sled Track by Raw Fitness Equipment 'Custom Gym Sled' LI01 - Light up Mirror by ATS Tiles and Bathroom 'Retti Rectangular LED Mirror' LI02 - LED Logo by Big Banner MA01 - Polished Concrete MA02 - GYM MAT MA03 - Custom Sled turf by Raw Fitness Equipment 'Custom Gym Sled' MA04 - Brick Lane Tiles by National Tiles MA05 - Paint finish by Porters Paints 'Mountain Ash' MA06 - Paint finish by Porters Paints 'Custom Frontline Green' MA07 - Tiles by National Tiles 'Zellige White Matt Tile' MA08 - Paint finish by Porters Paints 'Aniseed' MA09 - Cedar Wood REVISIONS No Date 01 27.10.21 Description PRESENTATION DRAWINGS NOT FOR CONSTRUCTION Ver. App'd XX App'd Do not scale drawings. Use figured dimensions only. Check and verify levels and dimensions on site prior to commencement of any work, the preparation of drawings or the fabrication of components. This drawing is copyright and can not be reproduced without written consent. Client Moey Faour Frontline Fitness LEADING FROM THE FRONT True North Billy Blue College of Design 46-52 Mountain Street, Ultimo, NSW 2007, Australia +61 (0)2 9999 9999 BILLY BLUE COLLEGE OF DESIGN T TORRENS UNIVERSITY AUSTRALIA LAUREATE INTERNATIONAL UNIVERSITIES Project Frontline Fitness 630 Canterbury Road, Belmore, NSW. 2192 Project number 01 Drawing Title Reception Elevation 1 Drawing Status PRESENTATION DRAWINGS NOT FOR CONSTRUCTION Scale 1 : 10 Drawing No D21 Issue 01 Date 27.10.21 Drawn by MB

6/12/2021 3:54:26 AM

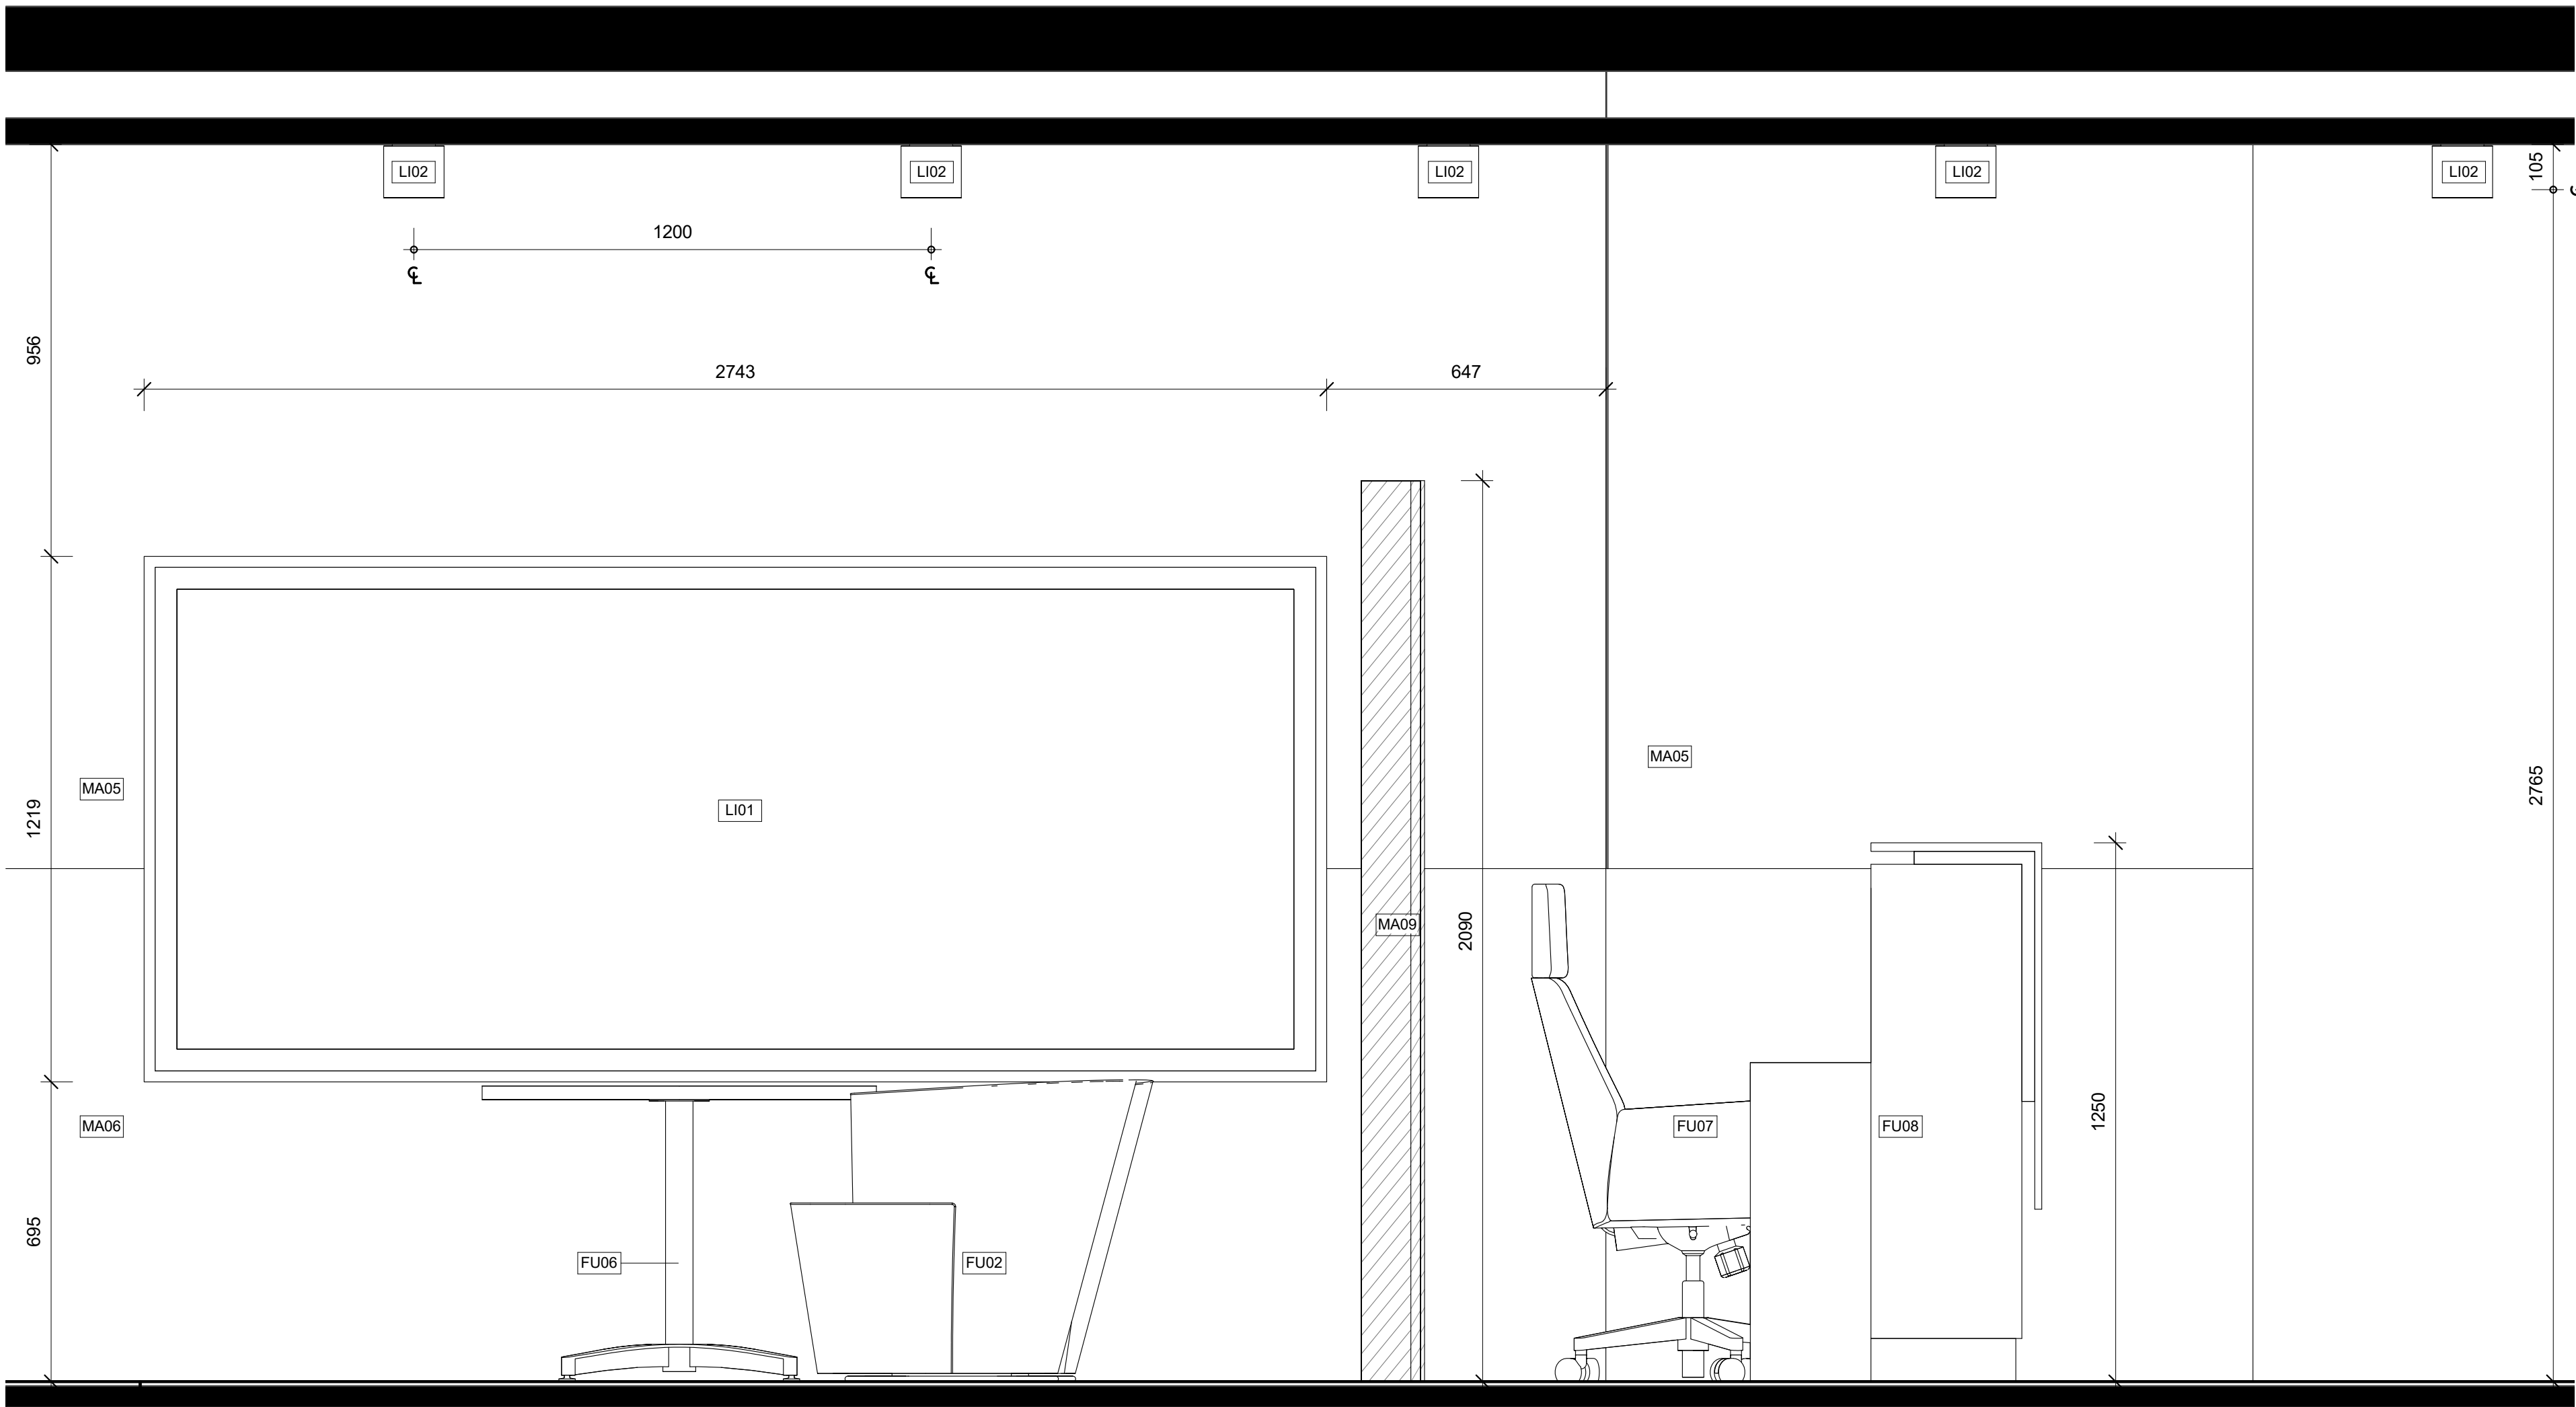

LEGEND

Cut Material

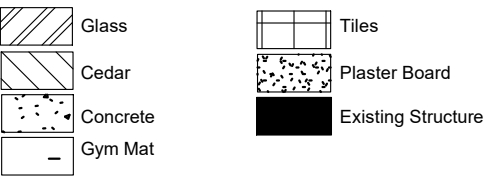

Wall Types

- WT1 - Timber stud wall 90mm x 45mm w/ 9mm Plaster board and 'Mountain Ash - Low sheen' Paint finish
- WT2 - 'Custom Frontline Green - Low sheen' Paint finish (1200mm H)
- WT3 - Timber stud wall 90mm x 45mm w/ 12mm timber cedar top
- WT4 - 24mm Melamine (2400mm H)
- WT5 - Timber stud wall 90mm x 45mm w/ 2mm glue + 6mm Bricklane tile
- WT6 - Timber stud wall 90mm x 45mm w/ 2mm glue + 6mm square tile

Door Types

- DO1 - 915mm x 2134mm Flush w/ Blk Frame
- DO2 - 813mm x 2134mm Flush w/ Blk Frame
- DO3 - 762mm x 2000mm Toilet Cubicle Door
- DO4 - 915mm x 2134mm Glass w/ Blk Frame
- DO5 - 762mm x 2134mm Glass w/ Blk Frame

Window Types

- W01 - 815mm x 2850mm Frosted Glass w/ Blk Frame
- W02 - 815mm x 2210mm Glass w/ Blk Frame

Abbreviations

- | | | | |
|-----|-----------|----|-----------------|
| BLK | Black | SA | Sanitary |
| DO | Door | SS | Stainless Steel |
| EQ | Equipment | WO | Window |
| FI | Fixture | WT | Wall Type |
| FU | Furniture | W/ | With |

Tag Legend

- FU01 - 2x Medium Locker by Elite Office Furniture
- FU02 - Chair by Colesse 'Joel'
- FU03 - Chair by Colesse 'Sidewalk'
- FU04 - 2 Seater Lounge by by Colesse 'Sidewalk'
- FU05 - Coffee table by Metro 'Topo'
- FU06 - Coffee table by Temple and Webster
- FU07 - Office Chair by Colesse 'Bridu'
- FU08 - Reception Desk by Elite Office Furniture 'Casnan Premier Sorrento Reception Counter'
- FU09 - Office Desk by Modern Furniture 'Aftan Executive Desk'
- EQ01 - Drinking Fountain by Filtrine 'FCC-107-14-HL-VP'
- EQ02 - Treadmill by Nordic Track 'Sport 50'
- EQ03 - Exercise bike by Nordic Track 'S101 Studio Bike'
- EQ04 - Leg press by Aussie Fitness 'Gym King HS'
- EQ05 - Gym Bench by Aussie Fitness 'Gym King Flat bench'
- EQ06 - Squat Rack by Aussie Fitness 'Gym King Commercial Smith Machine'
- EQ07 - Power Rack by Aussie Fitness 'Gym King Commercial Power Rack'
- EQ08 - Dumbbell Rack by Commercial Fitness Equipment 'Titanium USA Monster Series'
- EQ09 - Weight Rack by Sumo Strength 'barbarian Rack Package'
- EQ10 - Sauna Panel by Jacuzzi Clearlight Saunas 'Custom Kit'
- SA01 - Basin by Temple and Webster 'Tulip Wall Hung Basin'
- SA02 - Toilet by Temple and Webster 'White Minna Rimless BTM'
- SA03 - Shower Head by Temple and Webster '2 Piece Square Shower Head'
- SA04 - Drain by Temple and Webster '11x11 Square Shower Grate Floor Drain'
- SA08 - Disable toilet sign by Kaster Hardware 'AS1428 Compliant Toilet Sign SILVER Unisex Disabled'
- SA10 - Bathroom mirror / dryer / soap by Bradley Australia 'bradley behind mirror foam soap and hand dryer'
- SA11 - Toilet Roll Holder by Estlio 'Chrome Bela Single roll Holder'
- SA12 - Shower Mixer by The Blue Space 'Phoenix Vivid Slimline Shower/Wall Mixer'
- SA13 - Toilet flush button by Icon Bathware 'Invisi Series II'
- F104 - Sled Track by Raw Fitness Equipment 'Custom Gym Sled'
- LI01 - Light up Mirror by ATS Tiles and Bathroom 'Retti Rectangular LED Mirror'
- LI02 - LED Logo by Big Banner
- MA01 - Polished Concrete
- MA02 - GYM MAT
- MA03 - Custom Sled turf by Raw Fitness Equipment 'Custom Gym Sled'
- MA04 - Brick Lane Tiles by National Tiles
- MA05 - Paint finish by Porters Paints 'Mountain Ash'
- MA06 - Paint finish by Porters Paints 'Custom Frontline Green'
- MA07 - Tiles by National Tiles 'Zellige White Matt Tile'
- MA08 - Paint finish by Porters Paints 'Anisced'
- MA09 - Cedar Wood

REVISIONS

No Date
01 27.10.21

Description
PRESENTATION DRAWINGS
NOT FOR CONSTRUCTION

Ver. App'd
XX App'd

Do not scale drawings. Use figured dimensions only. Check and verify levels and dimensions on site prior to commencement of any work, the preparation of drawings or the fabrication of components.
This drawing is copyright and can not be reproduced without written consent.

Client

Moey Faour



True North

True North

Billy Blue College of Design
46-52 Mountain Street, Ultimo, NSW 2007, Australia
+61 (0)2 9999 9999



Project

Frontline Fitness

630 Canterbury Road,
Belmore, NSW. 2192

Project number

01

Drawing Title

Reception Elevation 2

Drawing Status

PRESENTATION
DRAWINGS
NOT FOR
CONSTRUCTION


Scale Drawing No Issue
1 : 10 D22 01

Date 27.10.21

Drawn by MB

0 0.1 0.25 0.5m
1 : 10

6/12/2021 3:54:32 AM

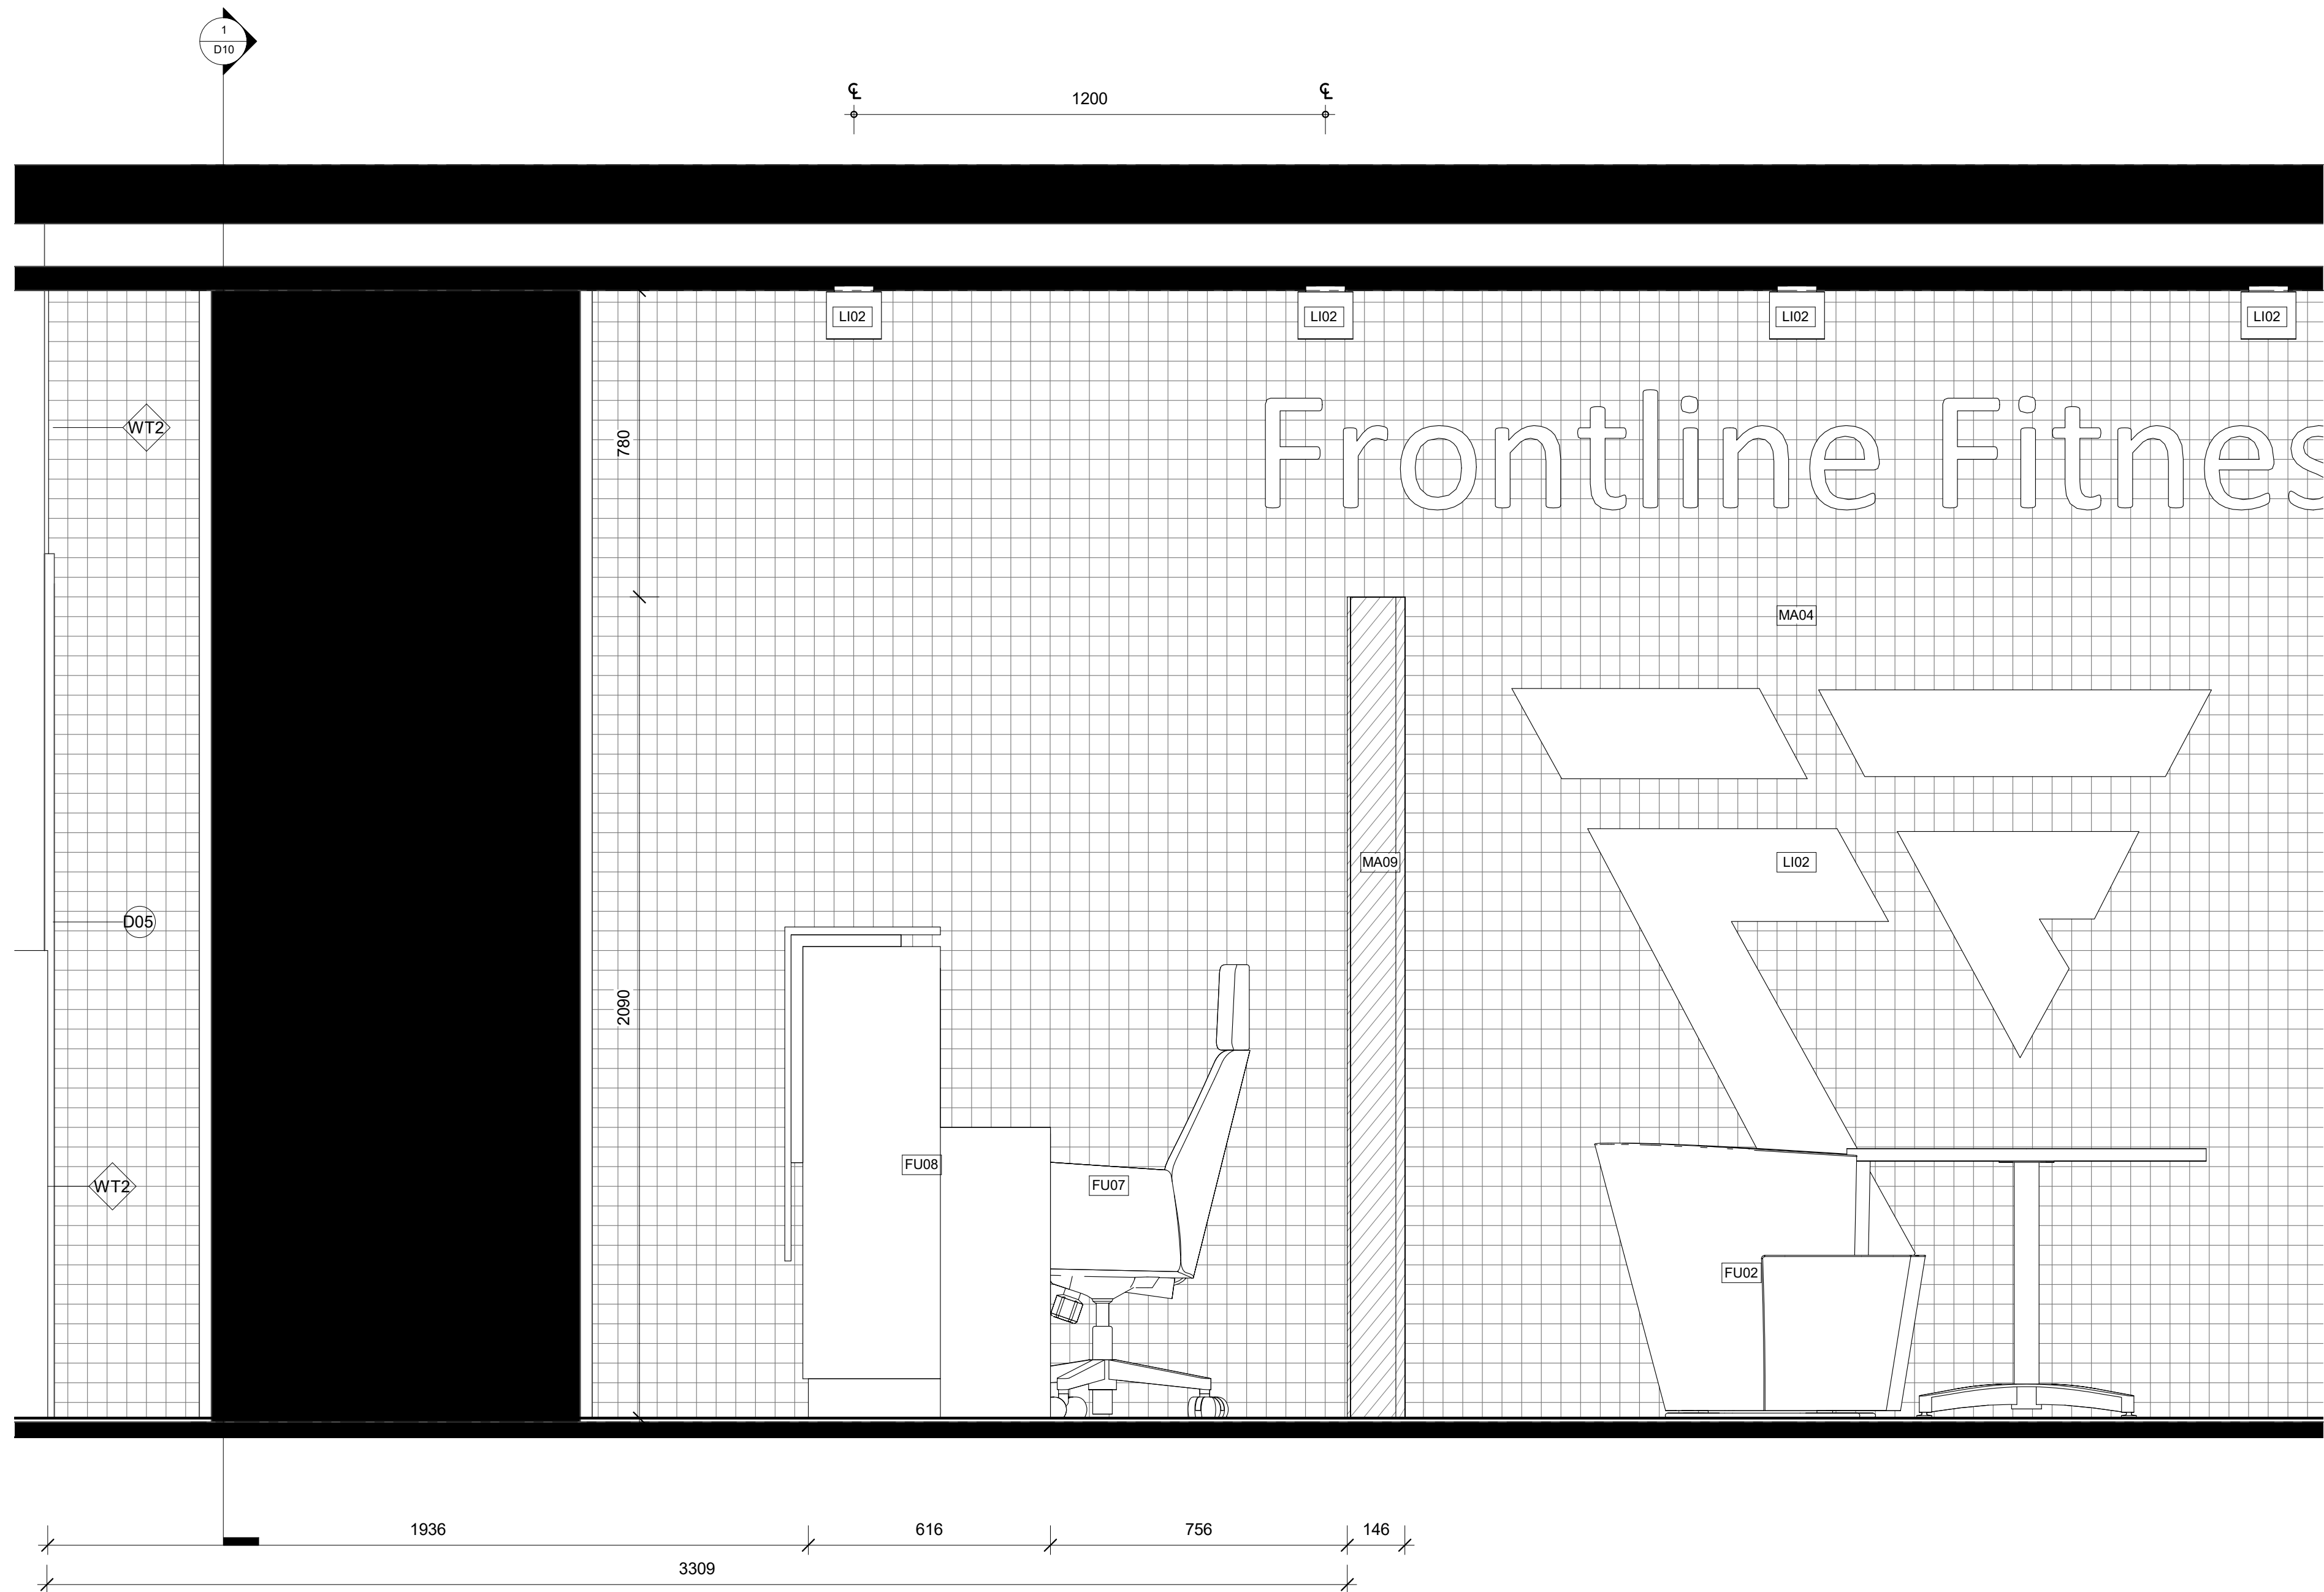

LEGEND

Cut Material

Glass

Cedar

Concrete

Gym Mat

Tiles

Plaster Board

Existing Structure

Wall Types

WT1

WT2

WT3

WT4

WT5

WT6

Door Types

DO1

DO2

DO3

DO4

DO5

Window Types

W01

W02

Abbreviations

BLK

DO

EQ

FI

FU

Black

Door

Equipment

Fixture

Furniture

SA

SS

WD

WT

W

Sanitary

Stainless Steel

Window

Wall Type

With

Tag Legend

FU01

FU02

FU03

FU04

FU05

FU06

FU07

FU08

FU09

EQ01

EQ02

EQ03

EQ04

EQ05

EQ06

EQ07

EQ08

EQ09

EQ10

SA01

SA02

SA03

SA04

SA05

SA10

SA11

SA12

SA13

F104

LI01

LI02

MA01

MA02

MA03

MA04

MA05

MA06

MA07

MA08

MA09

2x Medium Locker by Elite Office Furniture

Chair by Coalesse 'Joel'

Chair by Coalesse 'Joel'

2 Seater Lounge by by Coalesse 'Sidewalk'

Coffee table by Metro 'Topo'

Coffee table by Temple and Webster

Office Chair by Coalesse 'Bindu'

Reception Desk by Elite Office Furniture 'Casanan Premier Sonetto Reception Counter'

Office Desk by Modern Furniture 'Aftan Executive Desk'

Drinking Fountain by Filtrine 'FCO-107-14-HL-VP'

Treadmill by Nordic Track 'Sport 50'

Exercise bike by Nordic Track 'S10 Studio Bike'

Leg press by Aussie Fitness 'Gym King HS'

Gym Bench by Aussie Fitness 'Gym King Flat bench'

Squat Rack by Aussie Fitness 'Gym King Commercial Smith Machine'

Power Rack by Aussie Fitness 'Gym King Commercial Power Rack'

Dumbbell Rack by Commercial Fitness Equipment

Titanium USA Monster Series

Weight Rack by Sumo Strenight 'barbarian Rack Package'

Sauna Panel by Jacuzzi Clearlight Saunas 'Custom Kit'

Basin by Temple and Webster 'Tulip Wall Hung Basin'

Toilet by Temple and Webster 'White Minna Rimless BTW'

Shower Head by Temple and Webster '2 Piece Square Shower Head'

Drain by Temple and Webster '11x11 Square Shower Grate Floor Drain'

Disable toilet sign by Keeler Hardware 'AS1428 Compliant Toilet Sign SILVER Unisex Disabled'

Bathroom mirror / dryer / soap by Bradley Australia 'bradley behind mirror foam soap and hand dryer'

Toilet Roll Holder by Estilo 'Chrome Beta Single roll holder'

Shower Mixer by The Blue Space 'Phoenix Vivid Slimline Shower/Wall Mixer'

Toilet flush button by Icon Bathware 'Invisi Series II'

Sled Track by Raw Fitness Equipment 'Custom Gym Sled'

Light up Mirror by ATS Tiles and Bathroom 'Retli Rectangular LED Mirror'

LED Logo by Big Banner

Polished Concrete

GYM MAT

Custom Sled turf by Raw Fitness Equipment 'Custom Gym Sled'

Brick Lane Tiles by National Tiles

Paint finish by Porters Paints 'Mountain Ash'

Paint finish by Porters Paints 'Custom Frontline Green'

Tiles by National Tiles 'Zellige White Matt Tile'

Paint finish by Porters Paints 'Anisced'

Cedar Wood

REVISIONS

No

Date

01

27.10.21

Description

PRESENTATION DRAWINGS
NOT FOR CONSTRUCTION

Ver.

App'd

XX App'd

Do not scale drawings. Use figured dimensions only. Check and verify levels and dimensions on site prior to commencement of any work, the preparation of drawings or the fabrication of components.
This drawing is copyright and can not be reproduced without written consent.

Client

Moey Faour

True North

Billy Blue College of Design
46-52 Mountain Street, Ultimo, NSW 2007, Australia
+61 (0)2 9999 9999

BILLY BLUE
COLLEGE OF DESIGN

TORRENS
UNIVERSITY
AUSTRALIA

LAUREATE INTERNATIONAL UNIVERSITIES

Project

Frontline Fitness

630 Canterbury Road,
Belmore, NSW. 2192

Project number
01

Drawing Title

Reception Elevation 3

Drawing Status

PRESENTATION
DRAWINGS
NOT FOR
CONSTRUCTION

Scale

Drawing No

Issue

1 : 10

D23

01

Date


27.10.21

Drawn by

MB

6/12/2021 3:54:39 AM

A1

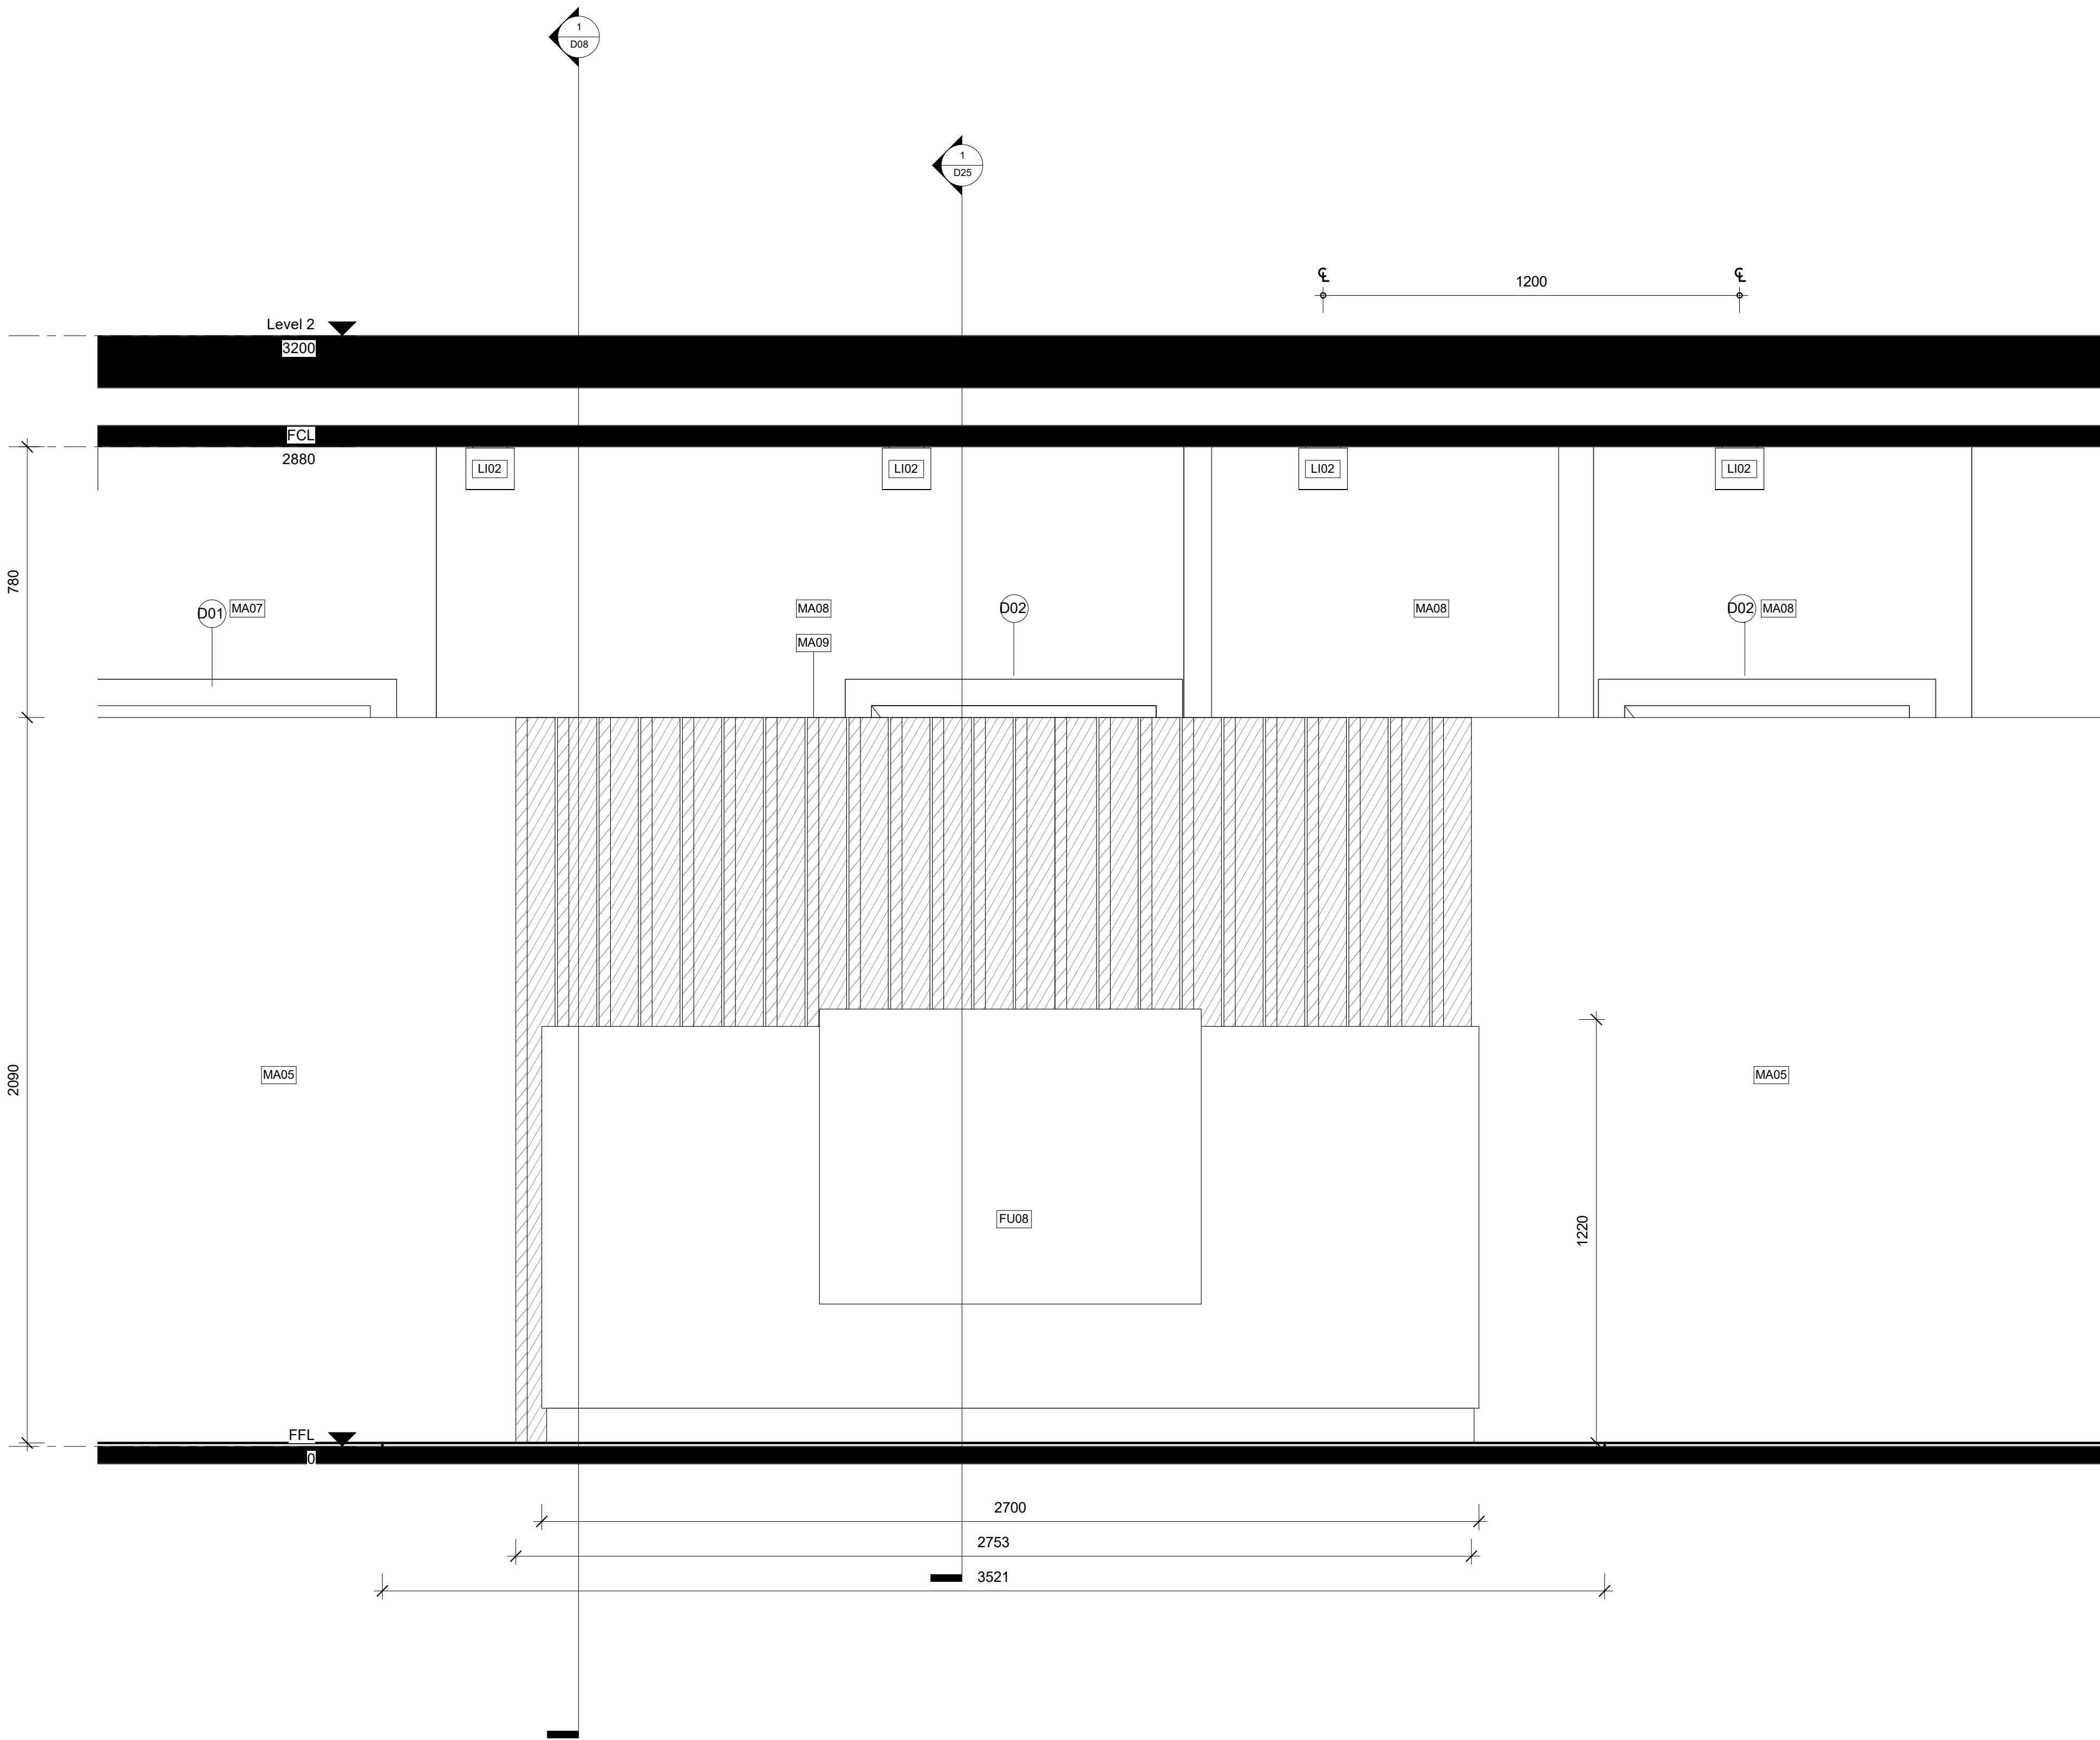

LEGEND

Cut Material

	Glass		Tiles
	Cedar		Plaster Board
	Concrete		Existing Structure
	Gym Mat		

Wall Types

	Timber stud wall 90mm x 45mm w/ 9mm Plaster board and 'Mountain Ash - Low sheen' Paint finish
	'Custom Frontline Green - Low sheen' Paint finish (1200mm H)
	Timber stud wall 90mm x 45mm w/ 12mm timber cedar top
	24mm Melamine (2400mm H)
	Timber stud wall 90mm x 45mm w/ 2mm glue + 6mm Bricklane tile
	Timber stud wall 90mm x 45mm w/ 2mm glue + 6mm square tile

Door Types

	915mm x 2134mm Flush w/ Blk Frame
	813mm x 2134mm Flush w/ Blk Frame
	762mm x 2000mm Toilet Cubicle Door
	915mm x 2134mm Glass w/ Blk Frame
	762mm x 2134mm Glass w/ Blk Frame

Window Types

	815mm x 2850mm Frosted Glass w/ Blk Frame
	815mm x 2210mm Glass w/ Blk Frame

Abbreviations

BLK	Black	SA	Sanitary
D0	Door	SS	Stainless Steel
EQ	Equipment	WO	Window
FI	Fixture	WT	Wall Type
FU	Furniture	WI	Win

Tag Legend

FU01 - 2x Medium Locker by Elite Office Furniture
FU02 - Chair by Colesse 'Joel'
FU03 - Chair by Colesse 'Sidewalk'
FU04 - 2 Seater Lounge by by Colesse 'Sidewalk'
FU05 - Coffee table by Metro 'Topo'
FU06 - Coffee table by Temple and Webster
FU07 - Office Chair by Colesse 'Bindu'
FU08 - Reception Desk by Elite Office Furniture 'Casnan Premier Sorrento Reception Counter'
FU09 - Office Desk by Modern Furniture 'Aftan Executive Desk'
EQ01 - Drinking Fountain by Filtrine 'FCO-107-14-HL-VIP'
EQ02 - Treadmill by Nordic Track 'Sport 50'
EQ03 - Exercise bike by Nordic Track 'S10 Studio Bike'
EQ04 - Leg press by Aussie Fitness 'Gym King HS'
EQ05 - Gym Bench by Aussie Fitness 'Gym King Flat bench'
EQ06 - Squat Rack by Aussie Fitness 'Gym King Commercial Smith Machine'
EQ07 - Power Rack by Aussie Fitness 'Gym King Commercial Power Rack'
EQ08 - Dumbell Rack by Commercial Fitness Equipment 'Titanum USA Monster Series'
EQ09 - Weight Rack by Sumo Strength 'barbarian Rack Package'
EQ10 - Sauna Panel by Jacuzzi Clearlight Saunas 'Custom Kit'
SA01 - Basin by Temple and Webster 'Tulip Wall Hung Basin'
SA02 - Toilet by Temple and Webster 'White Minna Rimless BTW'
SA03 - Shower Head by Temple and Webster '2 Piece Square Shower Head'
SA04 - Drain by Temple and Webster '11x11 Square Shower Grate Floor Drain'
SA05 - Disable toilet sign by Keeler Hardware 'AS1428 Compliant Toilet Sign SILVER Unless Disabled'
SA10 - Bathroom mirror / dryer / soap by Bradley Australia 'bradley behind mirror foam soap and hand dryer'
SA11 - Toilet Roll Holder by Estlio 'Chrome Beta Single roll Holder'
SA12 - Shower Mixer by The Blue Space 'Phoenix Vivid Slimline Shower/Wall Mixer'
SA13 - Toilet flush button by Icon Bathware 'Invisi Series II'
F104 - Sled Track by Raw Fitness Equipment 'Custom Gym Sled'
LI01 - Light up Mirror by ATS Tiles and Bathroom 'Retti Rectangular LED Mirror'
LI02 - LED Logo by Big Banner
MA01 - Polished Concrete
MA02 - GYM MAT
MA03 - Custome Sled turf by Raw Fitness Equipment 'Custom Gym Sled'
MA04 - Brick Lane Tiles by National Tiles
MA05 - Paint finish by Porters Paints 'Mountain Ash'
MA06 - Paint finish by Porters Paints 'Custom Frontline Green'
MA07 - Tiles by National Tiles 'Zellige White Matt Tile'
MA08 - Paint finish by Porters Paints 'Anisced'
MA09 - Cedar Wood

Legend 1

1 : 50

REVISIONS

No Date
01 27.10.21

Description
PRESENTATION DRAWINGS
NOT FOR CONSTRUCTION

Ver. App'd
XX App'd

Do not scale drawings. Use figured dimensions only. Check and verify levels and dimensions on site prior to commencement of any work, the preparation of drawings or the fabrication of components.
This drawing is copyright and can not be reproduced without written consent.

Client

Moey Faour



Frontline Fitness
"LEADING FROM THE FRONT"

True North

Billy Blue College of Design
46-52 Mountain Street, Ultimo, NSW 2007, Australia
+61 (0)2 9999 9999



Project

Frontline Fitness

630 Canterbury Road,
Belmore, NSW. 2192

Project number

01

Drawing Title

Reception Elevation 4

Drawing Status

PRESENTATION
DRAWINGS
NOT FOR
CONSTRUCTION



Scale Drawing No Issue
1 : 10 D24 01

Date 27.10.21

Drawn by MB

6/12/2021 3:54:45 AM

A1

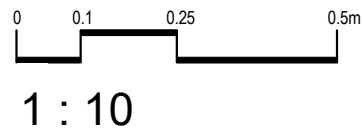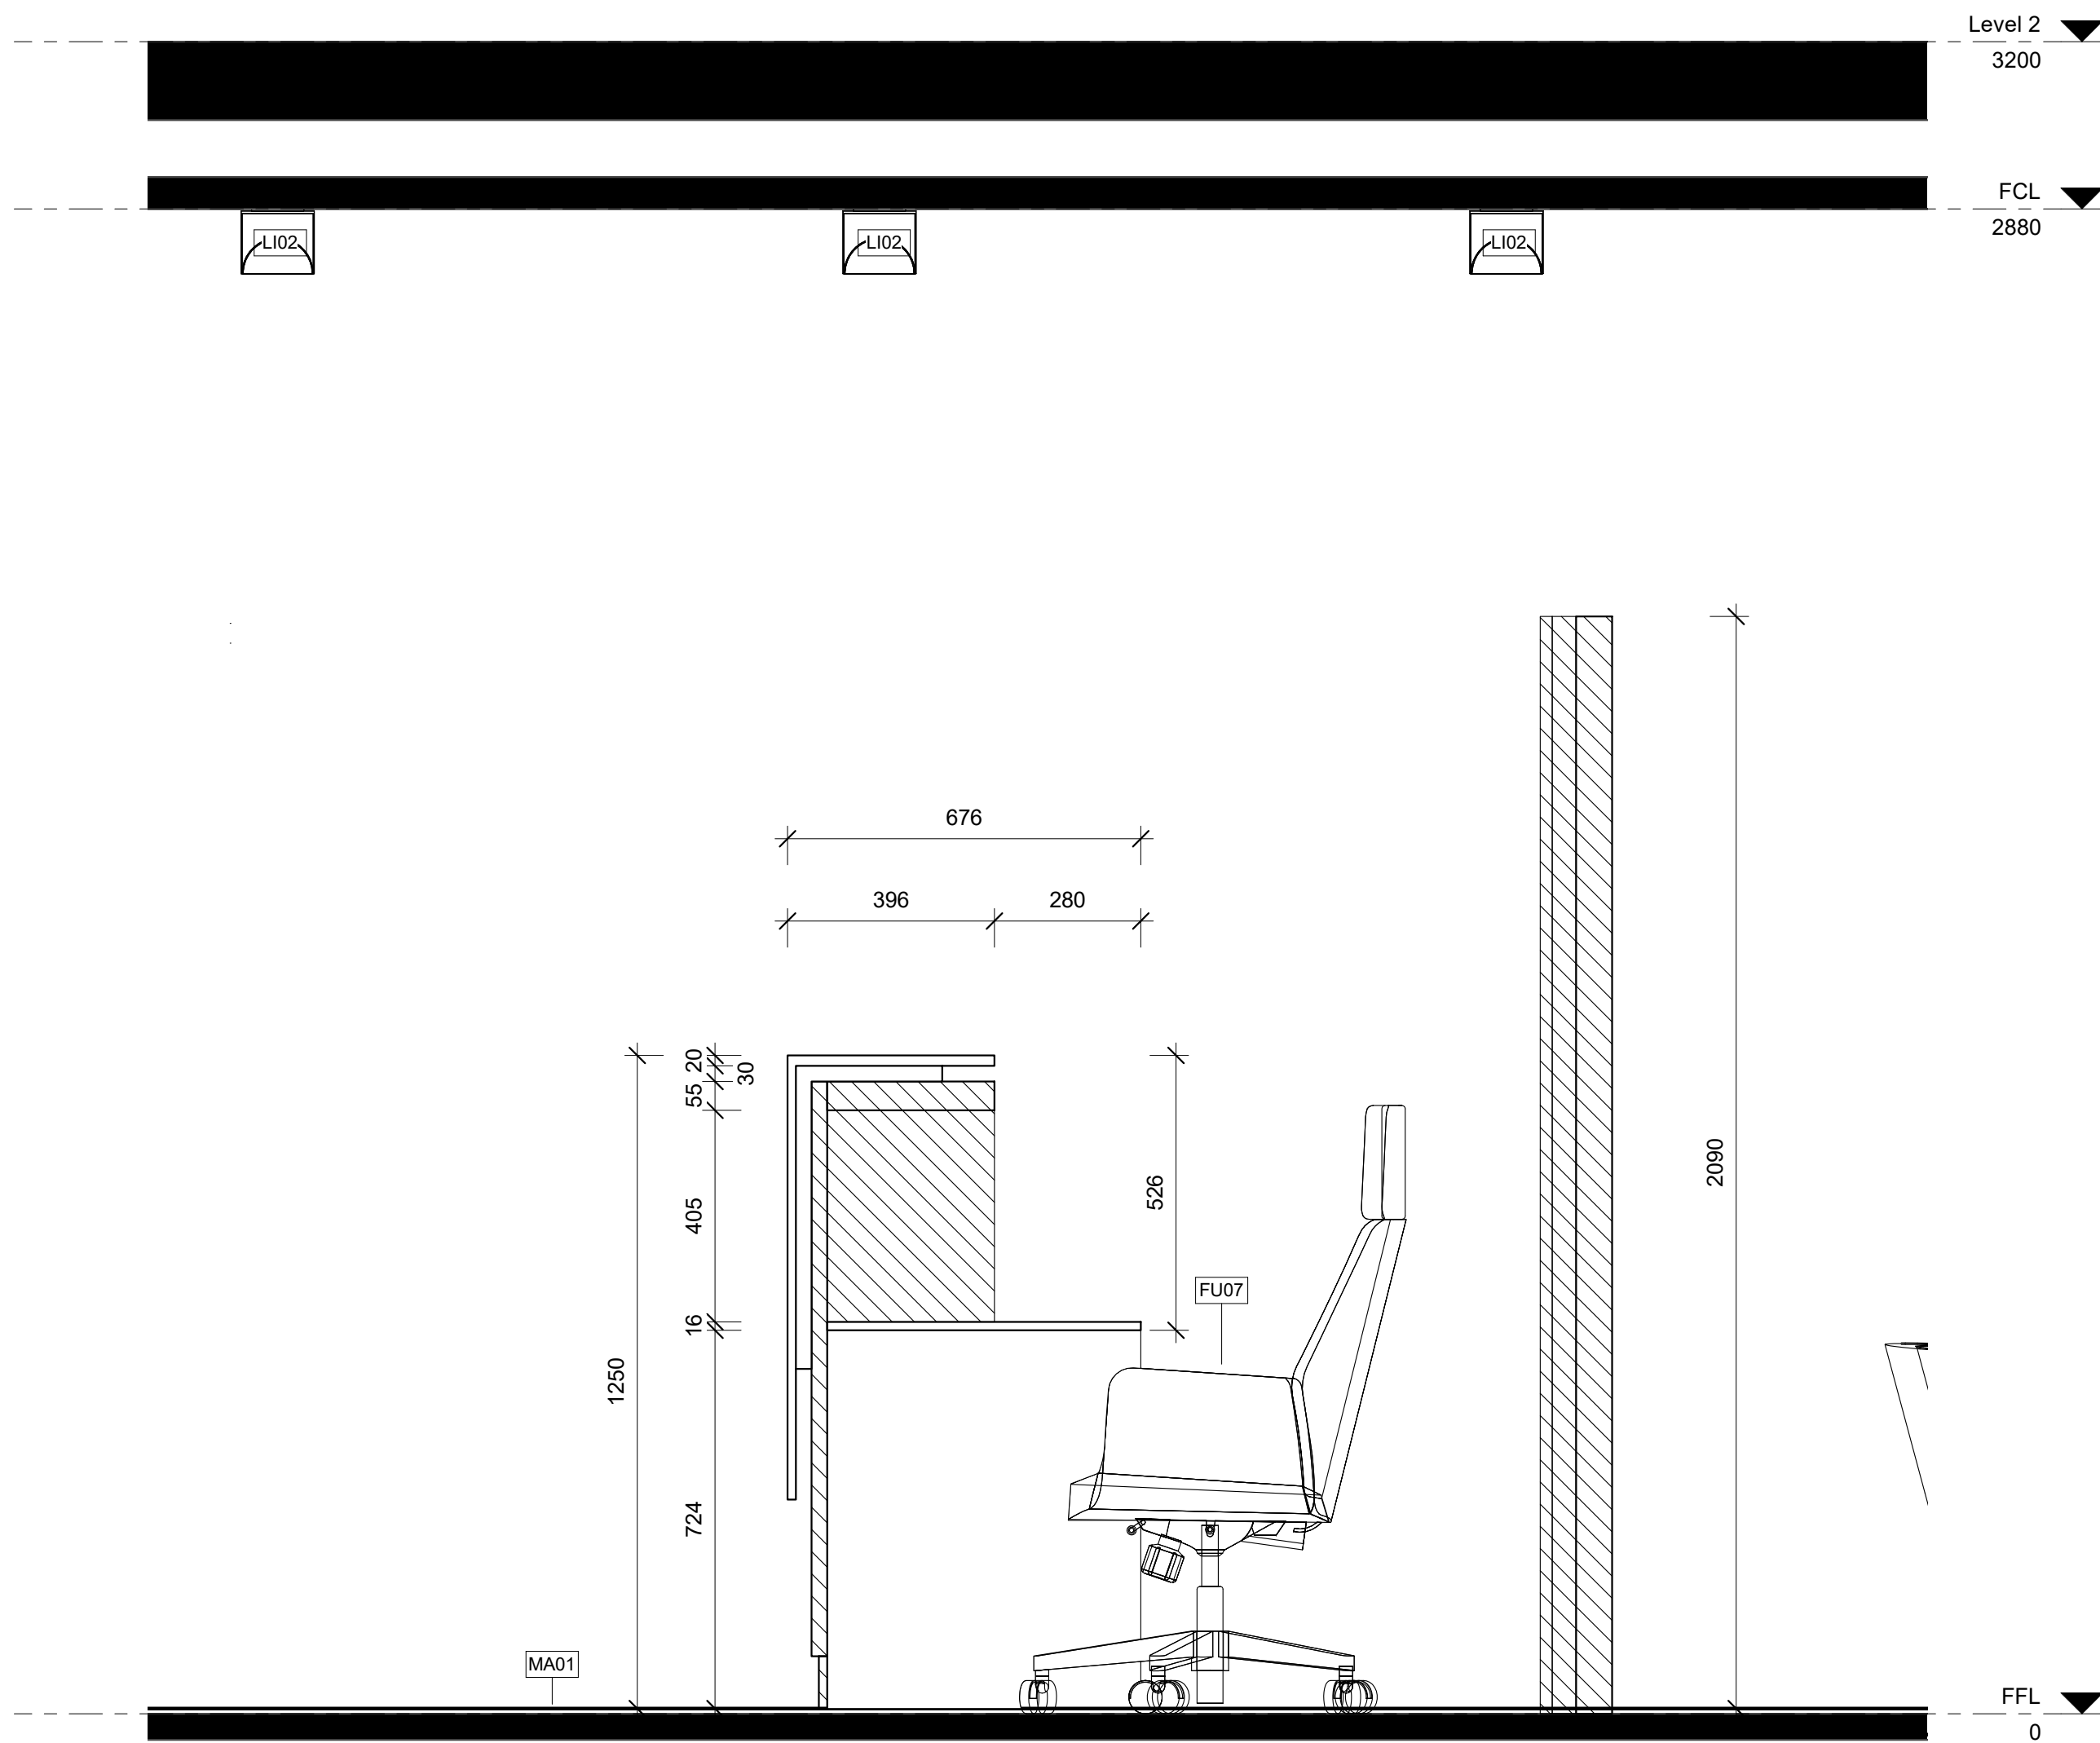

LEGEND

Cut Material

	Glass		Tiles
	Cedar		Plaster Board
	Concrete		Existing Structure
	Gym Mat		

Wall Types

	Timber stud wall 90mm x 45mm w/ 9mm Plaster board and 'Mountain Ash - Low sheen' Paint finish
	'Custom Frontline Green - Low sheen' Paint finish (1200mm H)
	Timber stud wall 90mm x 45mm w/ 12mm timber cedar top
	24mm Melamine (2400mm H)
	Timber stud wall 90mm x 45mm w/ 2mm glue + 6mm Bricklane tile
	Timber stud wall 90mm x 45mm w/ 2mm glue + 6mm square tile

Door Types

	915mm x 2134mm Flush w/ Blk Frame
	813mm x 2134mm Flush w/ Blk Frame
	762mm x 2000mm Toilet Cubicle Door
	915mm x 2134mm Glass w/ Blk Frame
	762mm x 2134mm Glass w/ Blk Frame

Window Types

	815mm x 2850mm Frosted Glass w/ Blk Frame
	815mm x 2210mm Glass w/ Blk Frame

Abbreviations

BLK	Black	SA	Sanitary
DO	Door	SS	Stainless Steel
EQ	Equipment	W0	Window
FI	Fixture	WT	Wall Type
FU	Furniture	W/	Win

Tag Legend

FU01 - 2x Medium Locker by Elite Office Furniture
FU02 - Chair by Coalesse 'Joel'
FU03 - Chair by Coalesse 'Sidewalk'
FU04 - 2 Seater Lounge by by Coalesse 'Sidewalk'
FU05 - Coffee table by Metro 'Topo'
FU06 - Coffee table by Temple and Webster
FU07 - Office Chair by Coalesse 'Bendu'
FU08 - Reception Desk by Elite Office Furniture 'Casnan Premier Sorrento Reception Counter'
FU09 - Office Desk by Modern Furniture 'Atlan Executive Desk'
EQ01 - Drinking Fountain by Filtime 'FCG-107-14-HL-UP'
EQ02 - Treadmi by Nordic Track 'Sport 50'
EQ03 - Exercise bike by Nordic Track 'S10i Studio Bike'
EQ04 - Leg press by Aussie Fitness 'Gym King HS'
EQ05 - Gym Bench by Aussie Fitness 'Gym King Flat bench'
EQ06 - Squat Rack by Aussie Fitness 'Gym King Commercial Smith Machine'
EQ07 - Power Rack by Aussie Fitness 'Gym King Commercial Power Rack'
EQ08 - Dumbell Rack by Commercial Fitness Equipment 'Titanium USA Monster Series'
EQ09 - Weight Rack by Sumo Strenghth 'barbarian Rack Package'
EQ10 - Sauna Panel by Jacuzzi Clearlight Saunas 'Custom Kit'
SA01 - Basin by Temple and Webster 'Tulip Wall Hung Basin'
SA02 - Toilet by Temple and Webster 'White Minna Rimless BTW'
SA03 - Shower Head by Temple and Webster '2 Piece Square Shower Head'
SA04 - Drain by Temple and Webster '11x11 Square Shower Grate Floor Drain'
SA08 - Disable toilet sign by Keeler Hardware 'AS1428 Compliant Toilet Sign SILVER Unisex Disabled'
SA10 - Bathroom mirror / dryer / soap by Bradley Australia 'bradley behind mirror foam soap and hand dryer'
SA11 - Toilet Roll Holder by Estilo 'Chrome Bela Single roll Holder'
SA12 - Shower Mixer by The Blue Space 'Phoenix Vivid Slimline Shower/Wall Mixer'
SA13 - Toilet flush button by Icon Bathware 'Invisi Series II'
FI04 - Sled Track by Raw Fitness Equipment 'Custom Gym Sled'
LI01 - Light Up Mirror by ATS Tiles and Bathroom 'Retti Rectangular LED Mirror'
LI02 - LED Logo by Big Banner
MA01 - Polished Concrete
MA02 - GYM MAT
MA03 - Custome Sled turf by Raw Fitness Equipment 'Custom Gym Sled'
MA04 - Brick Lane Tiles by National Tiles
MA05 - Paint finish by Porters Paints 'Mountain Ash'
MA06 - Paint finish by Porters Paints 'Custom Frontline Green'
MA07 - Tiles by National Tiles 'Zellige White Matt Tile'
MA08 - Paint finish by Porters Paints 'Aniseed'
MA09 - Cedar Wood

REVISIONS

No Date
01 27.10.21

Description
PRESENTATION DRAWINGS
NOT FOR CONSTRUCTION

Ver. App'd
XX App'd

Do not scale drawings. Use figured dimensions only. Check and verify levels and dimensions on site prior to commencement of any work, the preparation of drawings or the fabrication of components.
This drawing is copyright and can not be reproduced without written consent.

Client

Moey Faour



Frontline Fitness
'LEADING FROM THE FRONT'

True North

Billy Blue College of Design
46-52 Mountain Street, Ultimo, NSW 2007, Australia
+61 (0)2 9999 9999



LAUREATE INTERNATIONAL UNIVERSITIES

Project

Frontline Fitness

630 Canterbury Road,
Belmore, NSW. 2192

Project number

01

Drawing Title

Reception Cross-section

Drawing Status

PRESENTATION
DRAWINGS
NOT FOR
CONSTRUCTION

Scale

1 : 10

Drawing No

D25

Issue

01


Date

27.10.21

Drawn by

MB

6/12/2021 3:54:51 AM

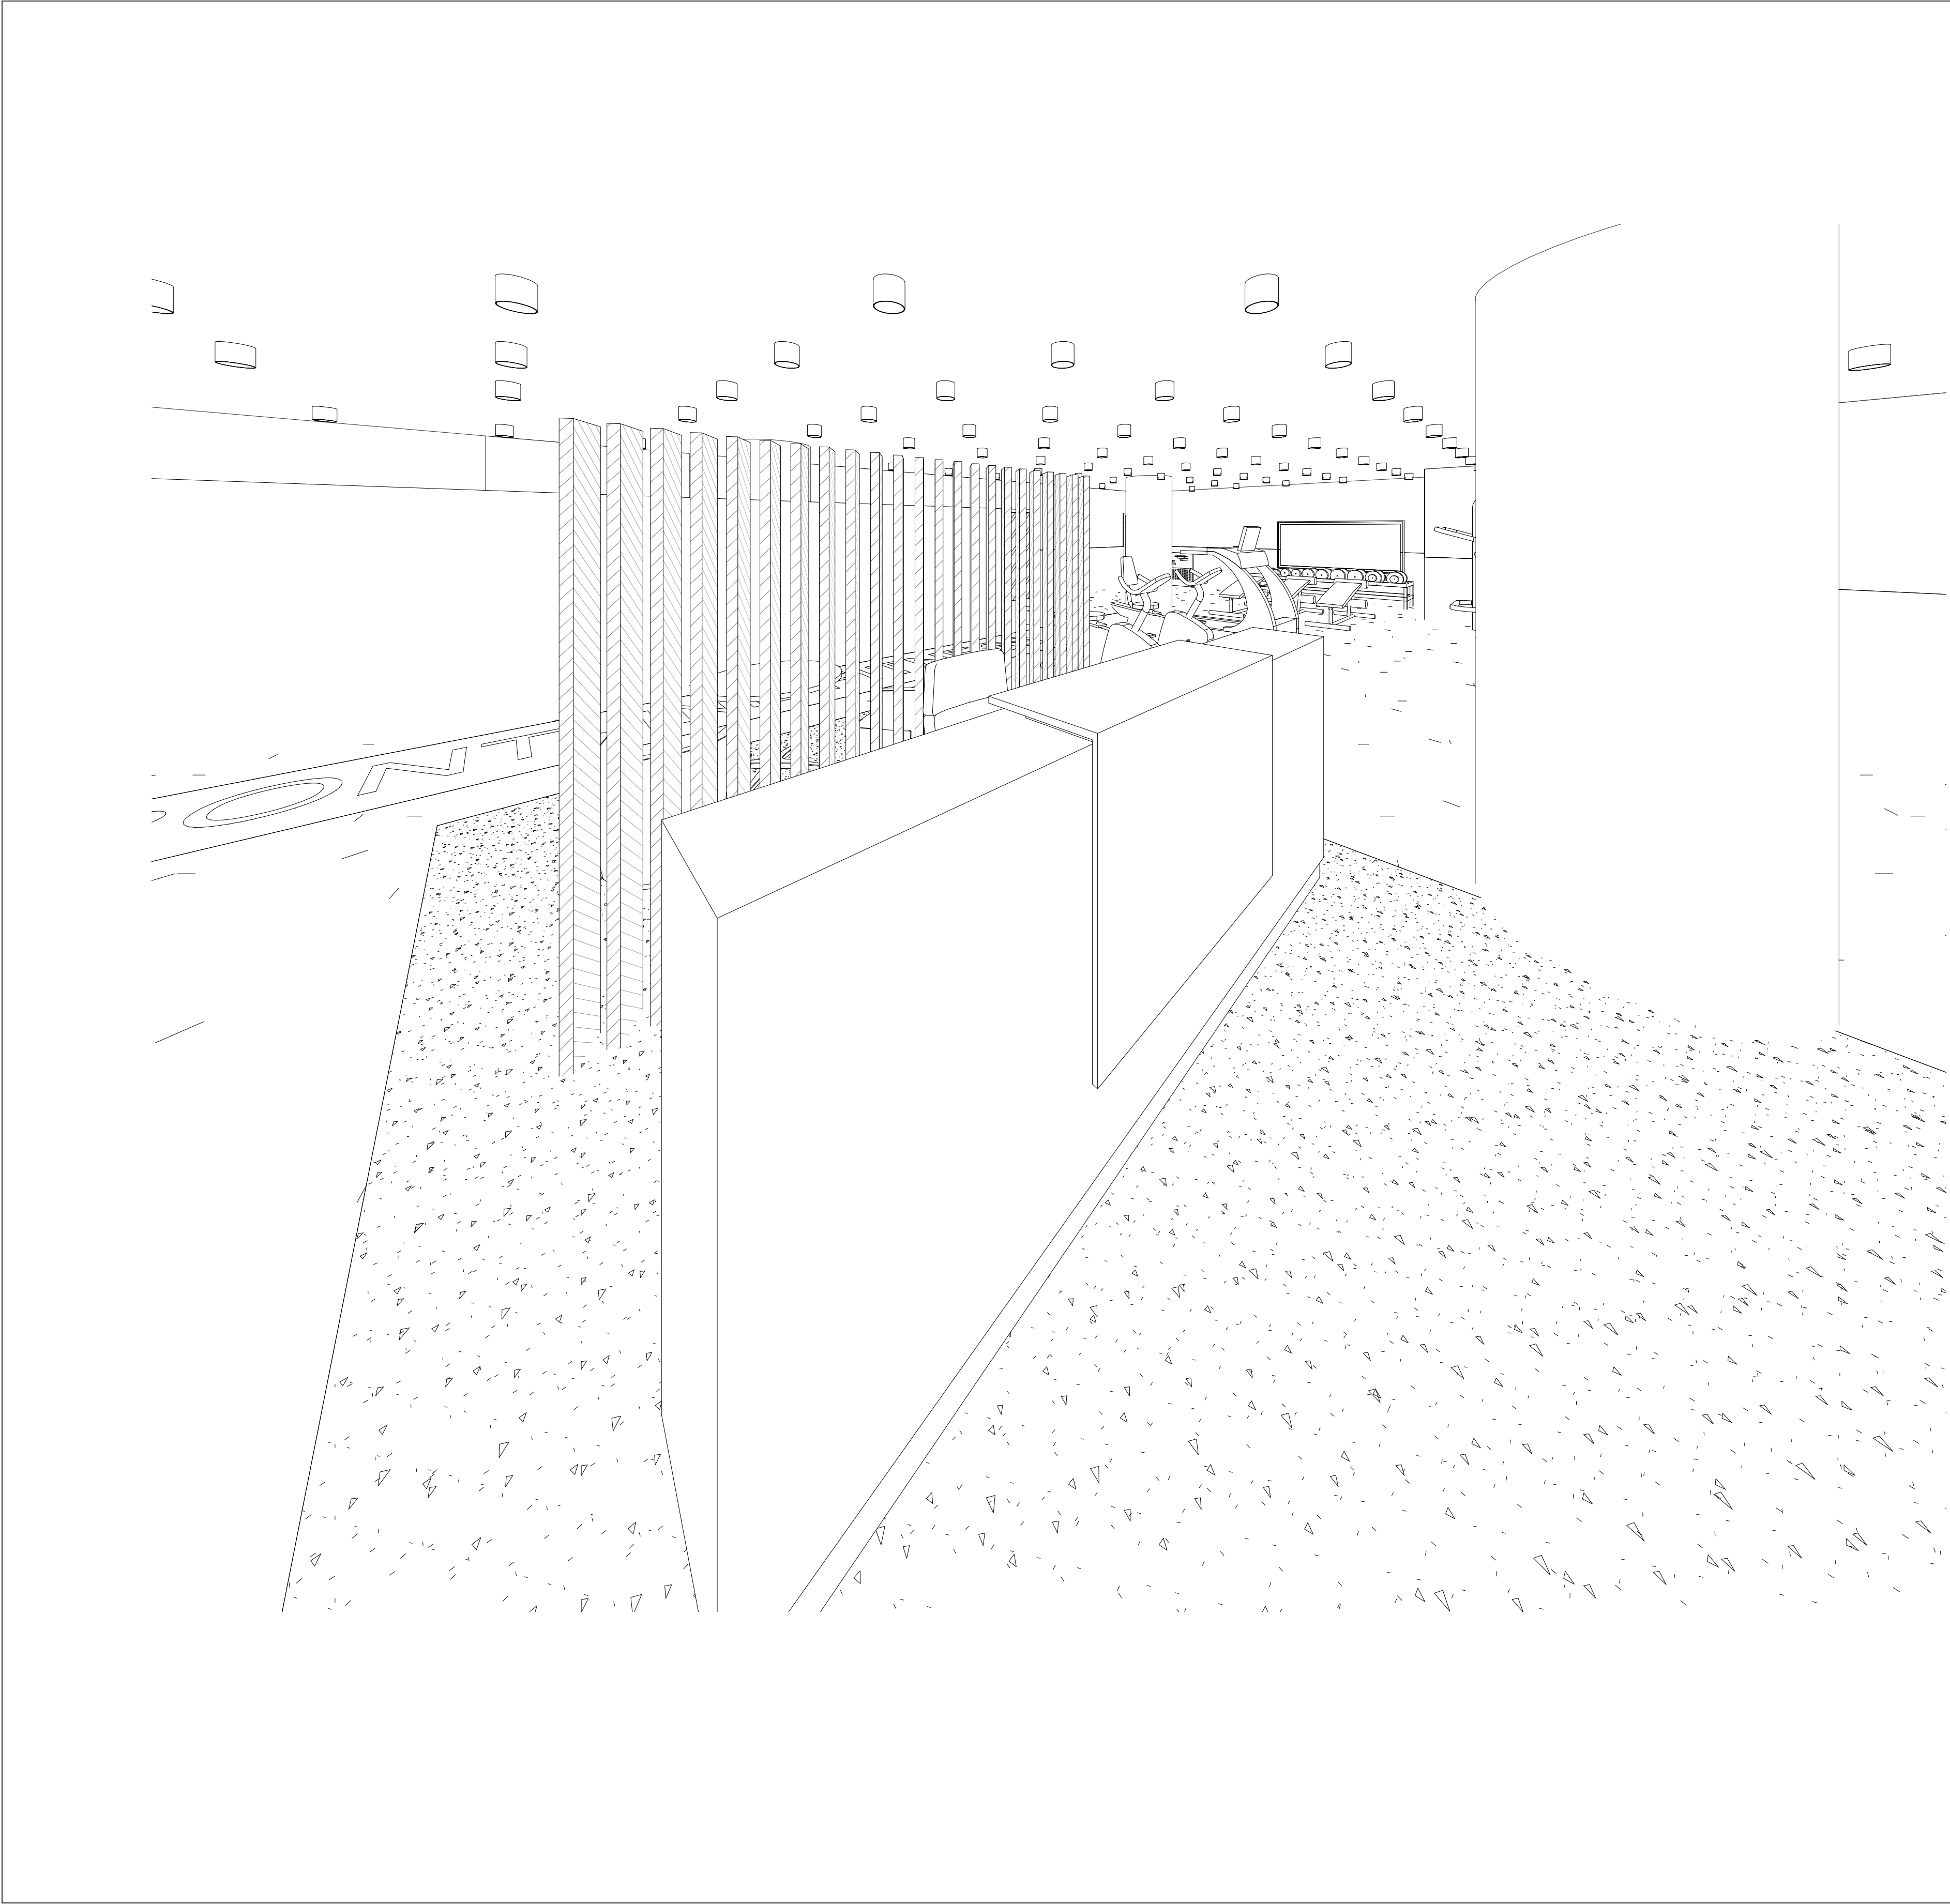

LEGEND	REVISIONS
Cut Material Glass Cedar Concrete Gym Mat Tiles Plaster Board Existing Structure	No Date 01 27.10.21 Description PRESENTATION DRAWINGS NOT FOR CONSTRUCTION Ver. App'd XX App'd
Wall Types WT1 WT2 WT3 WT4 WT5 WT6 Timber stud wall 90mm x 45mm w/ 9mm Plaster board and Mountain Ash - Low sheen Paint finish 'Custom Frontline Green' - Low sheen Paint finish (1200mm H) Timber stud wall 90mm x 45mm w/ 12mm timber cedar top 24mm Melamine (2400mm H) Timber stud wall 90mm x 45mm w/ 2mm glue + 6mm Bricklane tile Timber stud wall 90mm x 45mm w/ 2mm glue + 6mm square tile	Do not scale drawings. Use figured dimensions only. Check and verify levels and dimensions on site prior to commencement of any work, the preparation of drawings or the fabrication of components. This drawing is copyright and can not be reproduced without written consent.
Door Types DO1 DO2 DO3 DO4 DO5 915mm x 2134mm Flush w/ Blk Frame 813mm x 2134mm Flush w/ Blk Frame 762mm x 2000mm Toilet Cubicle Door 915mm x 2134mm Glass w/ Blk Frame 762mm x 2134mm Glass w/ Blk Frame	Client Moey Faour Frontline Fitness "LEADING FROM THE FRONT"
Window Types W01 W02 815mm x 2850mm Frosted Glass w/ Blk Frame 815mm x 2210mm Glass w/ Blk Frame	True North
Abbreviations BLK DO EQ FI FU Black Door Equipment Fixture Furniture SA SS W0 WT W/ Sanitary Stainless Steel Window Wall Type With	Billy Blue College of Design 46-52 Mountain Street, Ultimo, NSW 2007, Australia +61 (0)2 9999 9999 BILLY BLUE COLLEGE OF DESIGN TORRENS UNIVERSITY AUSTRALIA LAUREATE INTERNATIONAL UNIVERSITIES
Tag Legend FU01 - 2x Medium Locker by Elite Office Furniture FU02 - Chair by Coalesse Joell FU03 - Chair by Coalesse Sidewalk FU04 - 2 Seater Lounge by by Coalesse Sidewalk FU05 - Coffee table by Metro Topo FU06 - Coffee table by Temple and Webster FU07 - Office Chair by Coalesse Bindu FU08 - Reception Desk by Elite Office Furniture Casnan Premier Sorrento Reception Counter FU09 - Office Desk by Modern Furniture Aftan Executive Desk EQ01 - Drinking Fountain by Filtrine FCC-107-14-HL-VP EQ02 - Treadmill by Nordic Track Sport 50 EQ03 - Exercise bike by Nordic Track S10 Studio Bike EQ04 - Leg press by Aussie Fitness Gym King HS EQ05 - Gym Bench by Aussie Fitness Gym King Flat bench EQ06 - Squat Rack by Aussie Fitness Gym King Commercial Smith Machine EQ07 - Power Rack by Aussie Fitness Gym King Commercial Power Rack EQ08 - Dumbbell Rack by Commercial Fitness Equipment Titanium USA Monster Series EQ09 - Weight Rack by Sumo Strenghtr barbarian Rack Package EQ10 - Sauna Panel by Jacuzzi Clearlight Saunas Custom Kit SA01 - Basin by Temple and Webster Tulip Wall Hung Basin SA02 - Toilet by Temple and Webster White Minna Rimless BTW SA03 - Shower Head by Temple and Webster 2 Piece Square Shower Head SA04 - Drain by Temple and Webster 11x11 Square Shower Grate Floor Drain SA08 - Disable toilet sign by Keeler Hardware AS1428 Compliant Toilet Sign SILVER Unless Disabled SA10 - Bathroom mirror / dryer / soap by Bradley Australia Bradley behind mirror foam soap and hand dryer SA11 - Toilet Roll Holder by Etillo Chrome Beta Single roll Holder SA12 - Shower Mixer by The Blue Space Phoenix Vivid Slimline Shower/Wall Mixer SA13 - Toilet flush button by Icon Bathware Invisi Series II F104 - Sled Track by Raw Fitness Equipment Custom Gym Sled L01 - Light up Mirror by ATS Tiles and Bathroom Retti Rectangular LED Mirror L02 - LED Logo by Big Banner MA01 - Polished Concrete MA02 - GYM MAT MA03 - Custome Sled turf by Raw Fitness Equipment Custom Gym Sled MA04 - Brick Lane Tiles by National Tiles MA05 - Paint finish by Porters Paints Mountain Ash MA06 - Paint finish by Porters Paints Custome Frontline Green MA07 - Tiles by National Tiles Zellige White Matt Tile MA08 - Paint finish by Porters Paints Aniseed MA09 - Cedar Wood	Project Frontline Fitness 630 Canterbury Road, Belmore, NSW. 2192 Project number 01
Drawing Title Reception Isometric View	Drawing Status PRESENTATION DRAWINGS NOT FOR CONSTRUCTION
Scale N/A Date 27.10.21 Drawn by MB	Drawing No D26 Issue 01

6/12/2021 3:55:02 AM